

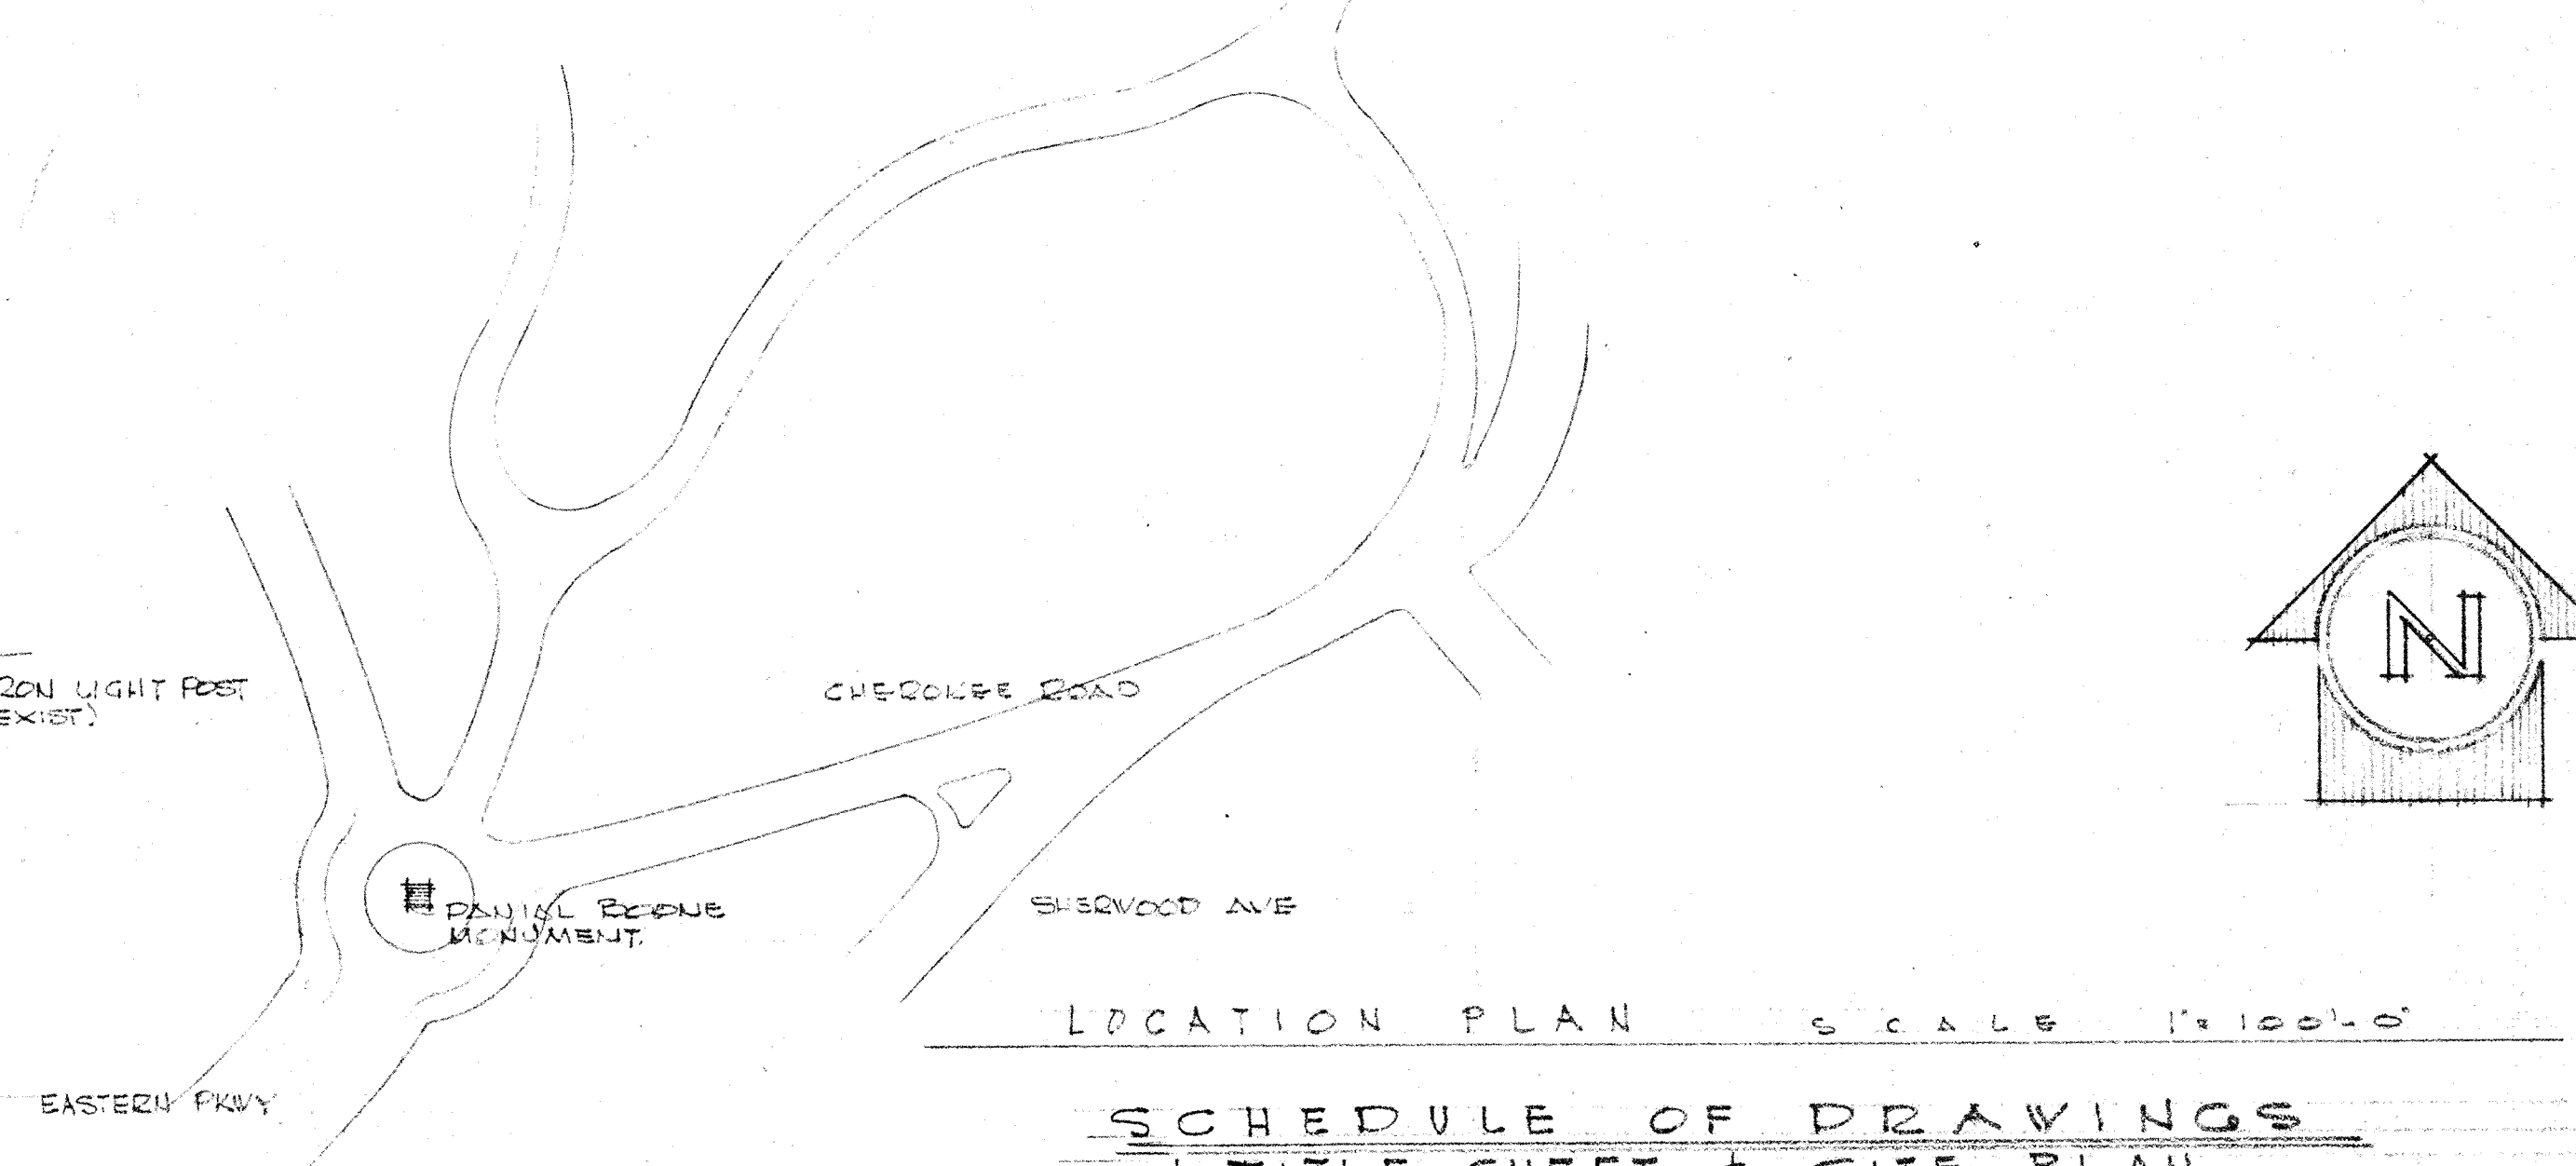


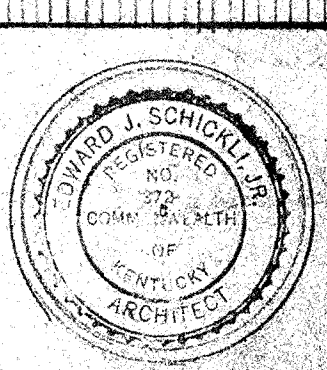

SCHEDULE OF DRAWINGS

1. TITLE SHEET & SITE PLAN
2. FOUNDATION PLAN & DETAILS
3. FLOOR PLAN AND DETAILS
4. ROOF FRAMING & DETAILS
5. ELEVATION & DETAILS
6. ELEVATION & DETAILS
7. LONGITUDINAL SECTION & DETAILS
8. PLUMBING & HEATING PLAN & DETAILS
9. ELECTRICAL PLAN & DETAILS

A NEW SHELTER HOUSE & COMFORT STATION
FOR THE DEPARTMENT OF PARKS & RECREATION
CITY OF LOUISVILLE, LOUISVILLE KENTUCKY
HOGANS FOUNTAIN N CHEROKEE PARK



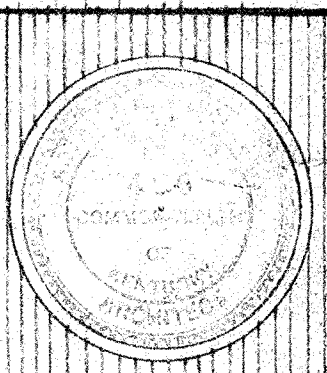


SHEET NO
1
OF 9


DATE: 2 JAN 68
DRAWN: G. N.

MEMBER OF THE
AMERICAN INSTITUTE OF ARCHIVES

**TAFEL &
SCHICKLI**
ARCHITECTS
& ENGINEER
310 WEST LIBERTY
LOUISVILLE 2, KY.

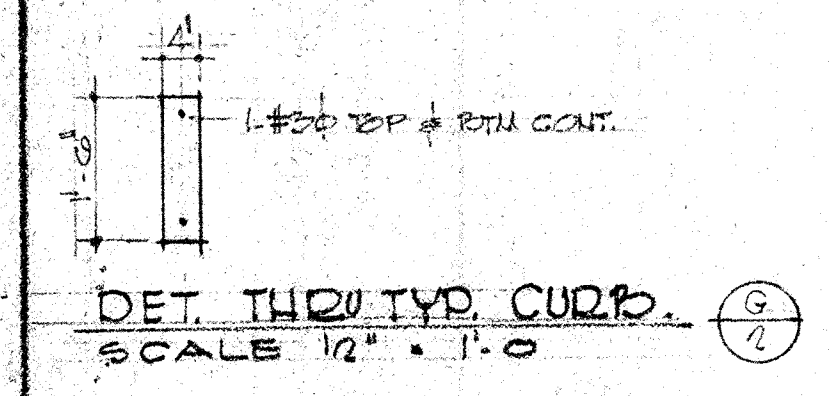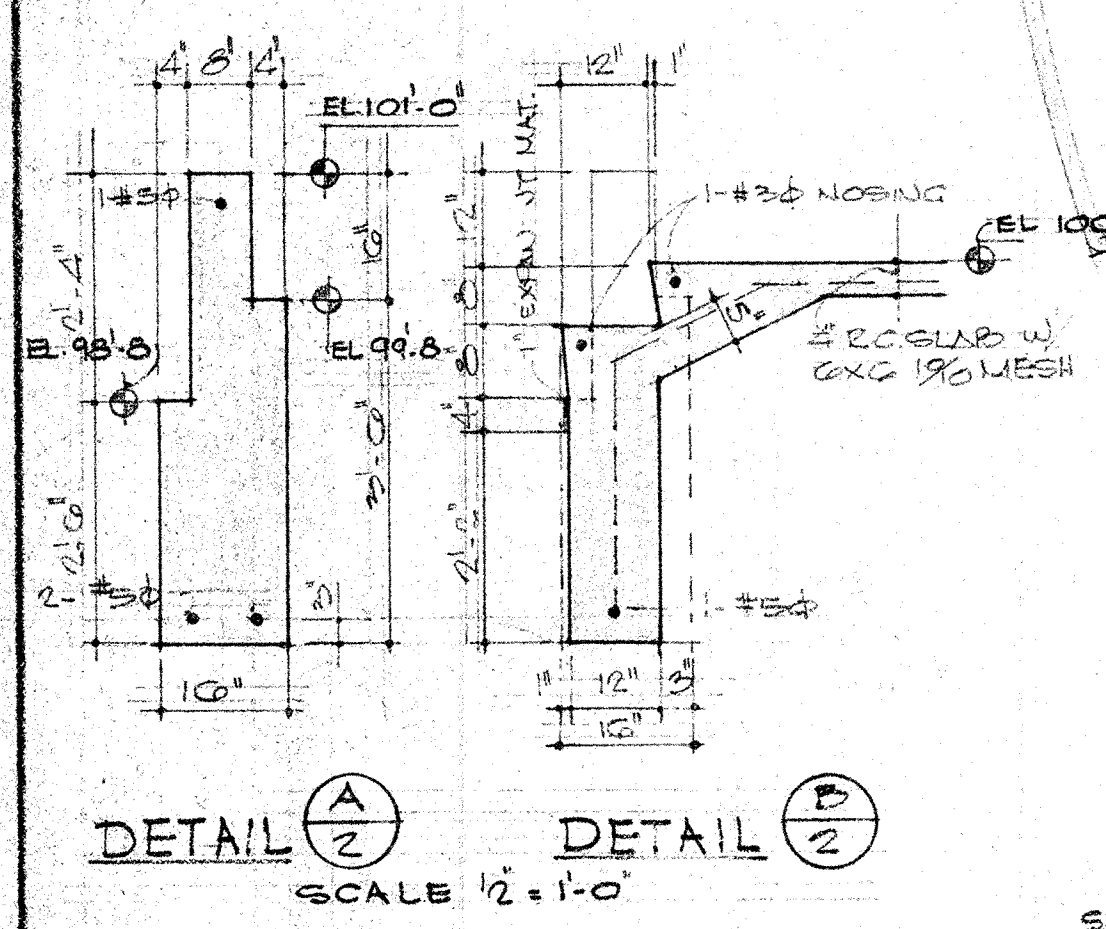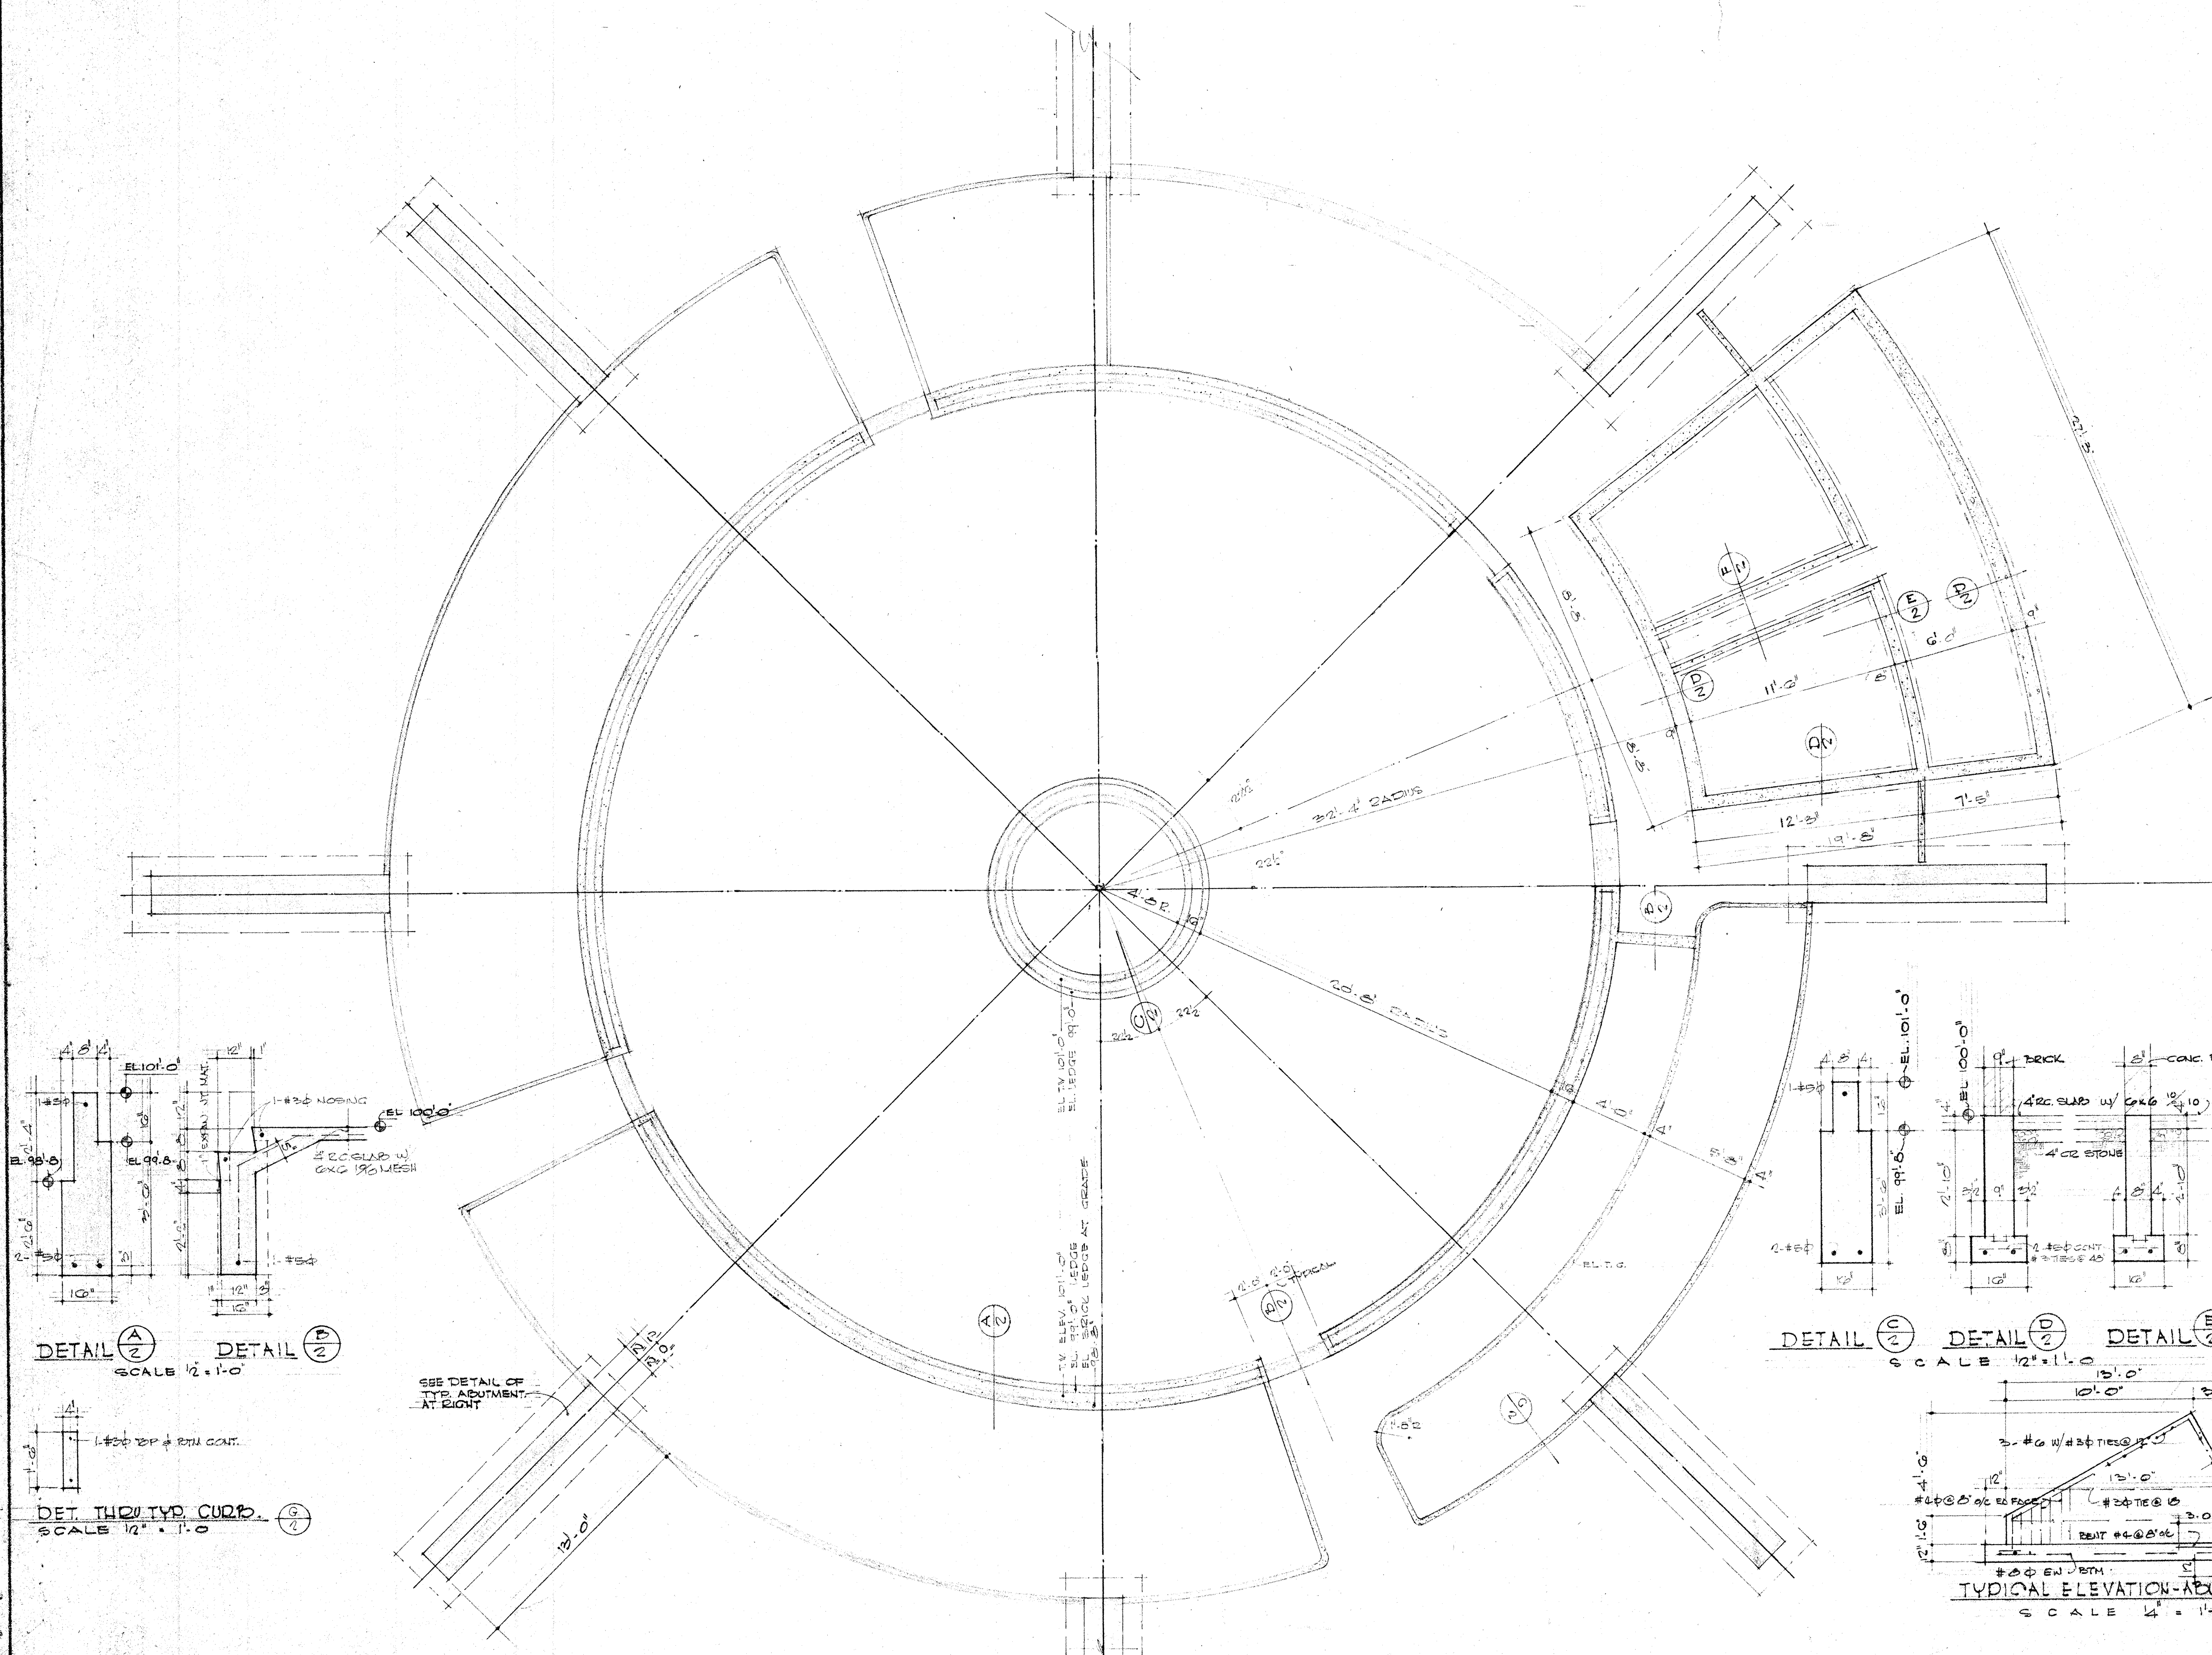


SEE DETAIL OF
TYP. ABUTMENT
AT RIGHT

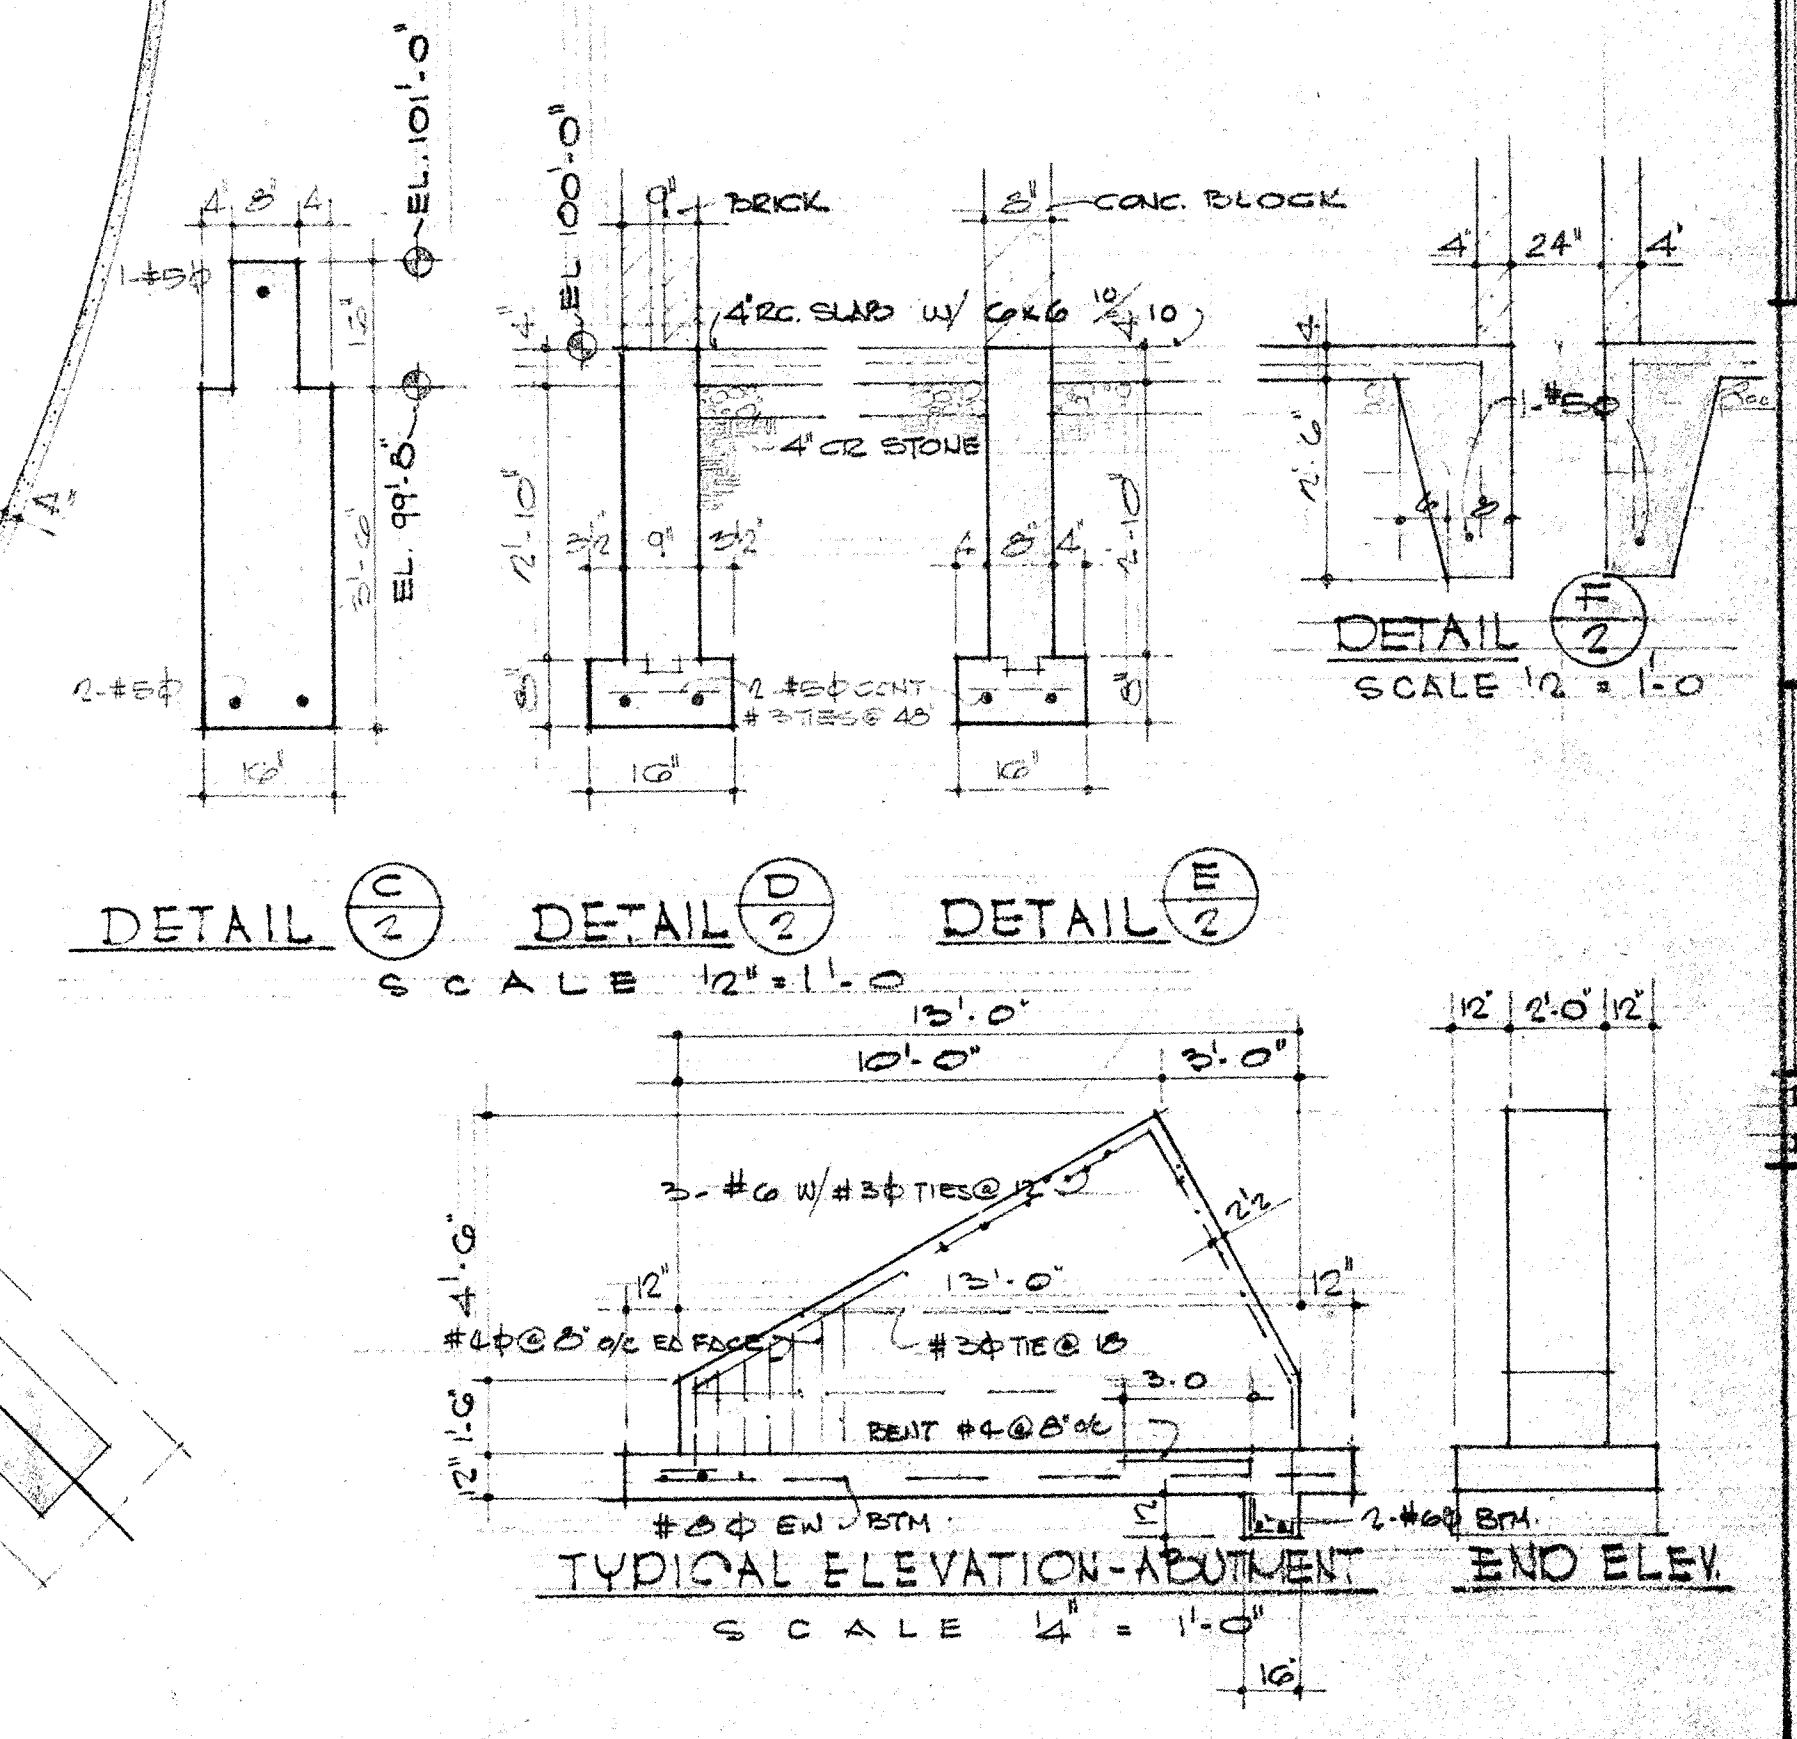


A NEW SHELTER HOUSE + COMFORT STATION
FOR THE DEPARTMENT OF PARKS + RECREATION
CITY OF LOUISVILLE, LOUISVILLE, KENTUCKY
HOGANS FOUNTAIN IN CHEROKEE PARK

DATE: 7/10/19
DRAWN: G.N.

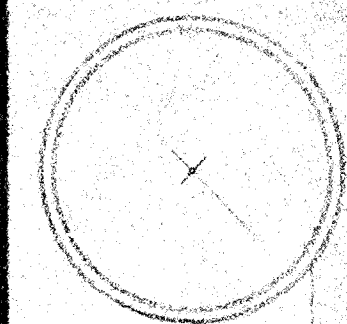

A NEW SHELTER HOUSE & COMFORT STATION
FOR THE DEPARTMENT OF PARKS & RECREATION
CITY OF LOUISVILLE, LOUISVILLE, KENTUCKY
HOGANS FOUNTAIN IN CHEROKEE PARK

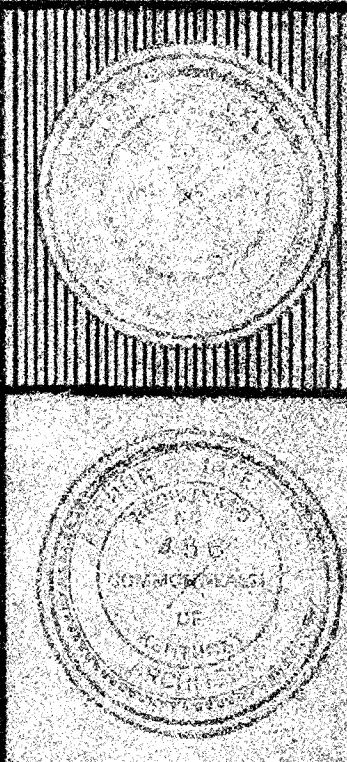



SHEET NO.
3
OF 9

DATE: 2-1-21
DUG: NEWTON


OWNER OF THE PROJECT
T. A. SCHICKEL
ARCHITECT
& ENGINEER
310 WEST LIBERTY
LOUISVILLE 2, KY

(B) ELEVATION


(A) ELEVATION

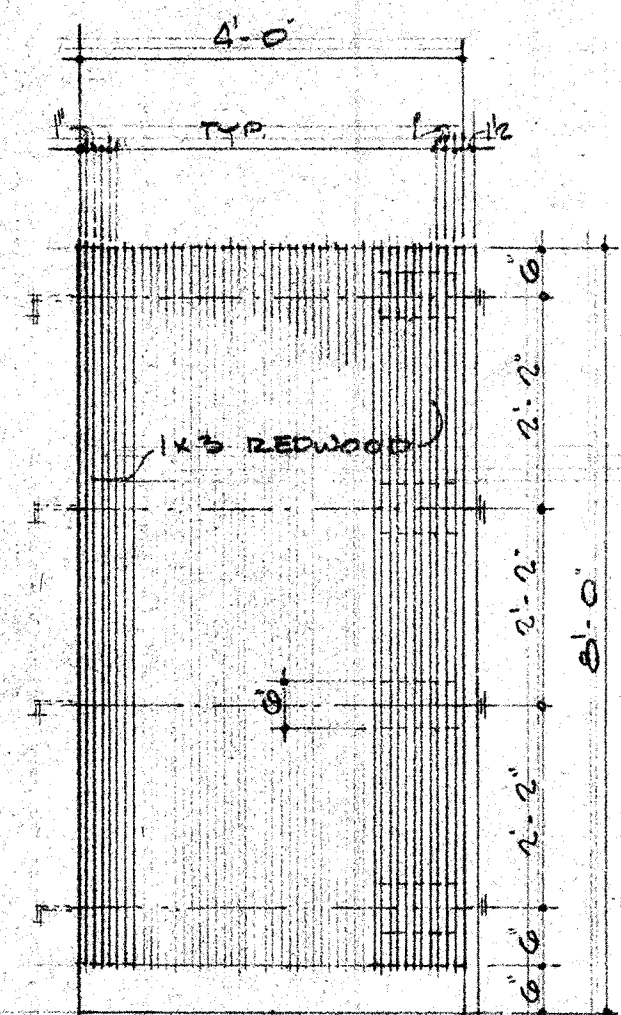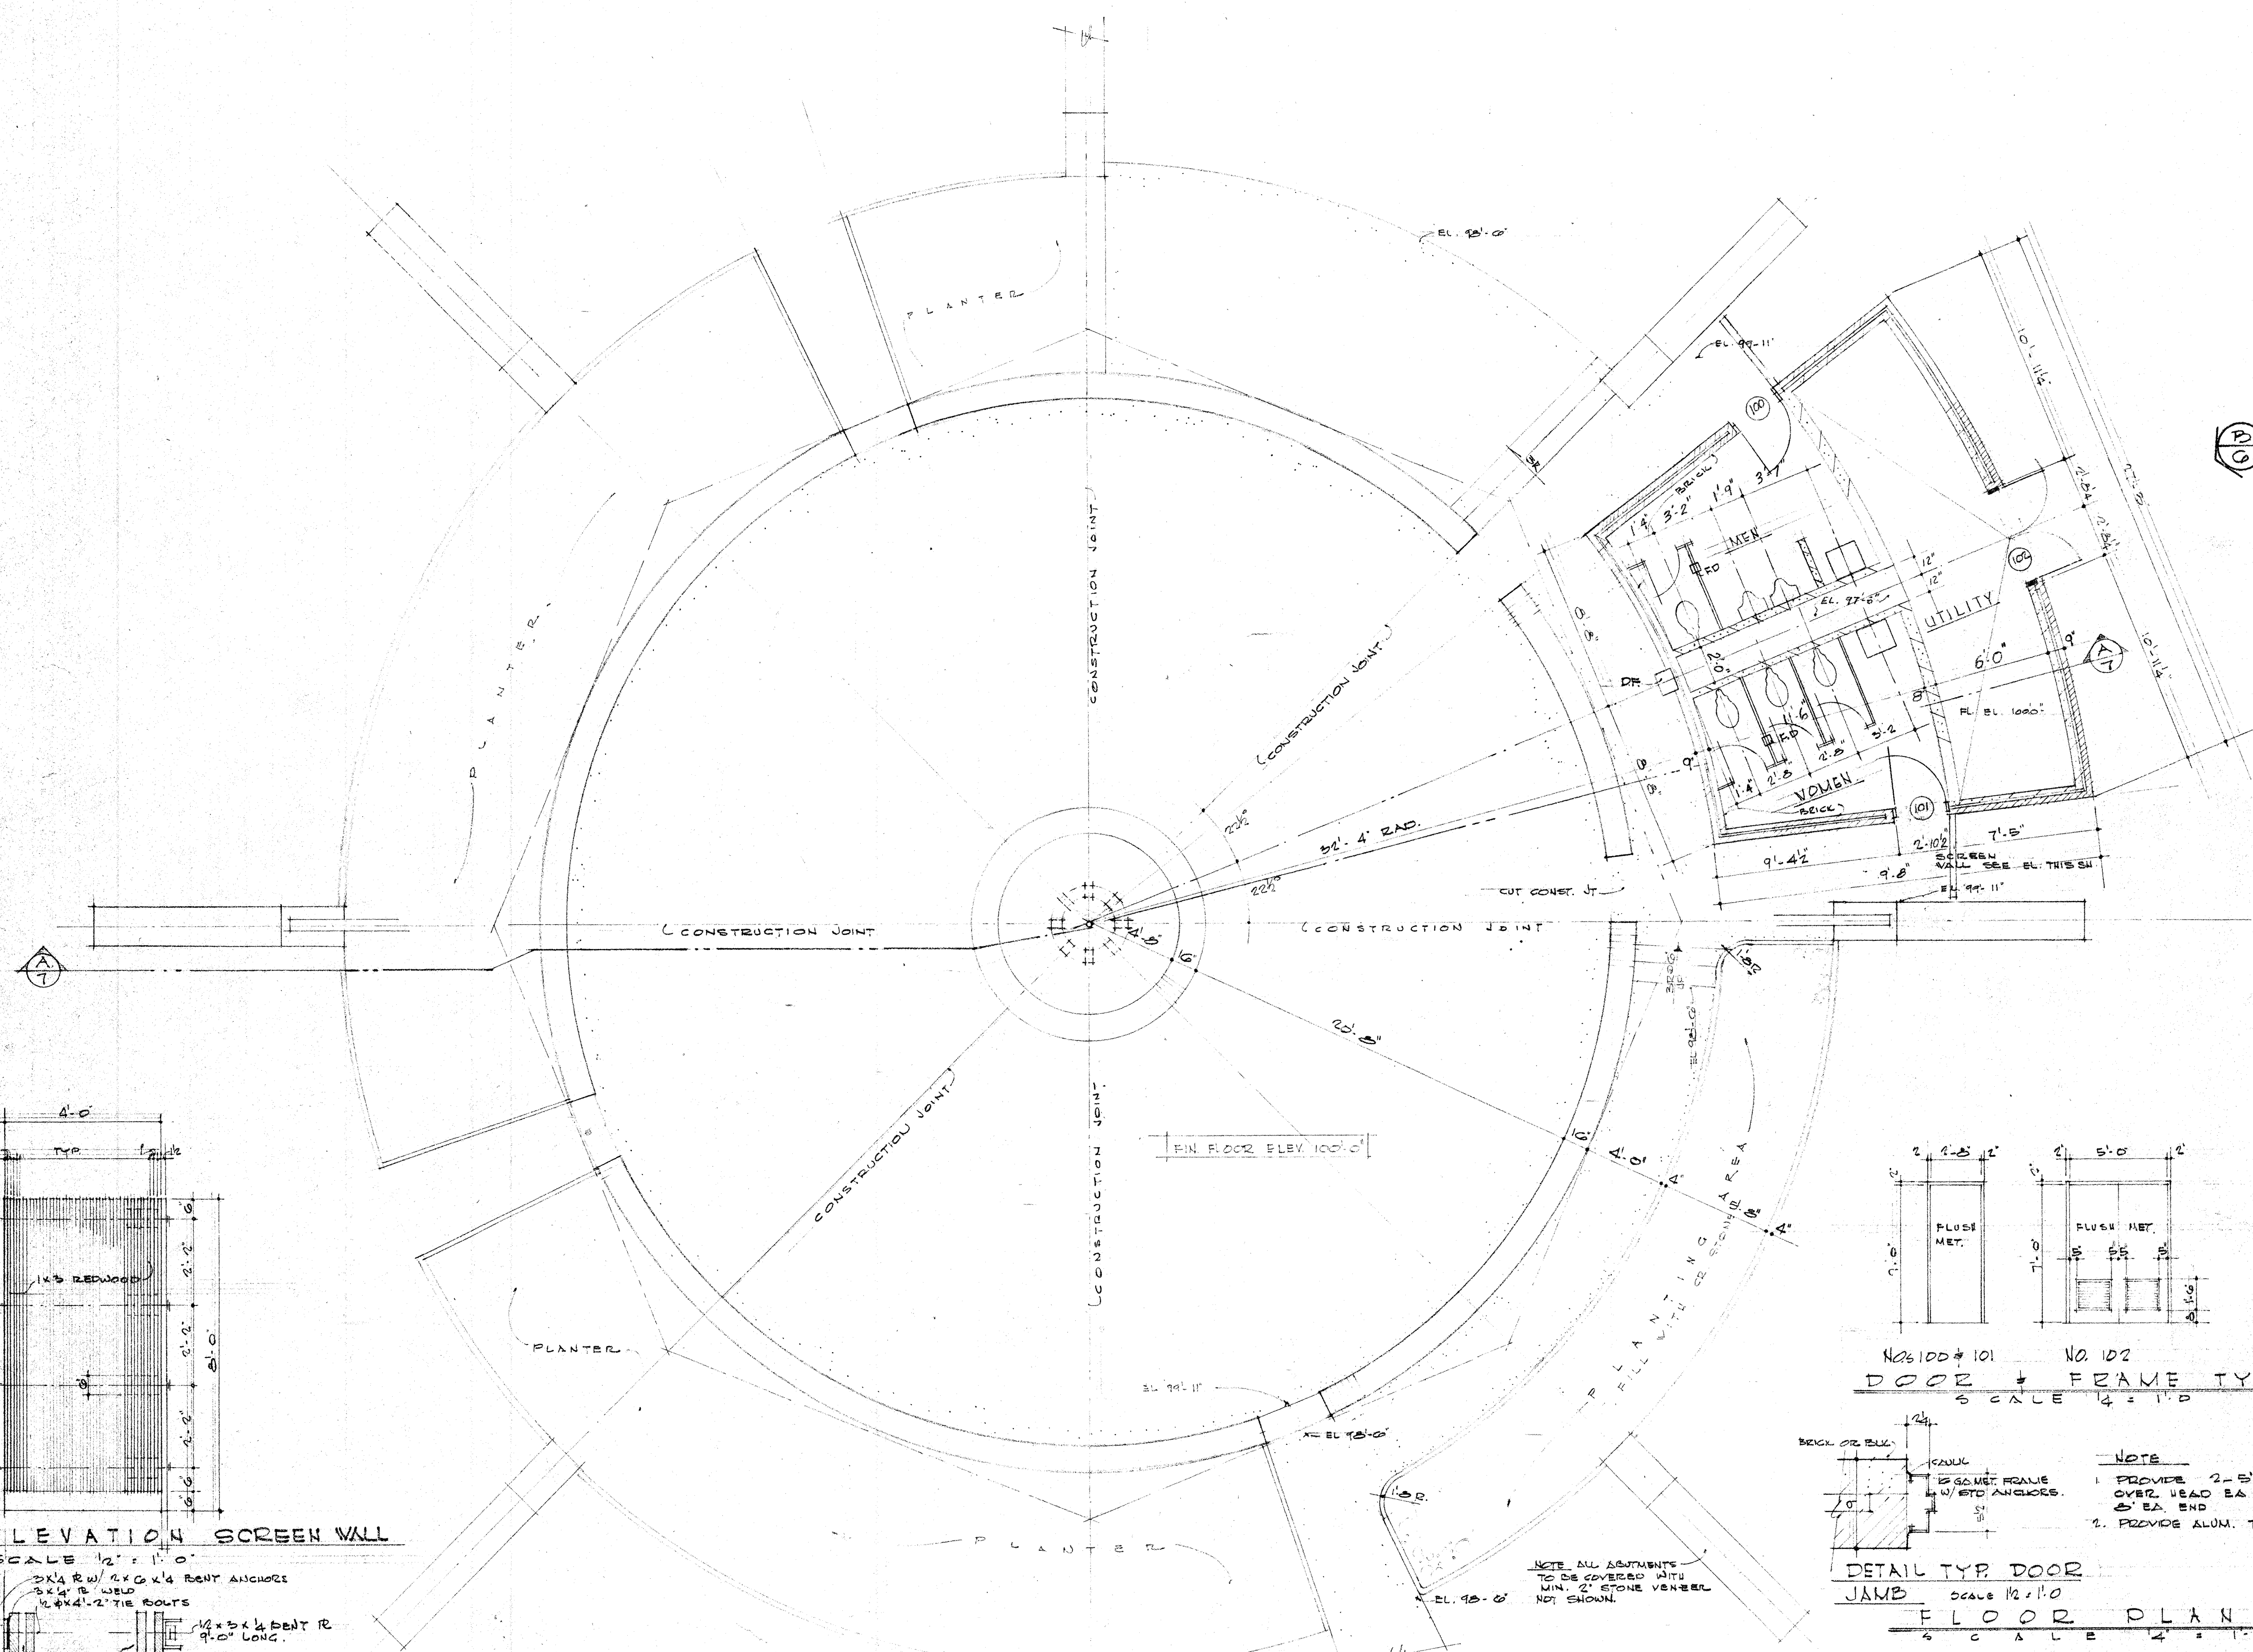

ELEVATION SCREEN WALL
SCALE 1/2" = 1'-0"
2x4 RW/2x6x4 BENT ANCHORS
2x4 RW WELD
1/2" x 4x4 TIE BOLTS
1/2" x 3x4 BENT R
9'-0" LONG
1x3 REDWOOD 7'-0" LONG
1x5 SPACERS 6" LONG
PLAN SCREEN WALL SCALE 1/2" = 1'-0"

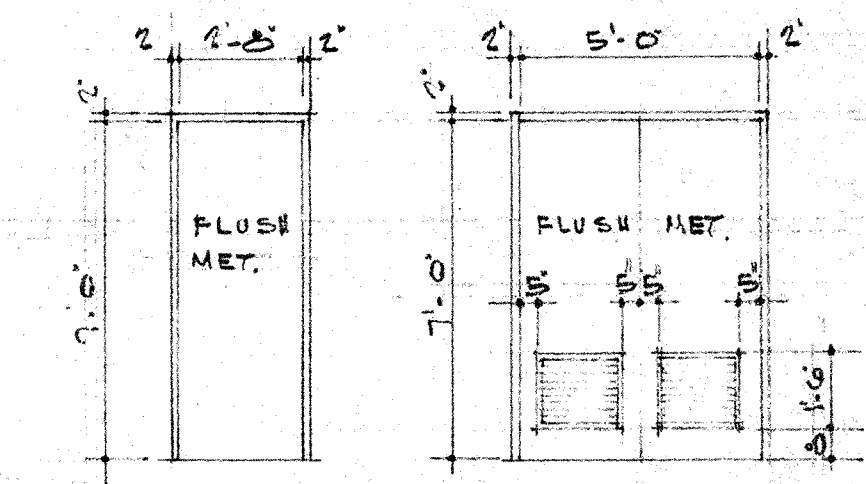


NO. 100 & 101 NO. 102
DOOR & FRAME TYPES
SCALE 1/4" = 1'-0"

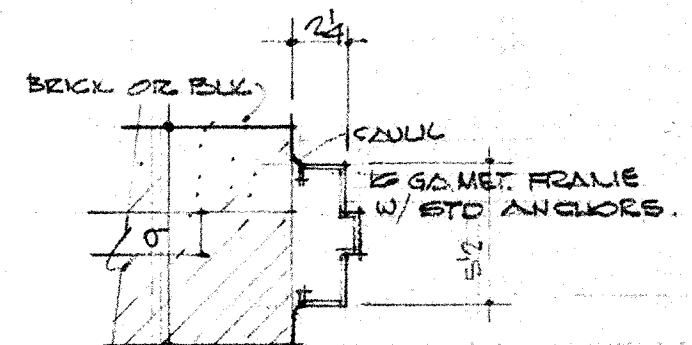


DETAIL TYP. DOOR
JAMB SCALE 1/2" = 1'-0"
FLOOR PLAN
SCALE 1/4" = 1'-0"

- NOTE
1. PROVIDE 2-5' x 3/2 x 5/16 C'S OVER HEAD EA. DOOR. MIN BRG 5' EA. END
 2. PROVIDE ALUM. THRESH @ EA. DOOR


NOTE ALL DIMENSIONS TO BE COVERED WITH MIN. 2" STONE VENEER NOT SHOWN.

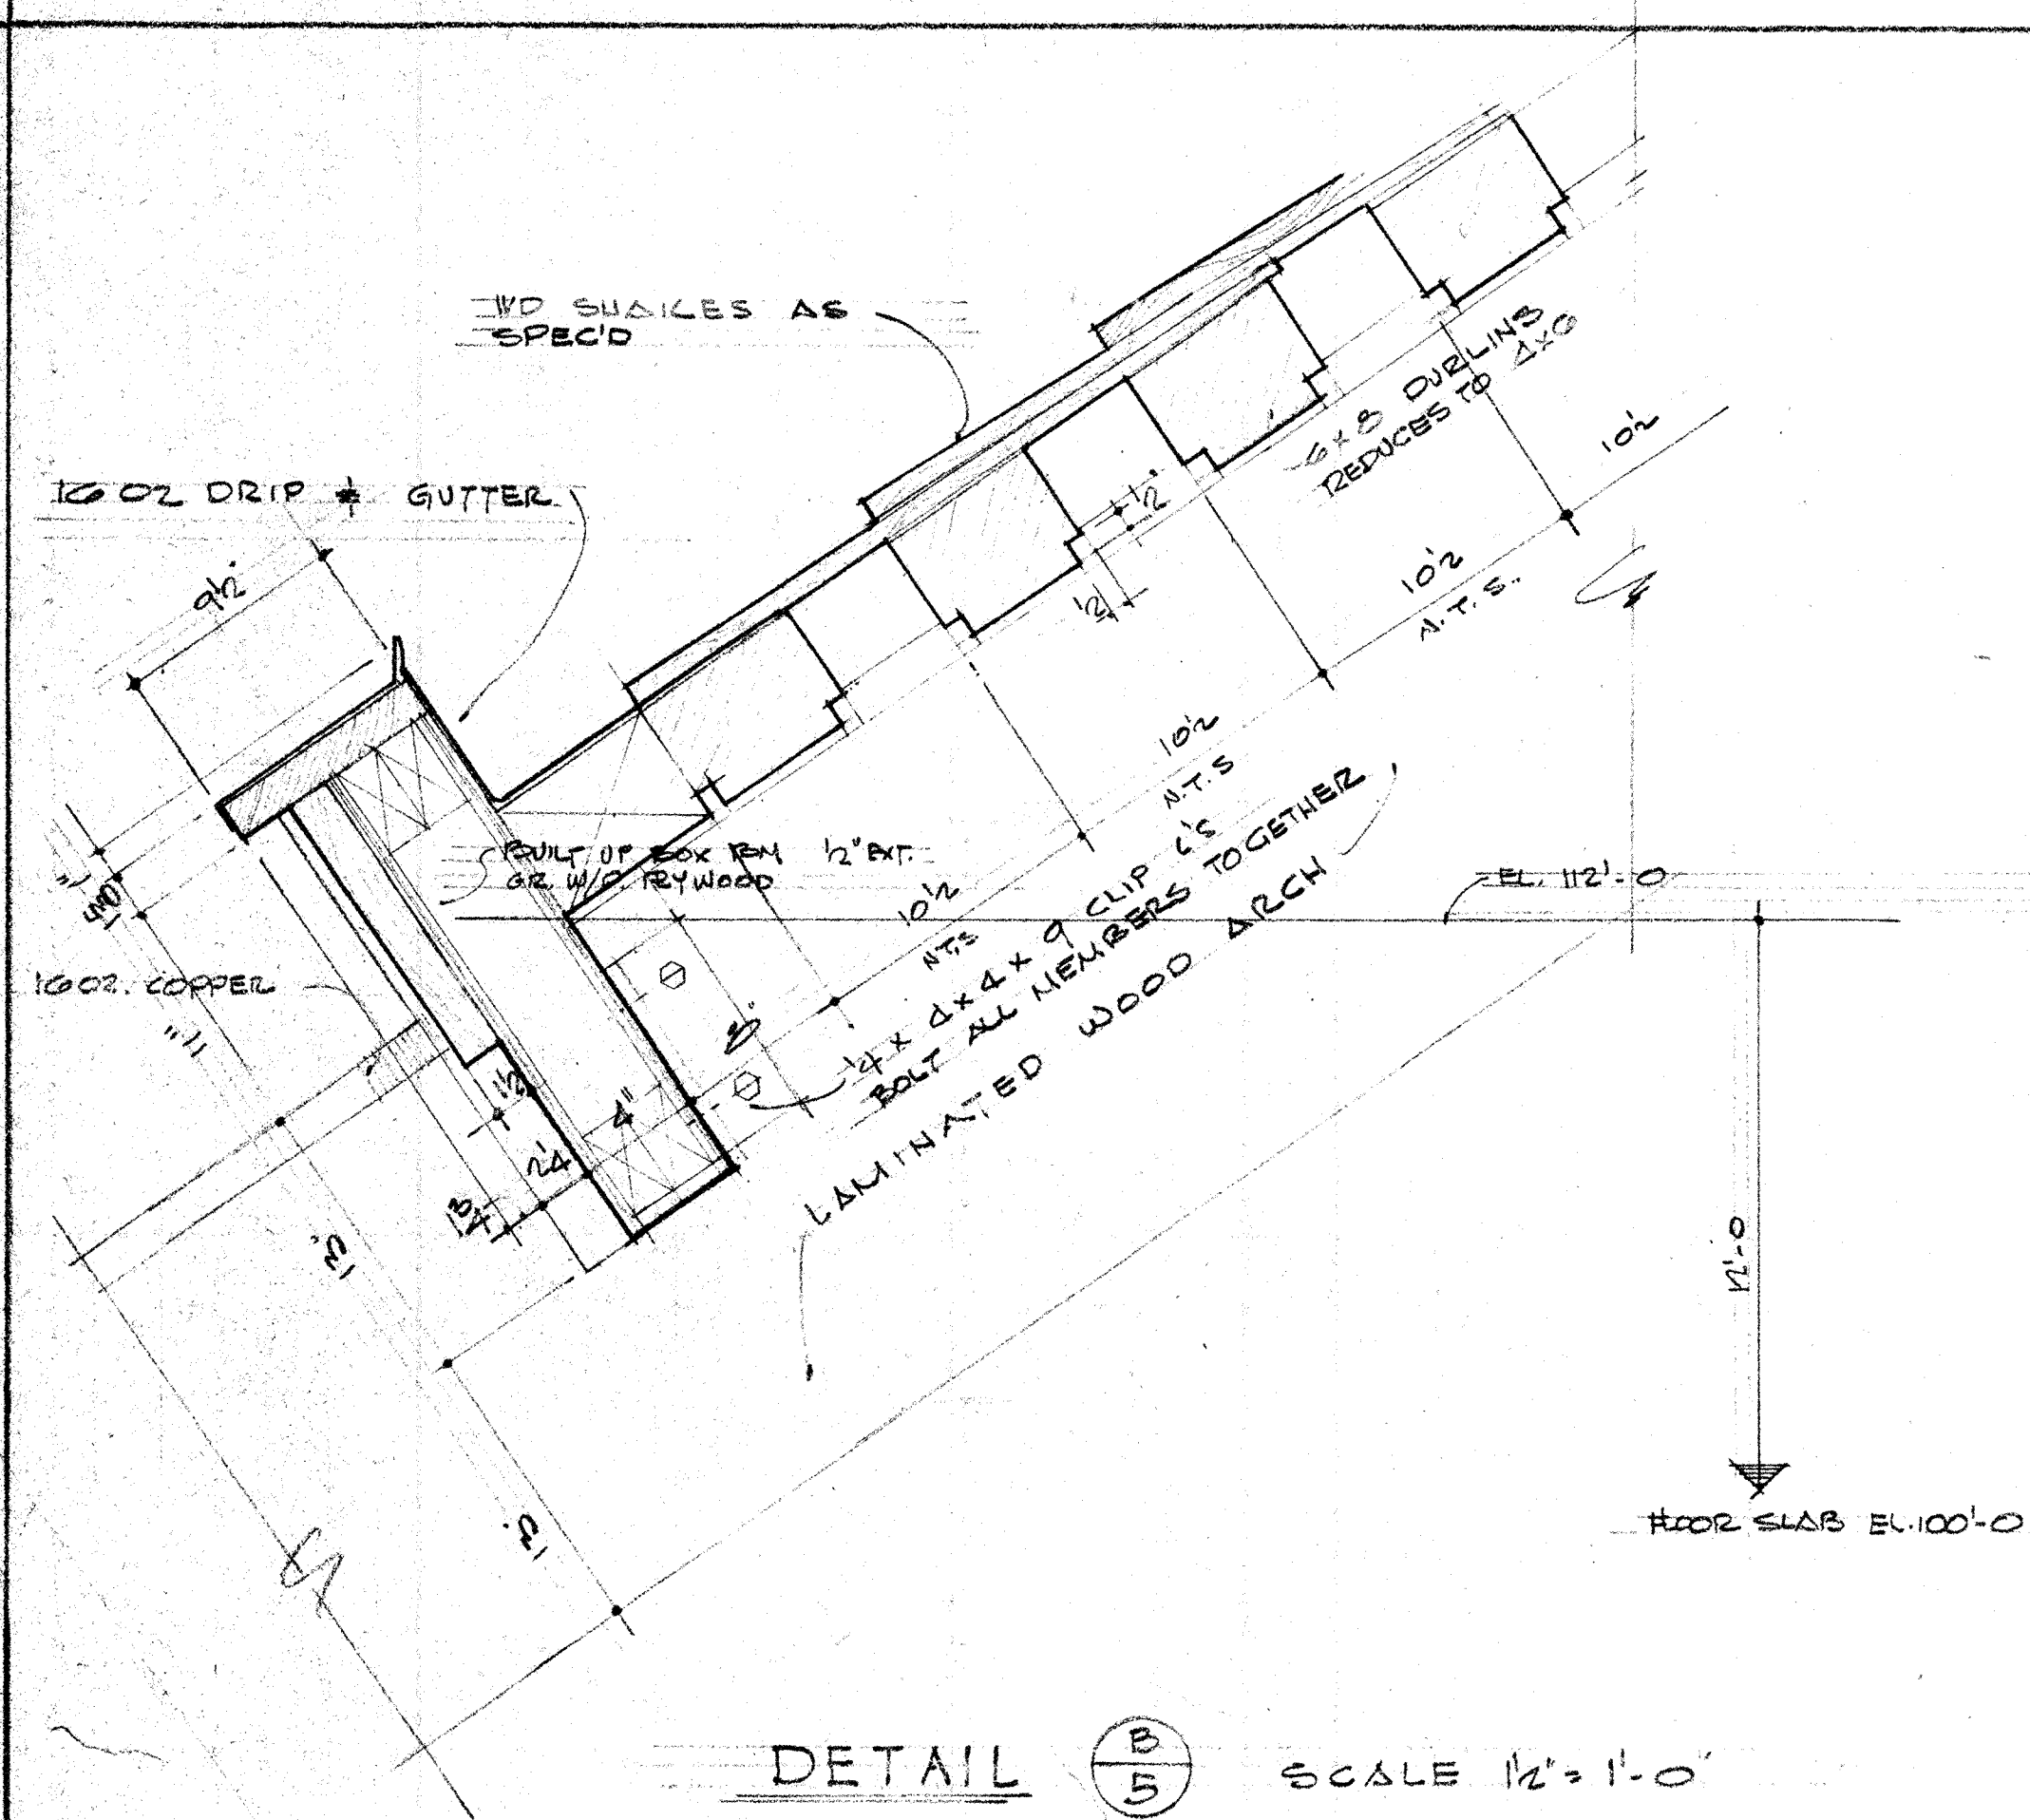

DETAIL $\frac{B}{5}$ SCALE $\frac{1}{2} = 1'-0"$

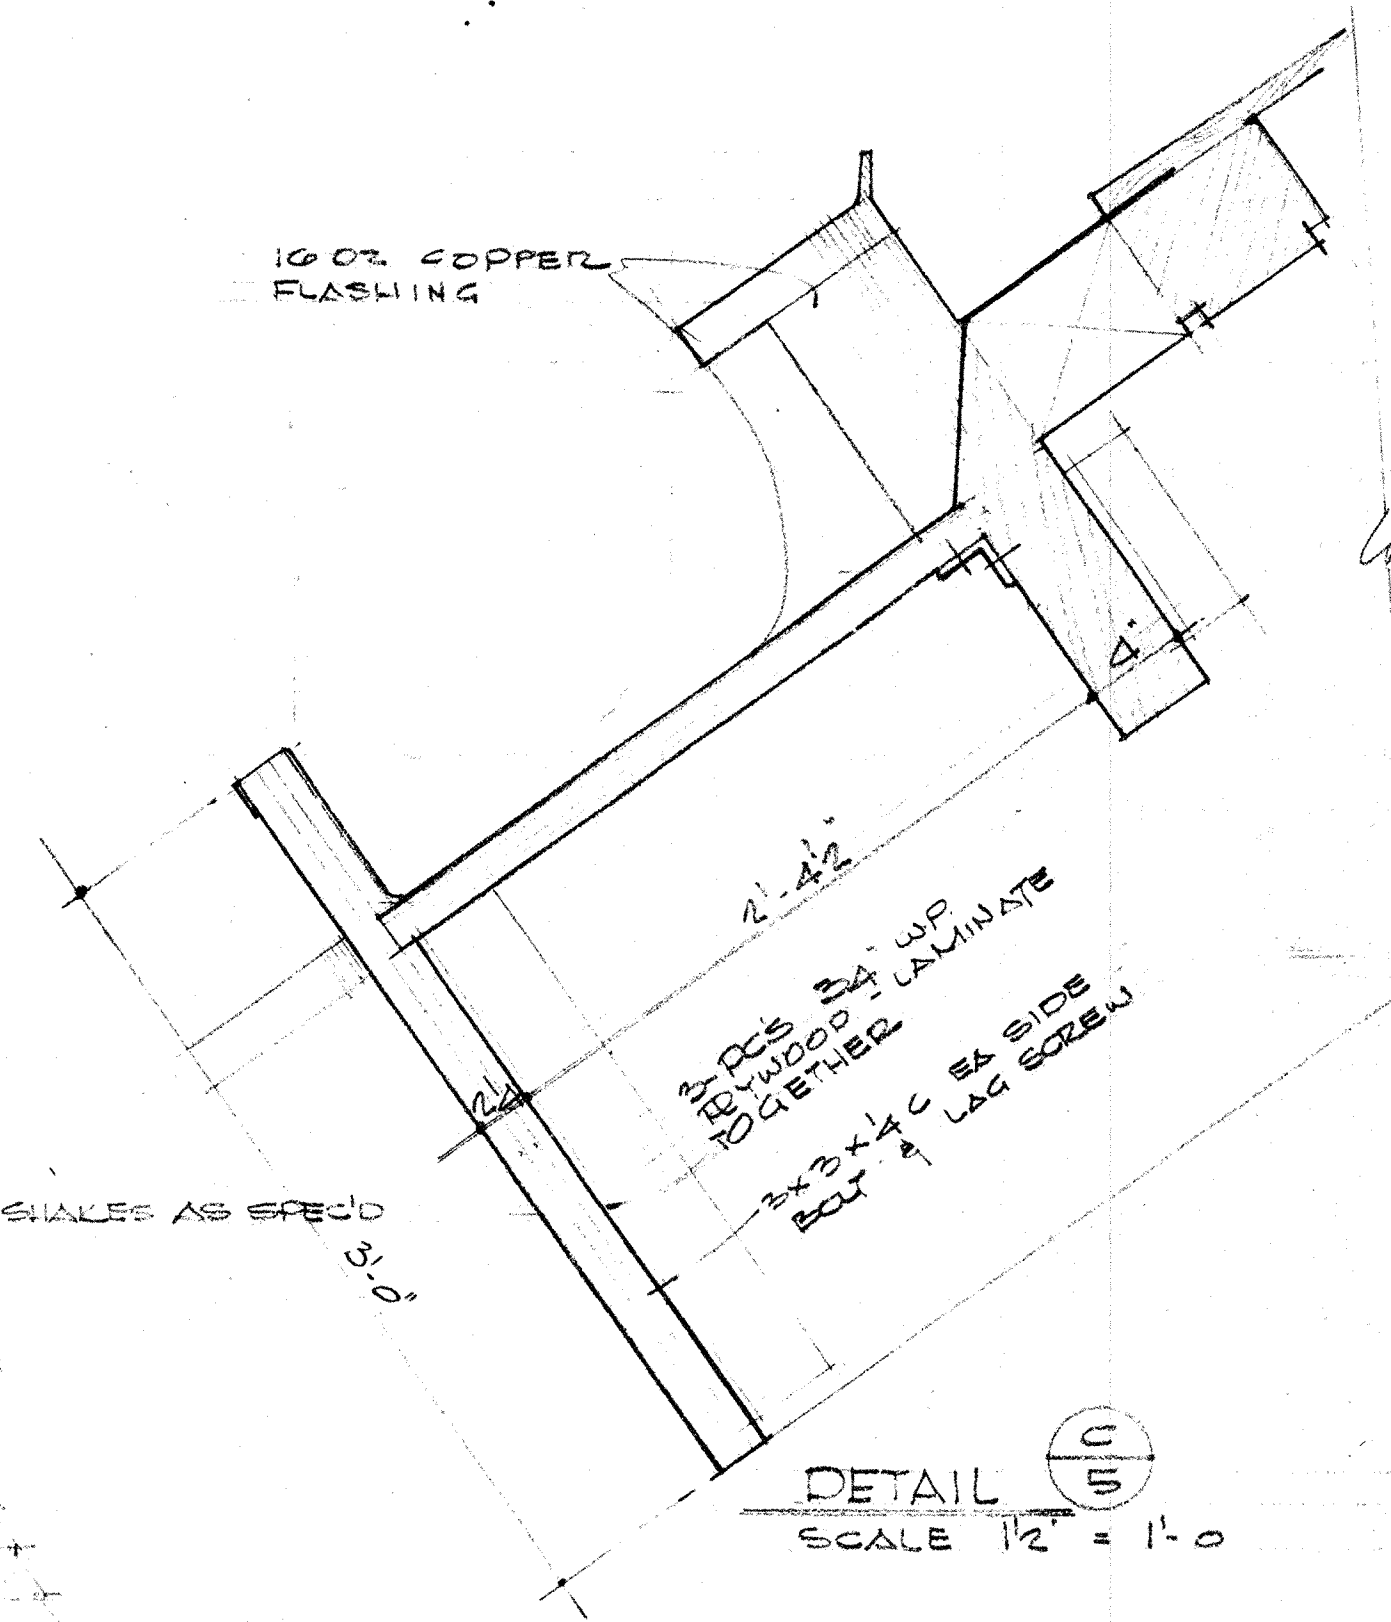


DETAIL $\frac{C}{5}$ SCALE $\frac{1}{2} = 1'-0"$

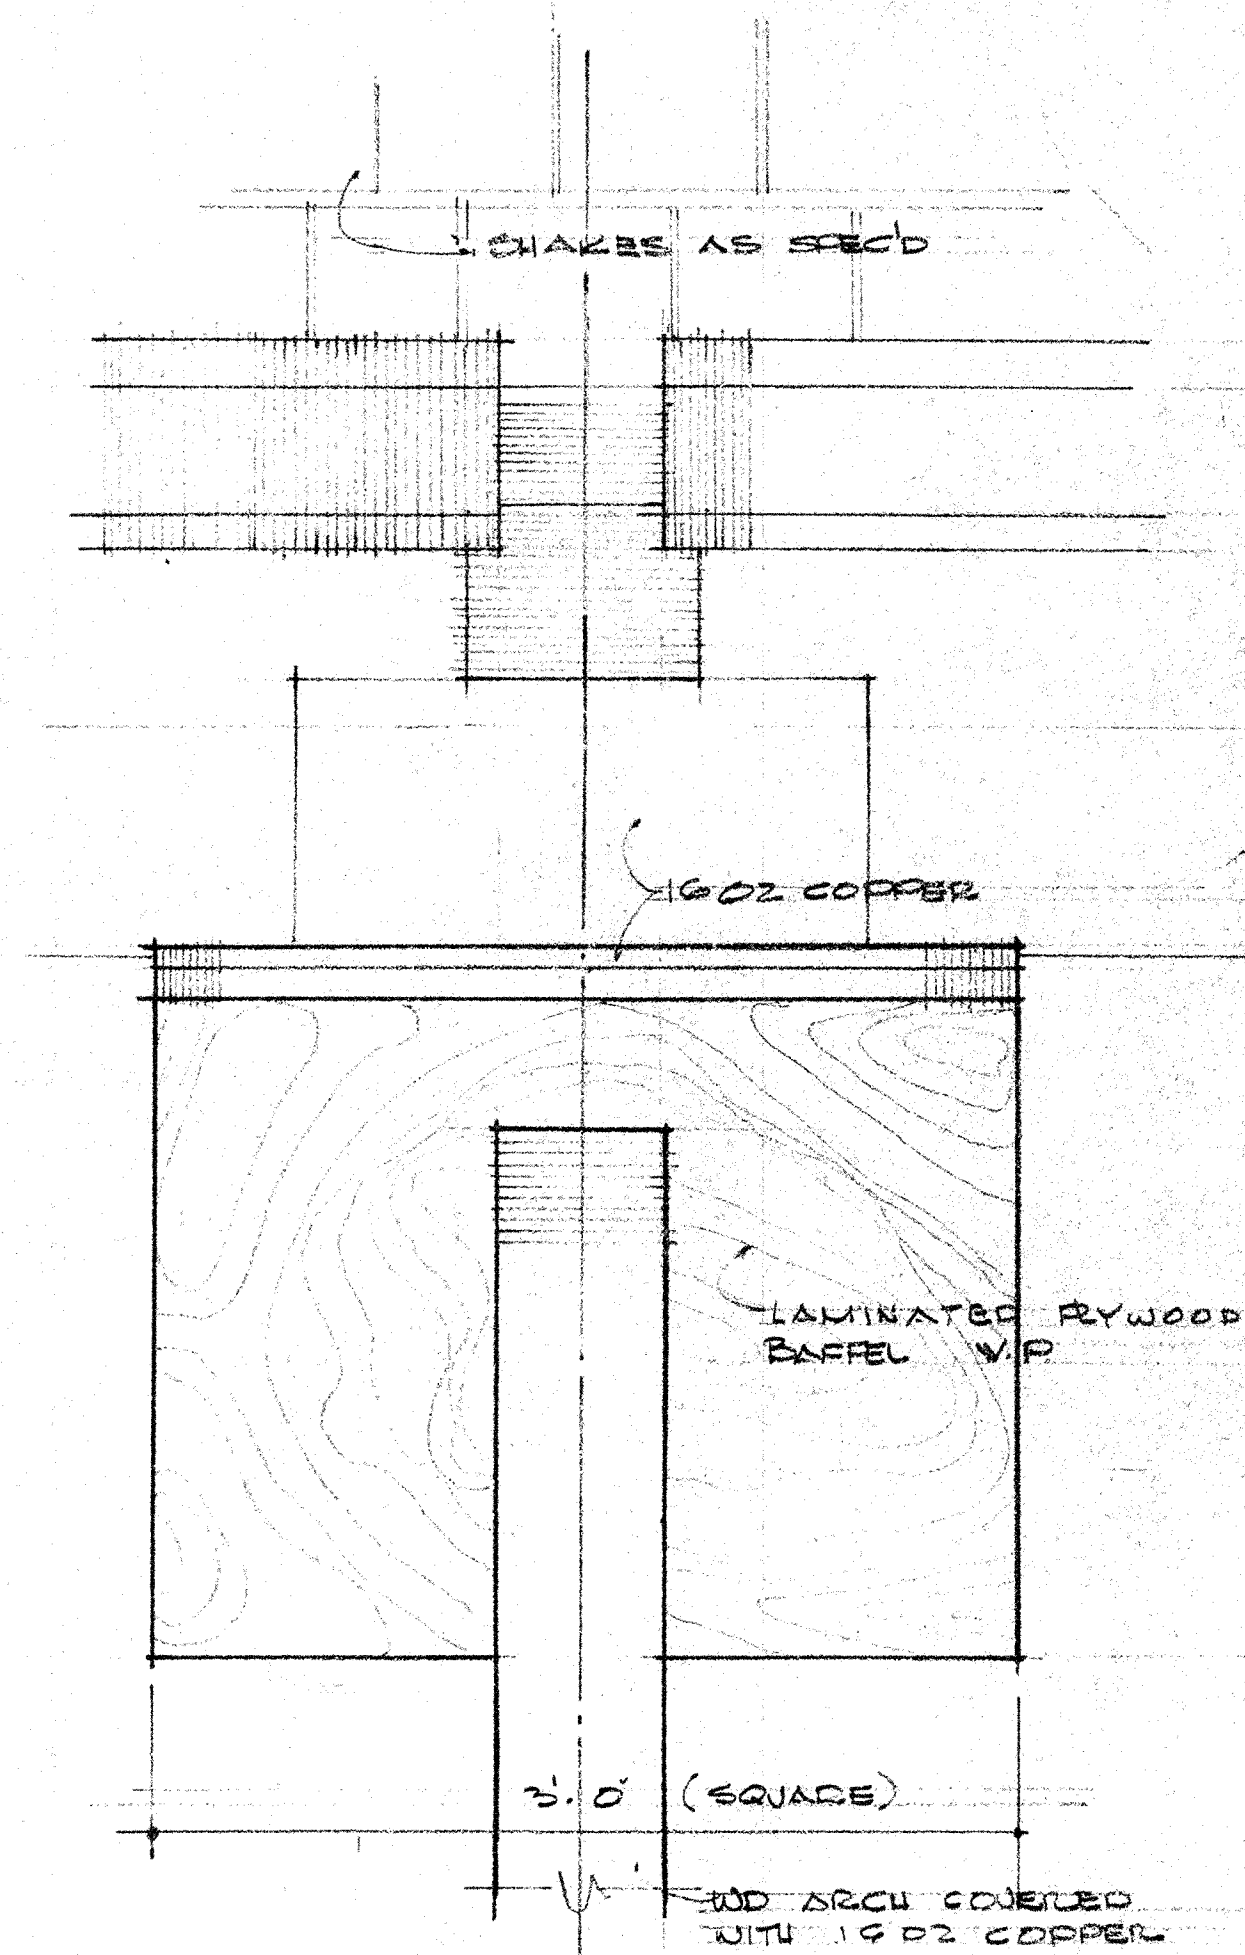

DETAIL $\frac{D}{5}$ SCALE $\frac{1}{2} = 1'-0"$


NOTE: TYPICAL ARCHITECT COVERED WITH 2" MIN. STONE VENEER

EL. 105'-2" & 105'-0"

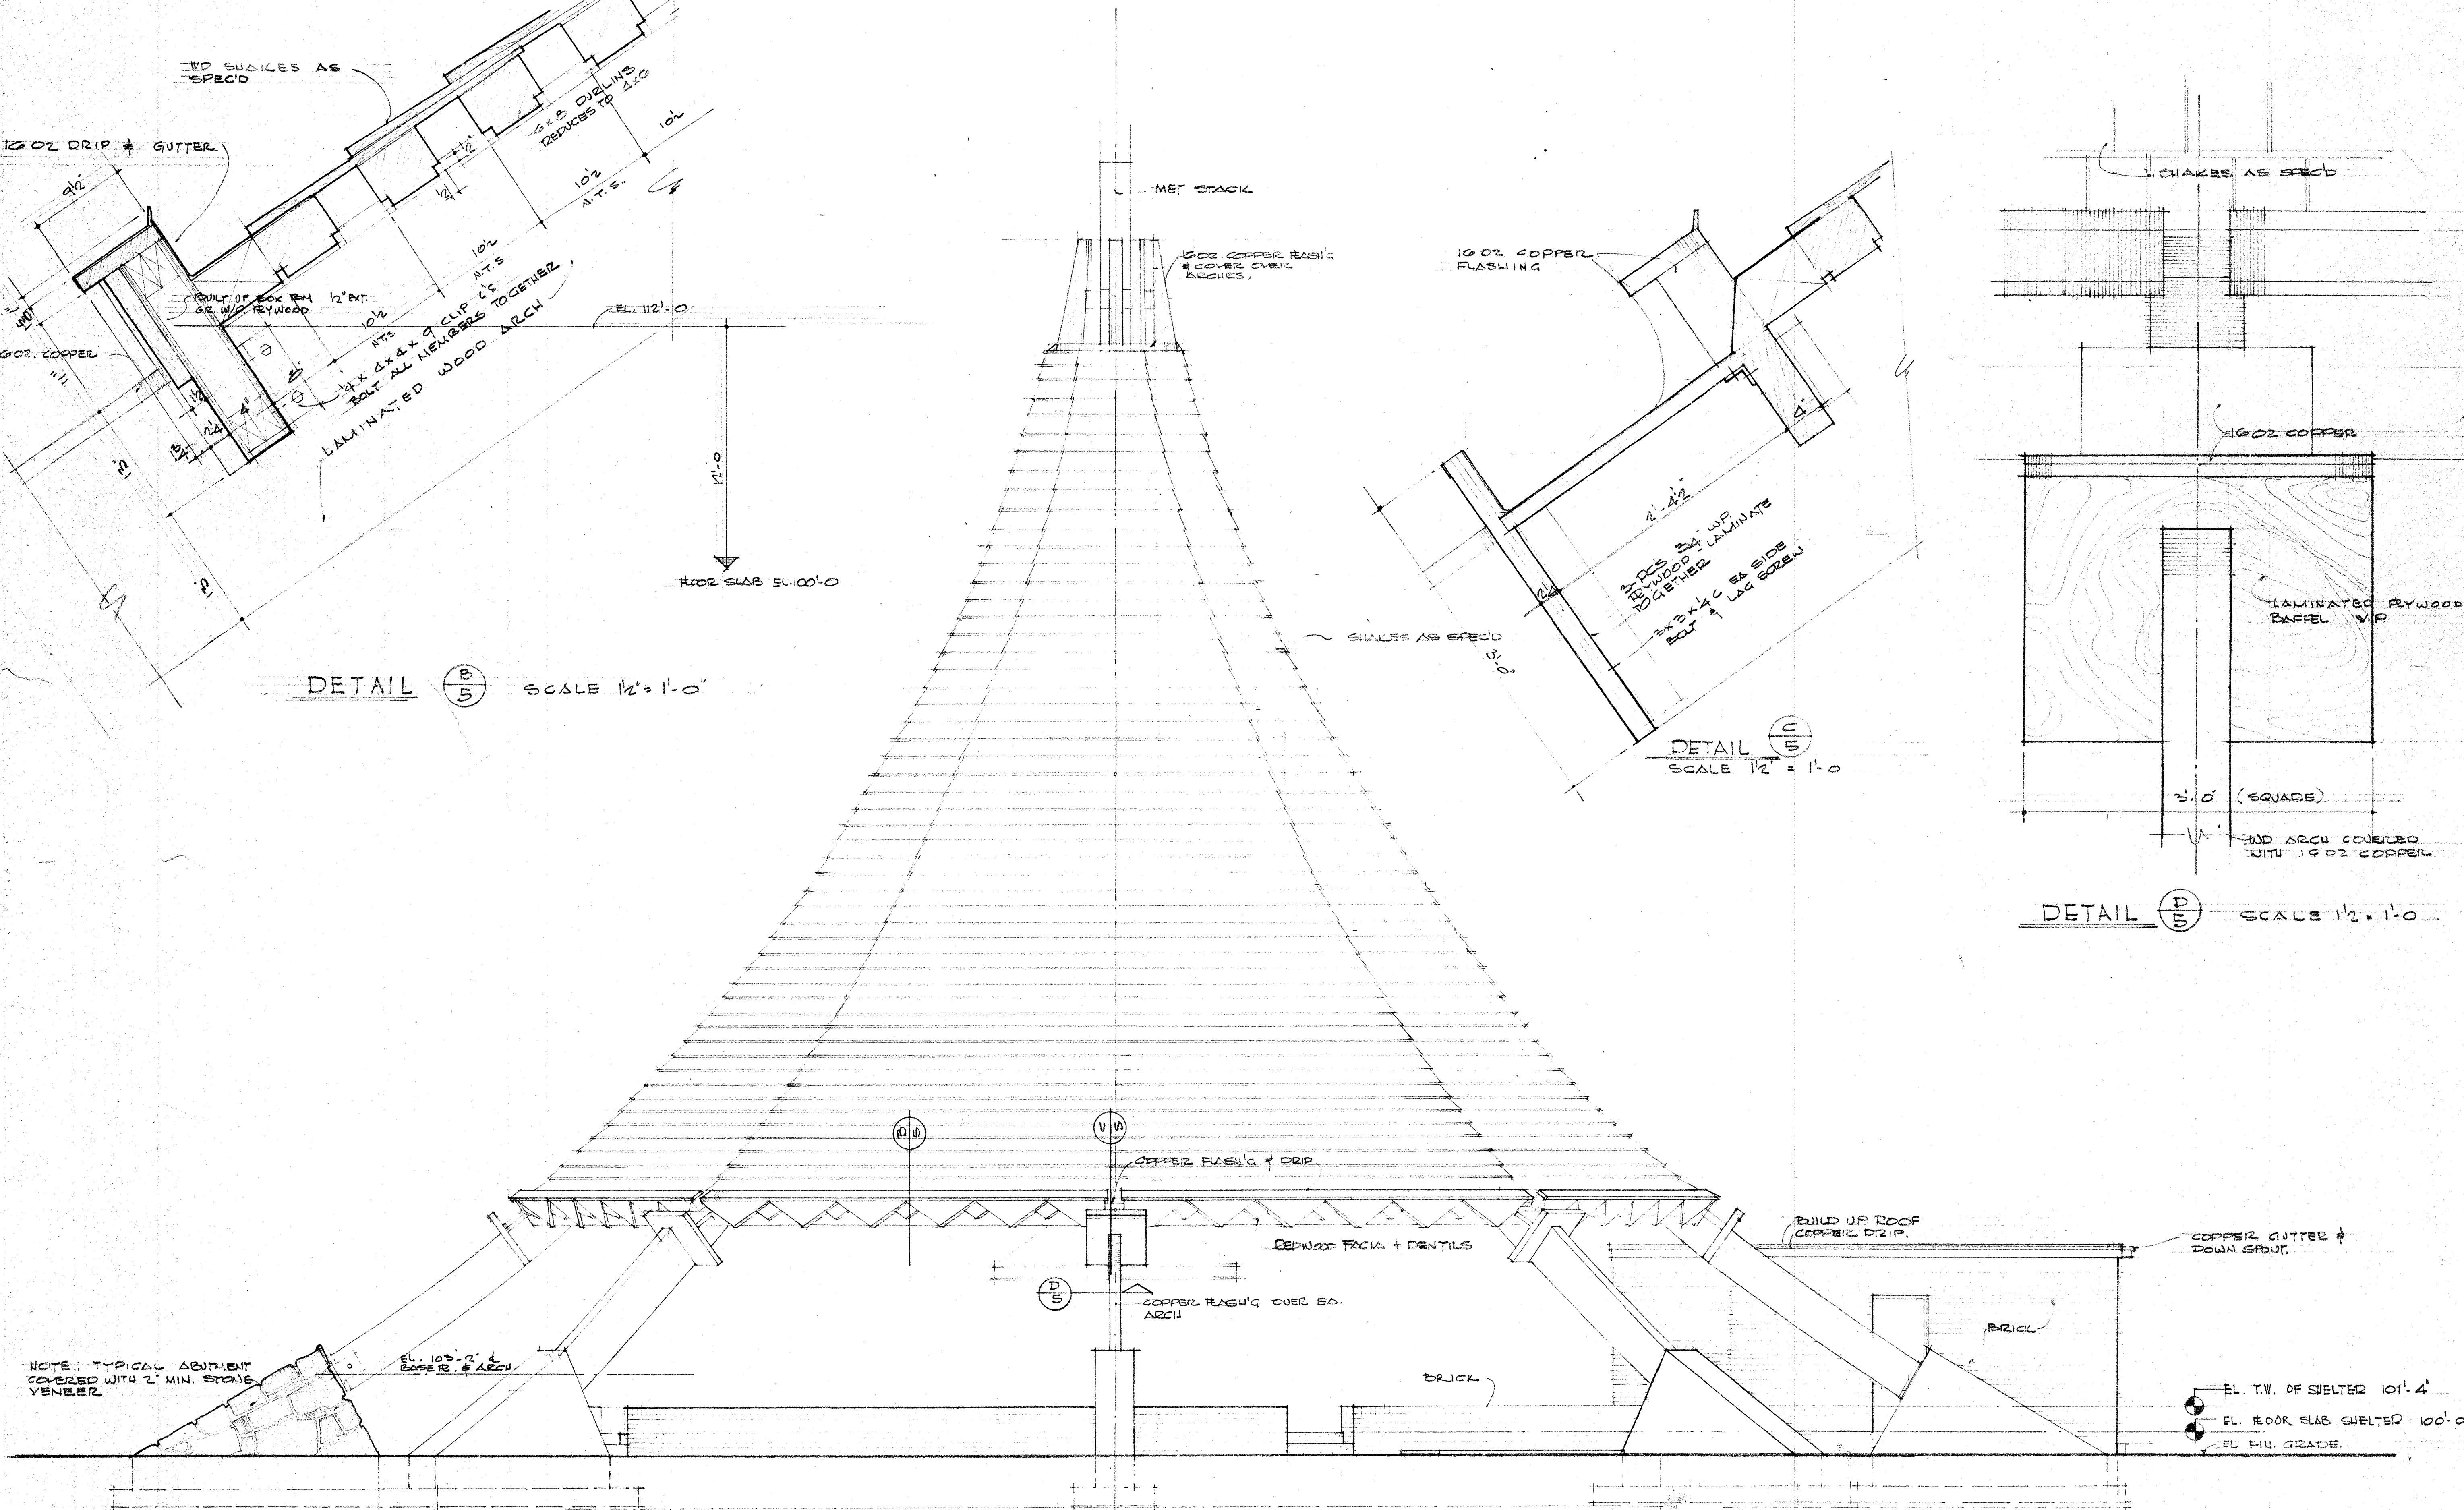

ELEVATION A/5
SCALE $\frac{1}{4} = 1'-0"$

A NEW SHELTER HOUSE & COMFORT STATION
FOR THE DEPARTMENT OF PARKS & RECREATION
CITY OF LOUISVILLE LOUISVILLE KENTUCKY
HOGAN'S FOUNTAIN IN CHEROKEE PARK

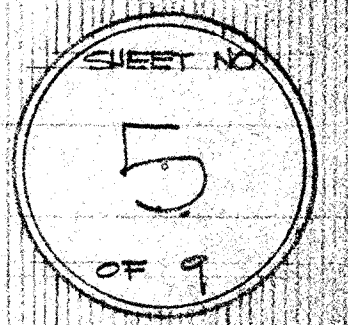

DATE 2 JAN. 68
DWG. G.N.

TAYLOR & SCHICKLI
ARCHITECTS
& ENGINEERS
310 WEST LIBERTY
LOUISVILLE 2, KY.

PANEL "A" SCHEDULE					
CIRC. NO.	WATTS OR FLA	BRKR SIZE	WIRE SIZE	POLES	EQUIPMENT SERVED
1	200W	20A	#12	1	LIGHTING
2	600W	20A	#12	1	LIGHTING
3	600W	20A	#12	1	LIGHTING
4	17A	30A	#10	2	ELEC. HEATER
5	17A	30A	#10	2	ELEC. HEATER
6					
7					
8	750W	30A	#10	2	ELEC. HEATER
9	400W	20A	#12	1	LIGHTING
10					
11		20A	#12	1	RECPT (2)
12		20A			SPARE
13		20A			SPARE
14		20A			SPARE
15#16		20A			SPARE

WESTINGHOUSE NLAB-16 SURFACE MOUNT
115/230 VOLTS, 1 ϕ , 3 WIRE, 200 A. BUSS &
125 A. MAIN BREAKER

FIXTURE SCHEDULE	
A	STONCO CLD-1500 ADJUSTABLE SOCKET ON 2-B BASE 150 WATT PAR-38 SPOT OR FLOOD AS DETERMINED ON JOB. PROVIDE WITH B-1550 WIRE GUARD, MOUNT 22" O AFF.
B	GUTH B-1334/TP RECESSED NIGHT LIGHT IN EXTERIOR WALL 8" O" AFF WITH TAMPER PROOF SCREWS, 100 WATT IF LAMP.
C	L & P #PC-150 SURFACE MOUNT, TAMPER PROOF WITH 2- 100 WATT IF LAMPS.
D	PORCELAIN RECEPTACLE LESS CHAIN WITH 100 WATT IF LAMP.

NOTE - ALL LIGHTS TO BE SWITCHED FROM PANEL EXCEPT IN UTILITY ROOM.



A NEW SHELTER HOUSE & COMFORT STATION
FOR THE DEPARTMENT OF PARKS & RECREATION
CITY OF LOUISVILLE LOUISVILLE KENTUCKY
HOGANS FOUNTAIN IN CHEROKEE PARK

KENNETH J. ROY, P.E.
ENGINEER
304 W. LIBERTY
LOUISVILLE
KENTUCKY

SHEET NO.
8
OF 9

DATE: 2- JAN 65
DVG.

AIA
TAFEL &
SCHICKLI
ARCHITECTS
& ENGINEER
310 WEST LIBERTY
LOUISVILLE 2, KY.

