



# A NEW SHELTER HOUSE & COMFORT STATION FOR THE DEPARTMENT OF PARKS & RECREATION CITY OF LOUISVILLE LOUISVILLE, KENTUCKY

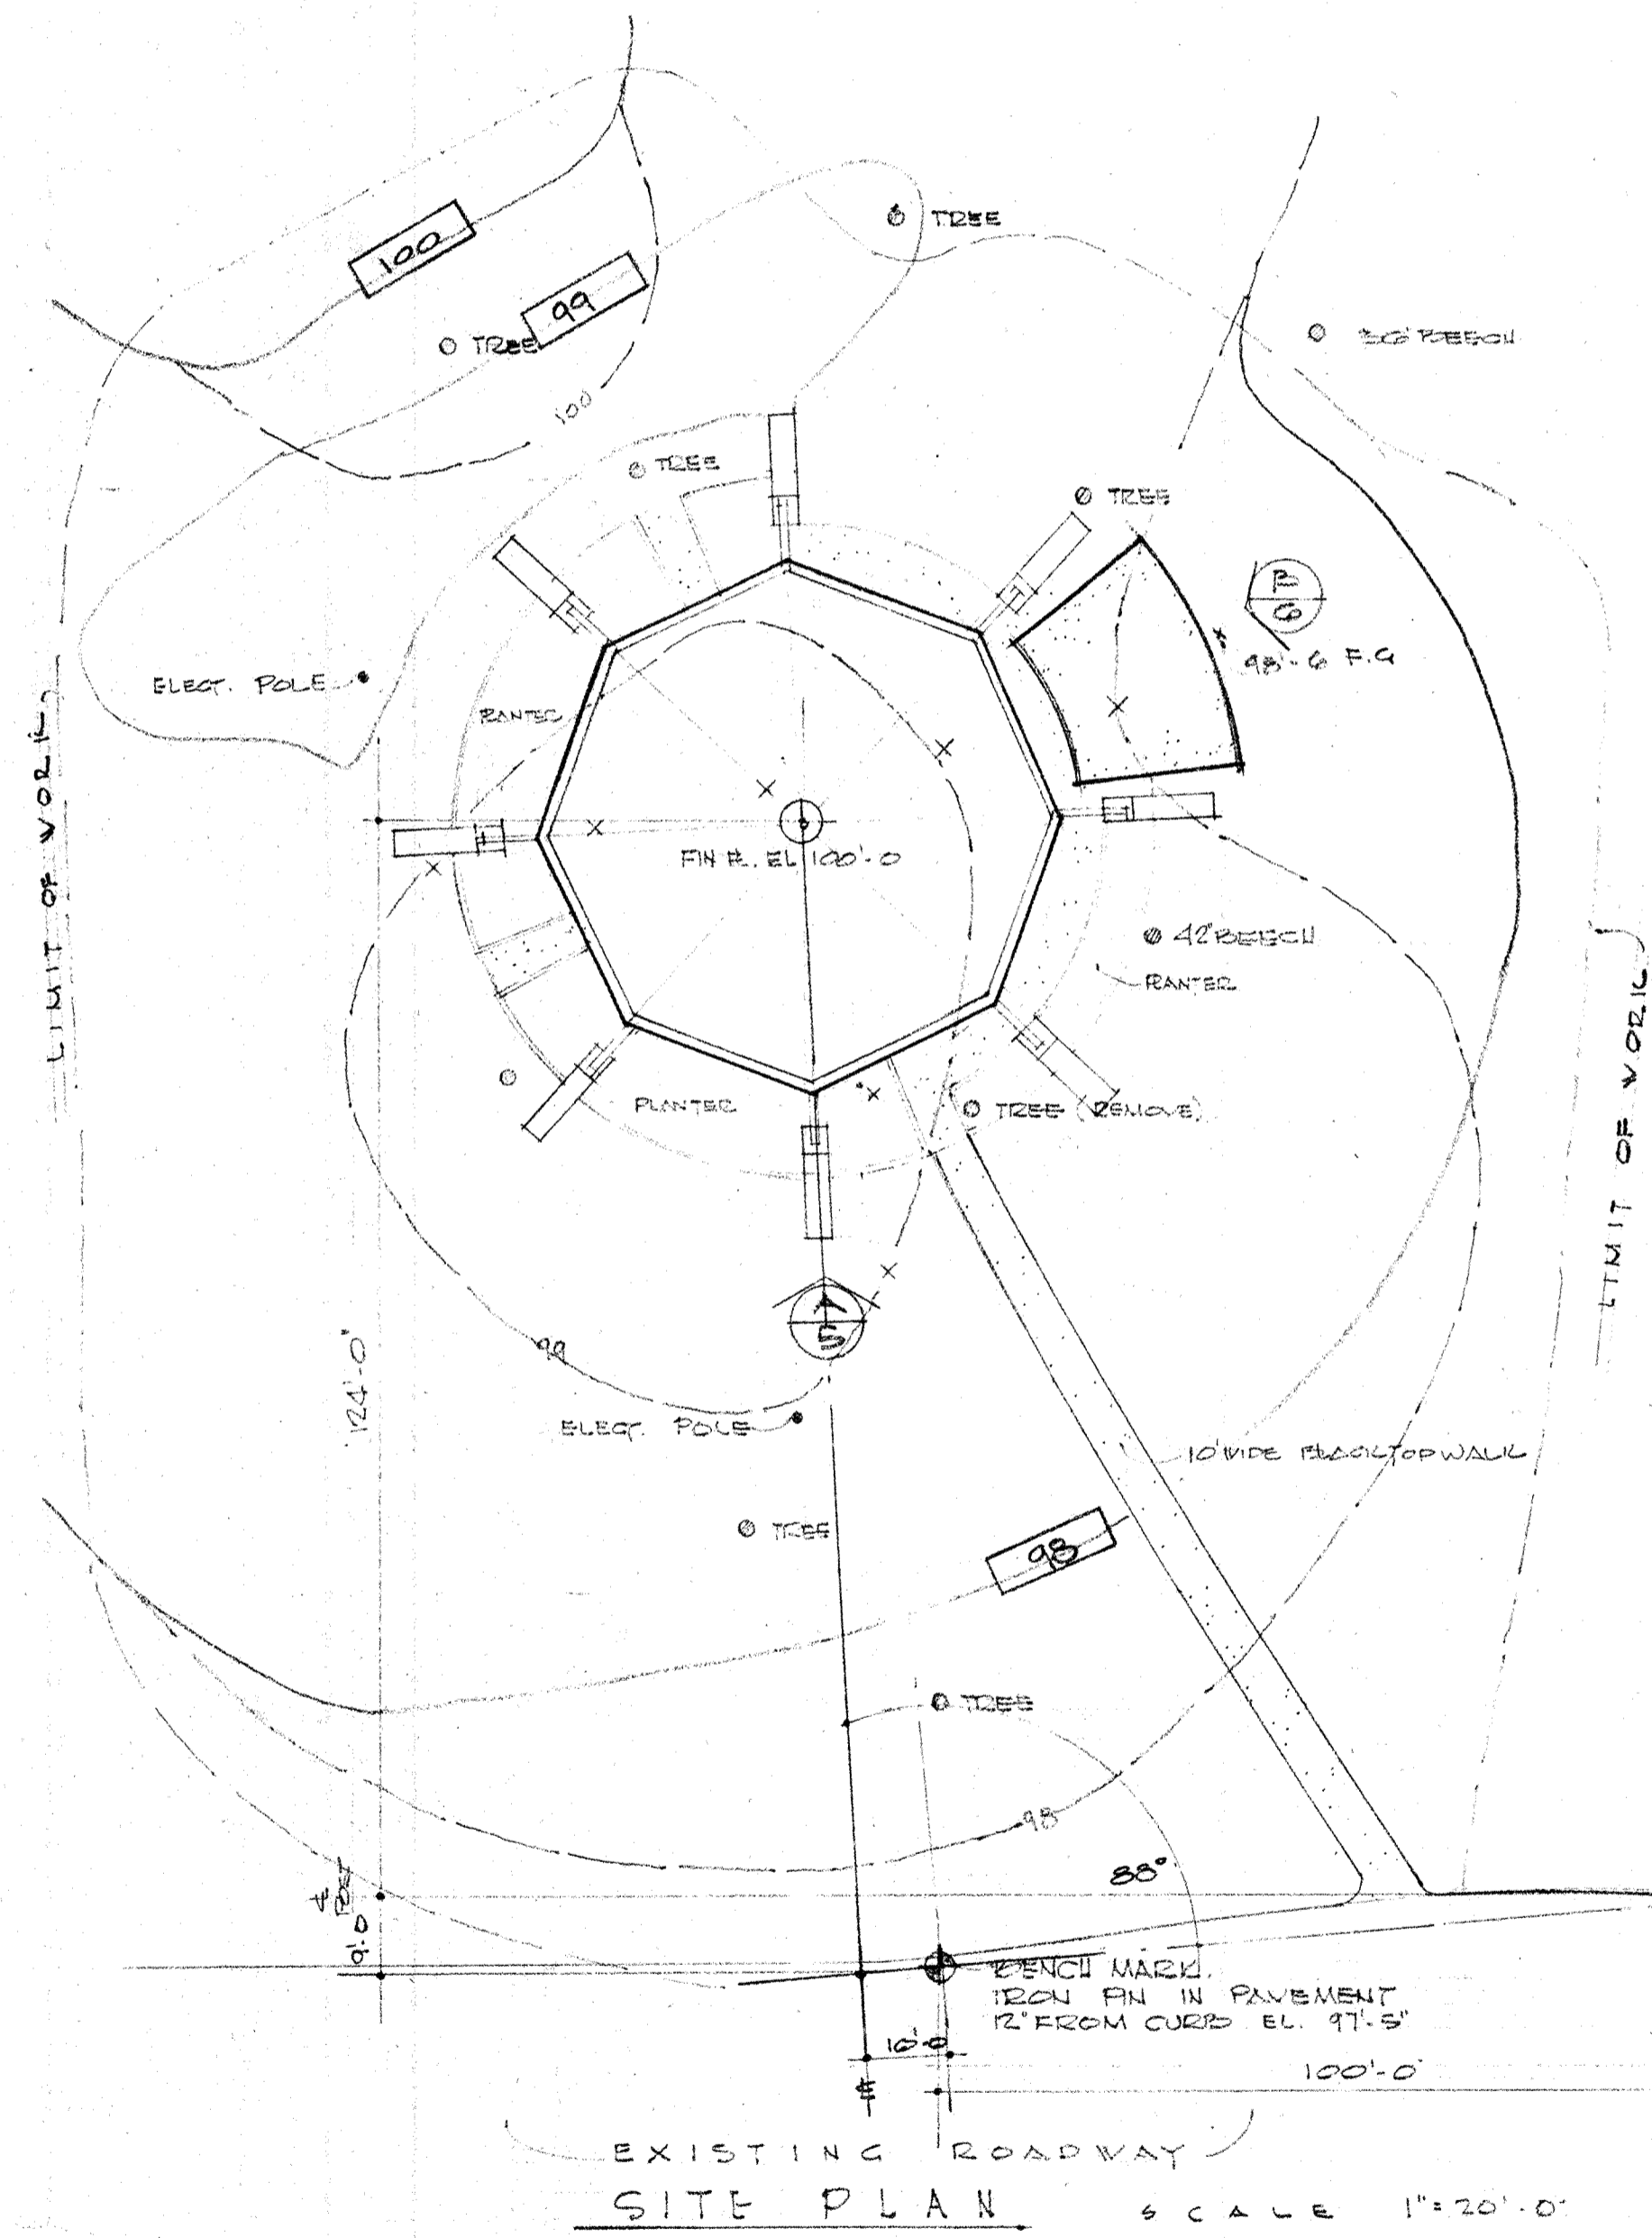


EXISTING CONTOUR XXX  
NEW CONTOUR XXXX

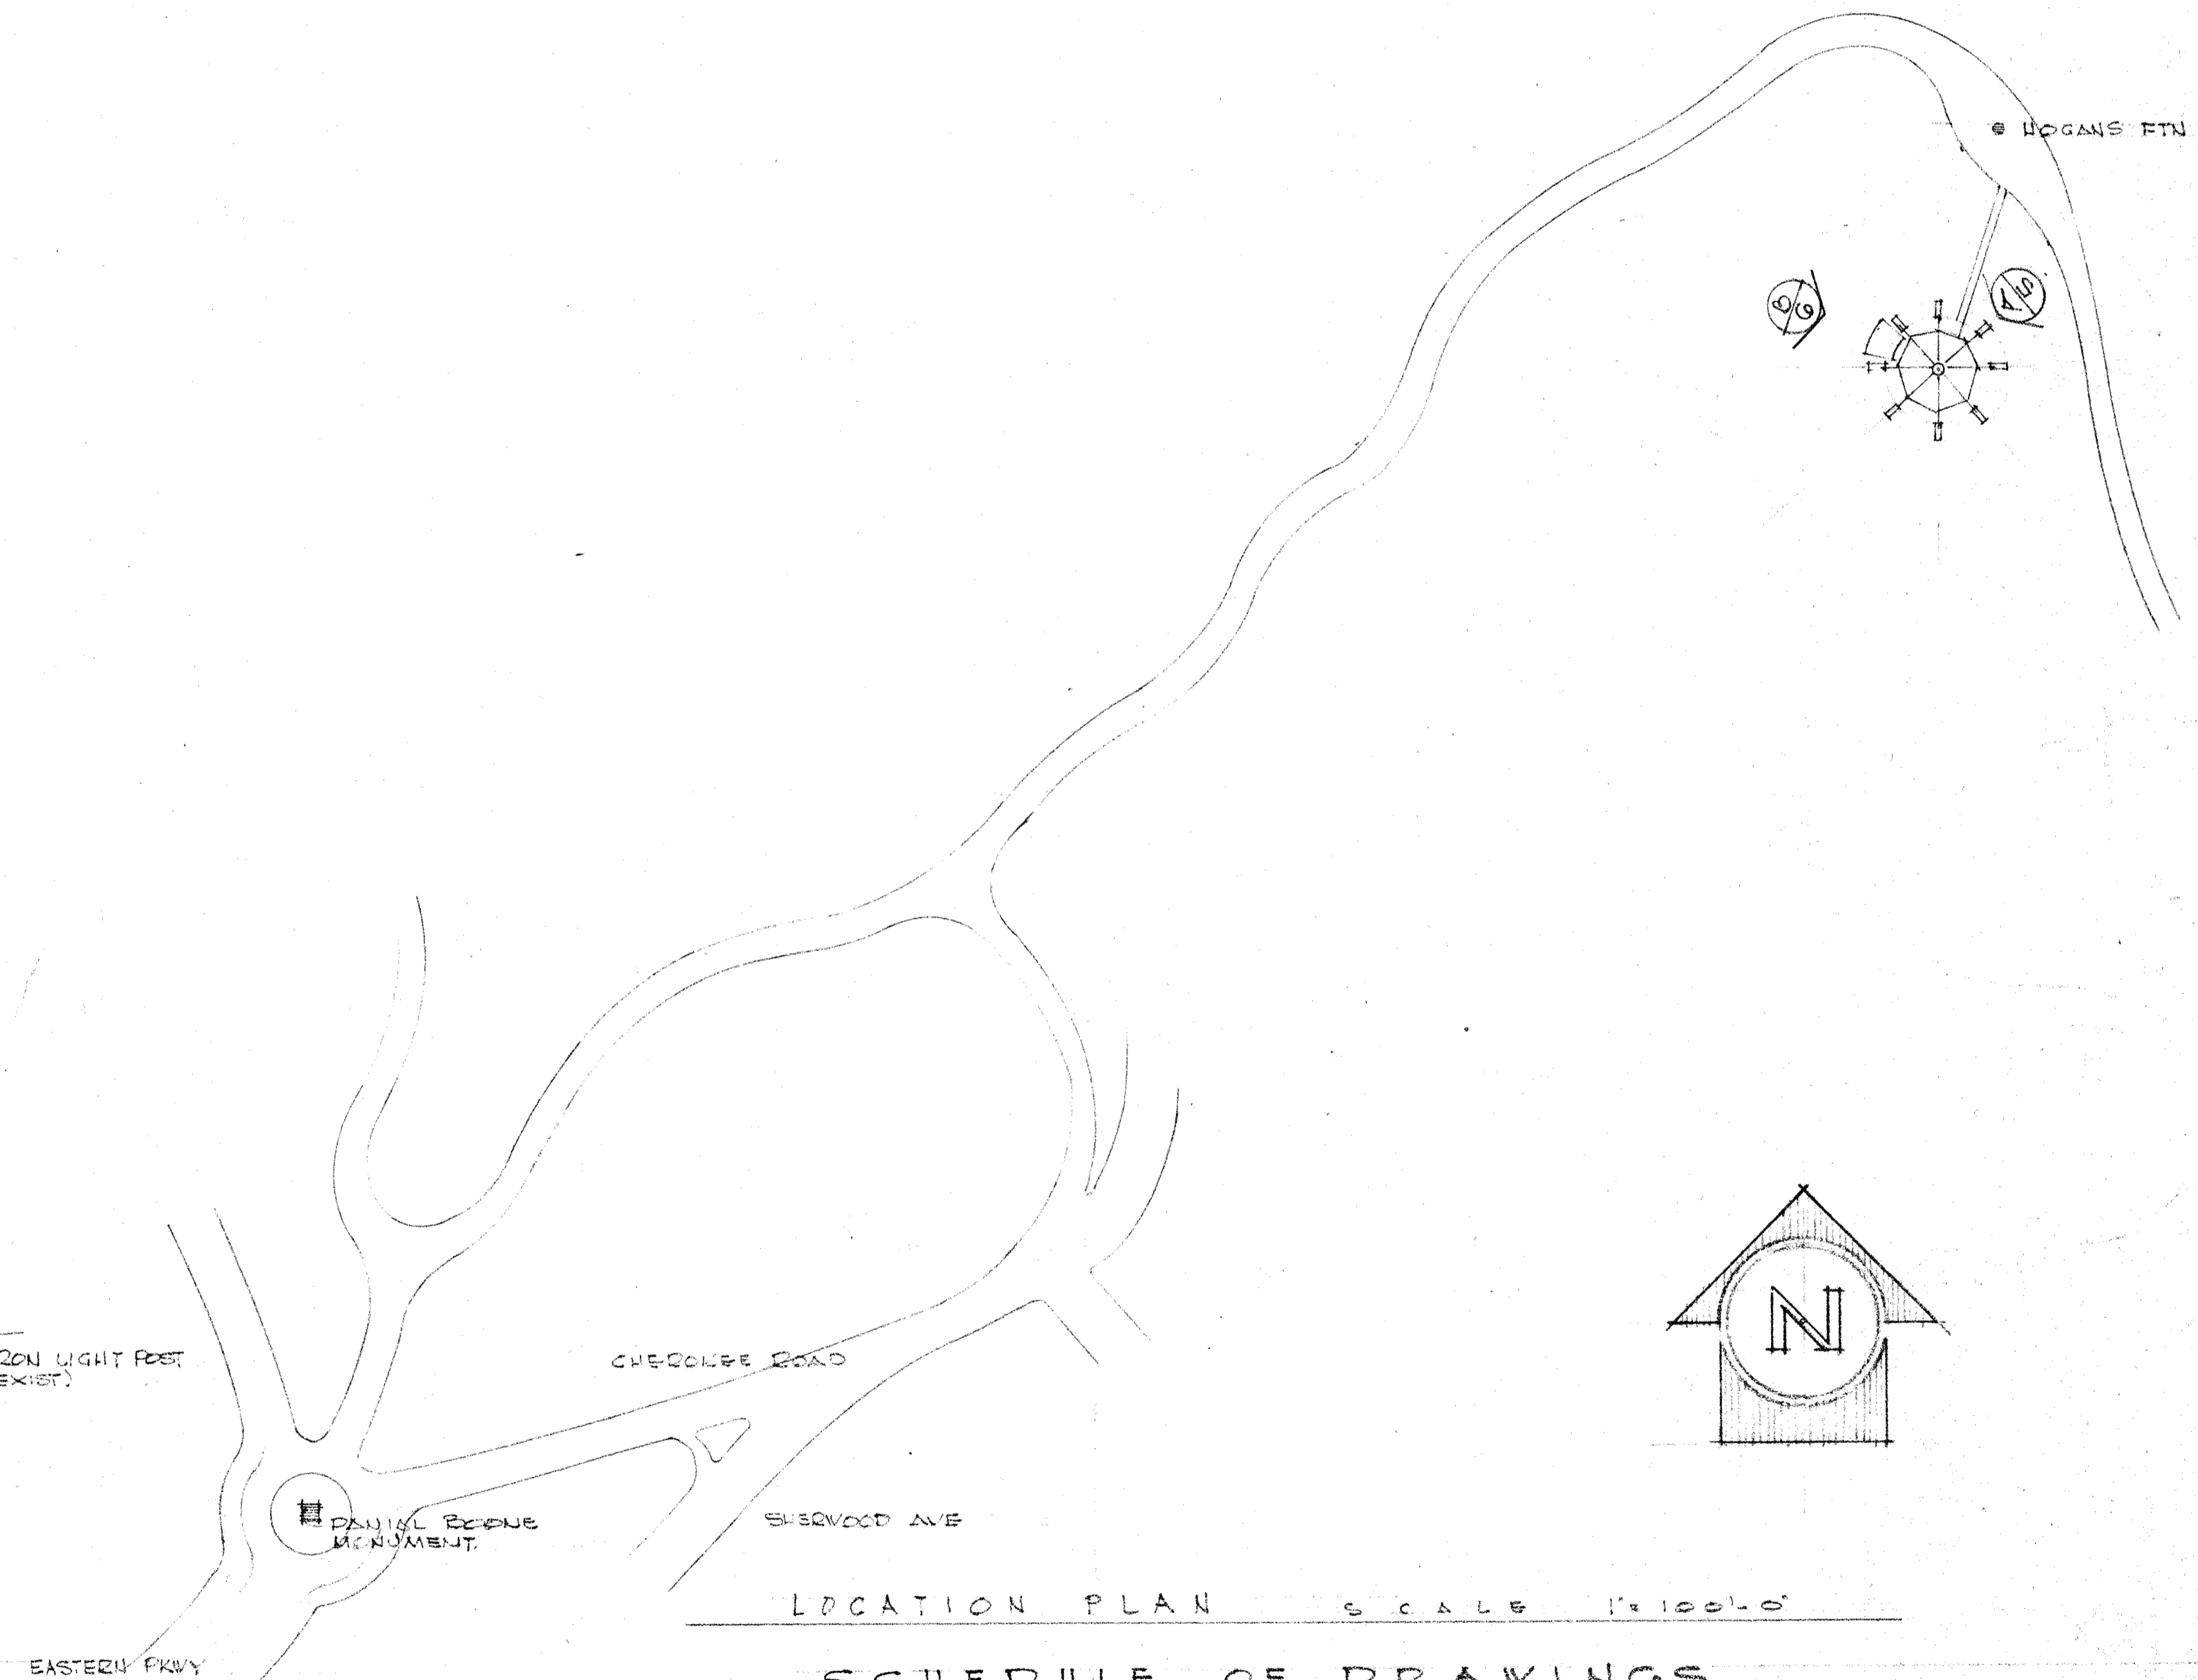

- SCHEDULE OF DRAWINGS**
- 1. TITLE SHEET & SITE PLAN
  - 2. FOUNDATION PLAN & DETAILS
  - 3. FLOOR PLAN AND DETAILS
  - 4. ROOF FRAMING & DETAILS
  - 5. ELEVATION & DETAILS
  - 6. ELEVATION & DETAILS
  - 7. LONGITUDINAL SECTION & DETAILS
  - 8. PLUMBING & HEATING PLAN & DETAILS
  - 9. ELECTRICAL PLAN & DETAILS

A NEW SHELTER HOUSE & COMFORT STATION  
FOR THE DEPARTMENT OF PARKS & RECREATION  
CITY OF LOUISVILLE, LOUISVILLE, KENTUCKY  
HOGANS FOUNTAIN IN CHEROKEE PARK

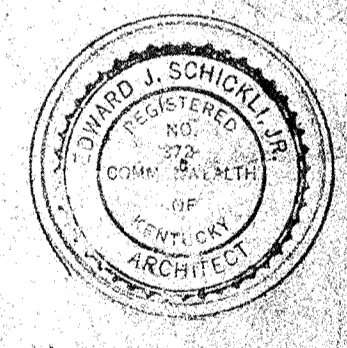


SHEET NO  
**1**  
99

DATE: 2 JAN 26  
DRAWN: G. W.

MEMBER OF THE  
AMERICAN INSTITUTE OF ARCHITECTS  
**TAFEL & SCHICKLI**  
ARCHITECTS  
& ENGINEERS  
310 WEST LIBERTY  
LOUISVILLE 2, KY.

A NEW SHELTER HOUSE + COMFORT STATION  
 FOR THE DEPARTMENT OF PARKS + RECREATION  
 CITY OF LOUISVILLE, LOUISVILLE, KENTUCKY  
 HOGANS FOUNTAIN IN CHEROKEE PARK

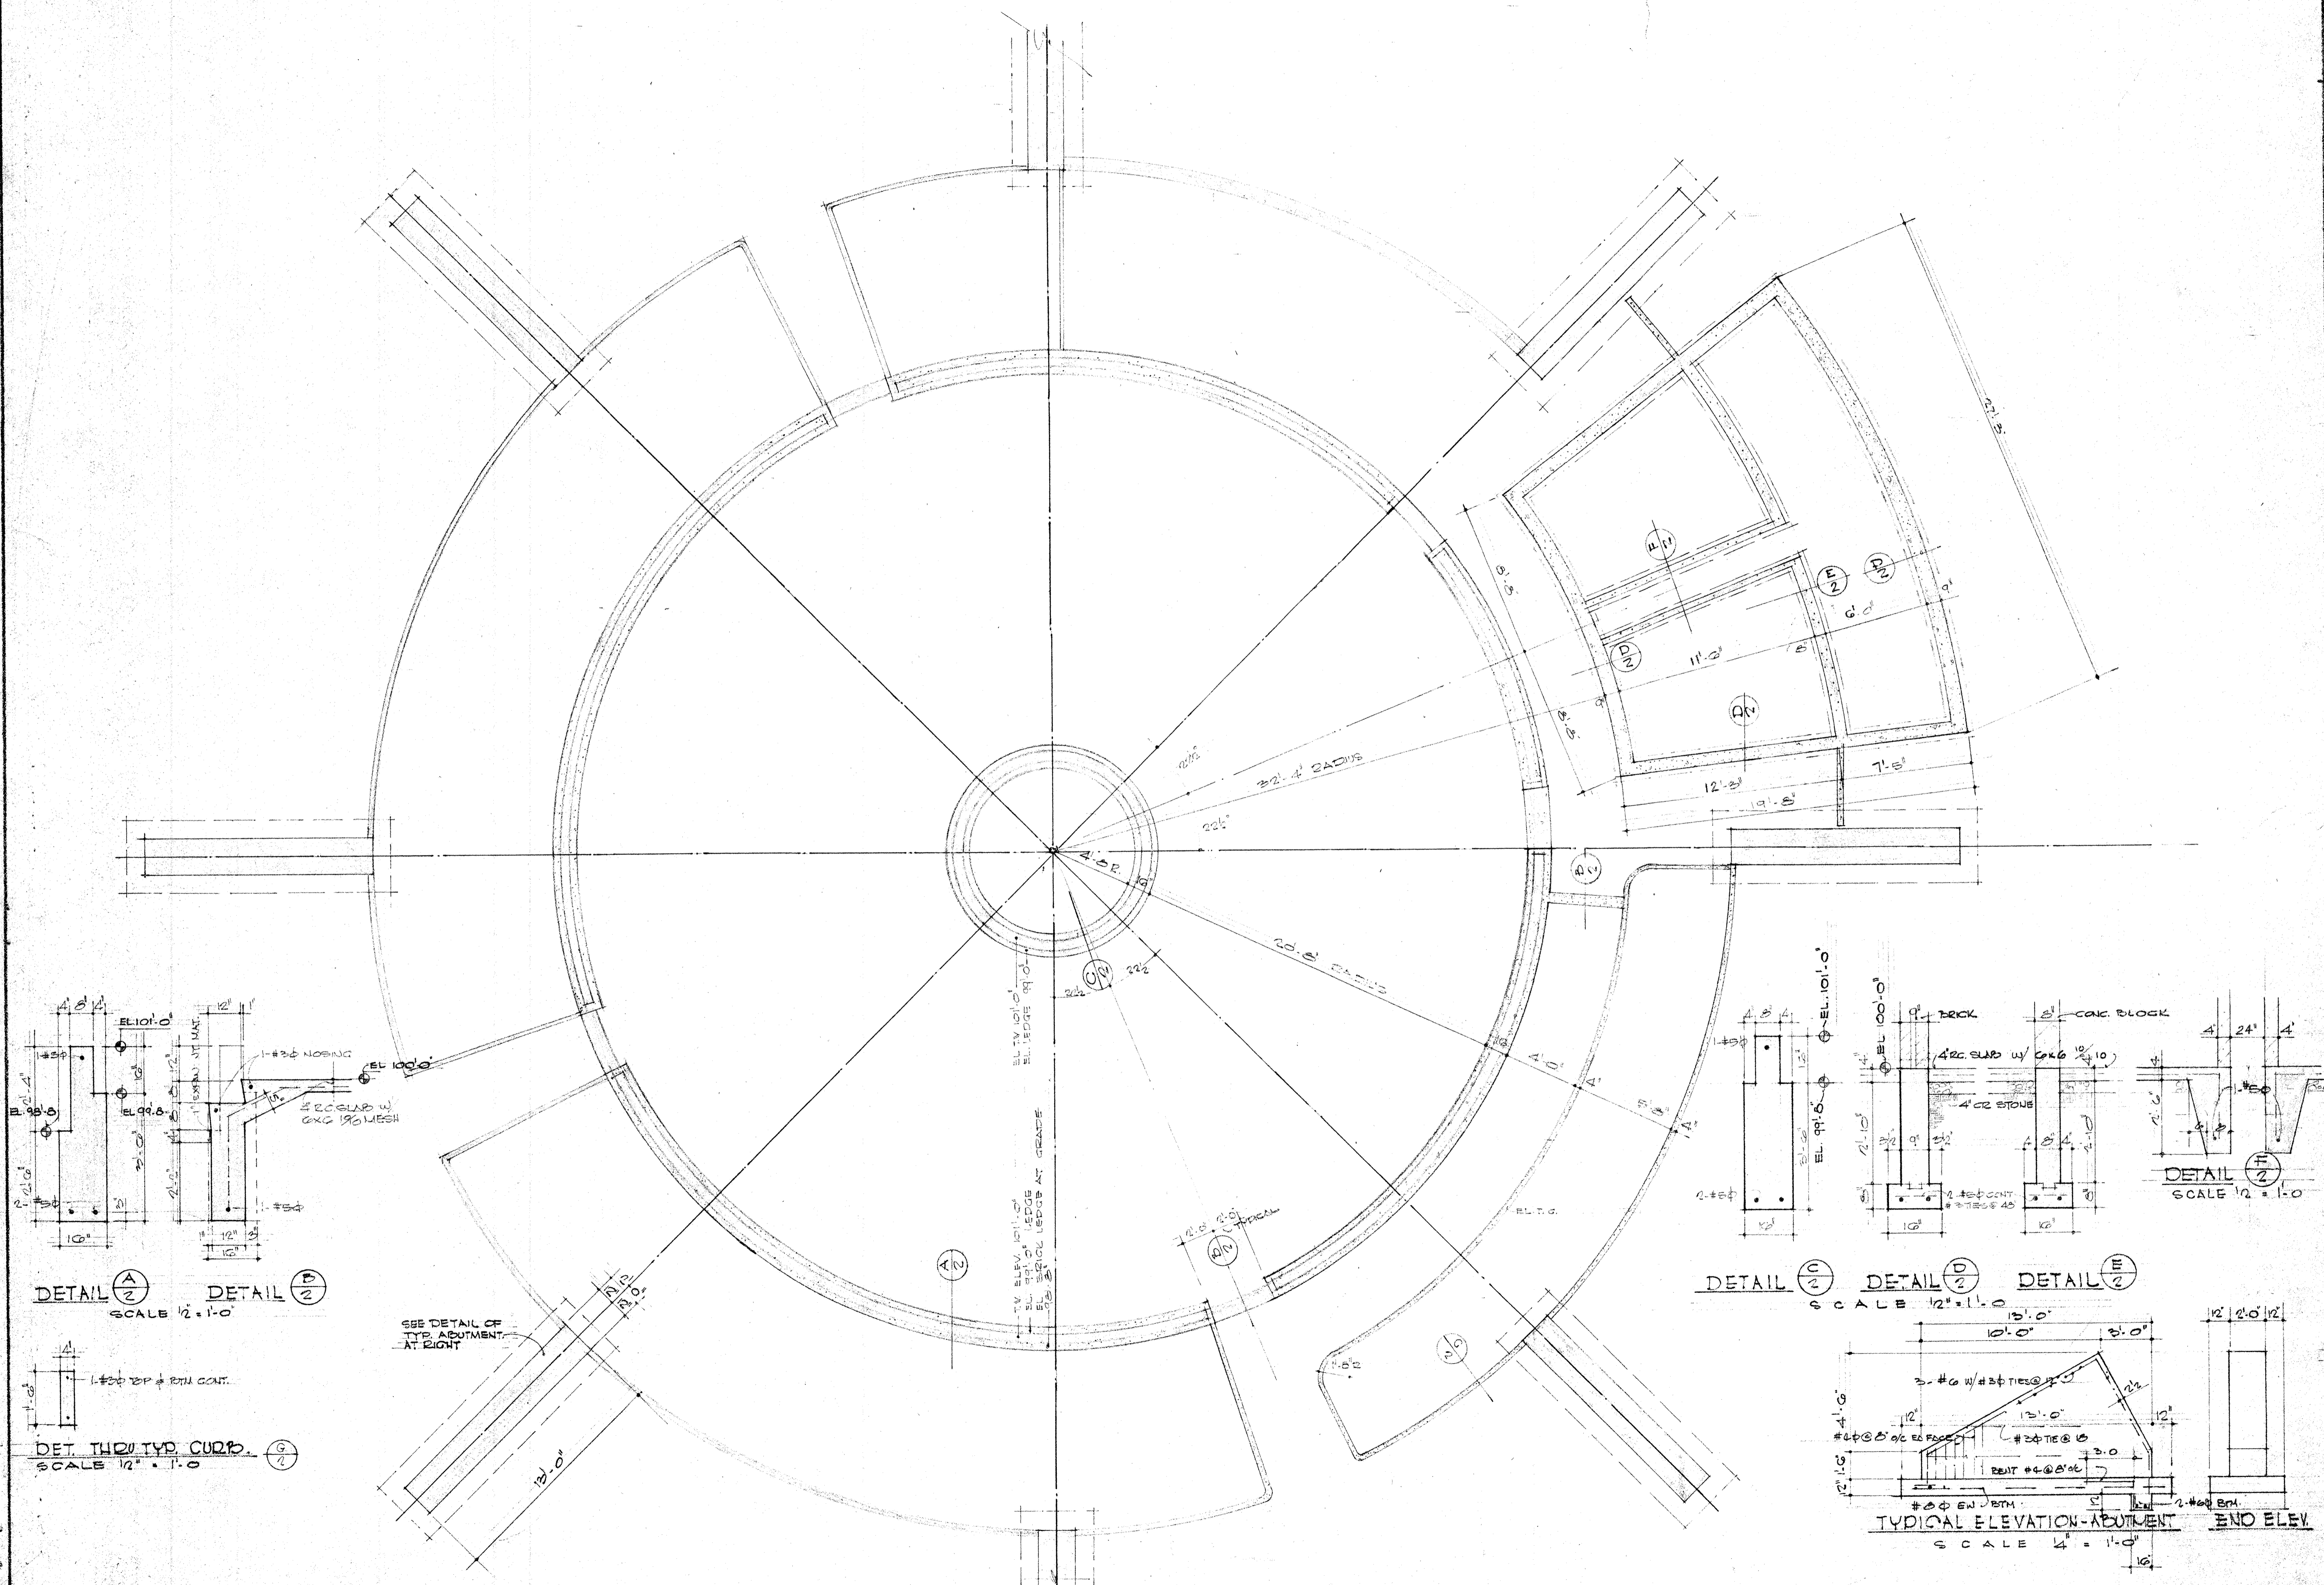


DETAIL **A** SCALE 1/2" = 1'-0"

DET. THRU TYP. CURB. SCALE 1/2" = 1'-0"


DETAIL **D** SCALE 1/2" = 1'-0"

TYPICAL ELEVATION - ABUTMENT  
 END ELEV.  
 SCALE 1/4" = 1'-0"


ELL. NO.  
 2  
 49  
 DATE: 7/10/59  
 DRAWN: GN

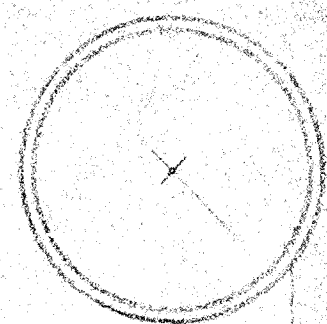


A NEW SHELTER HOUSE & COMFORT STATION  
 FOR THE DEPARTMENT OF PARKS & RECREATION  
 CITY OF LOUISVILLE, LOUISVILLE, KENTUCKY  
 HOGANS FOUNTAIN IN CHEROKEE PARK

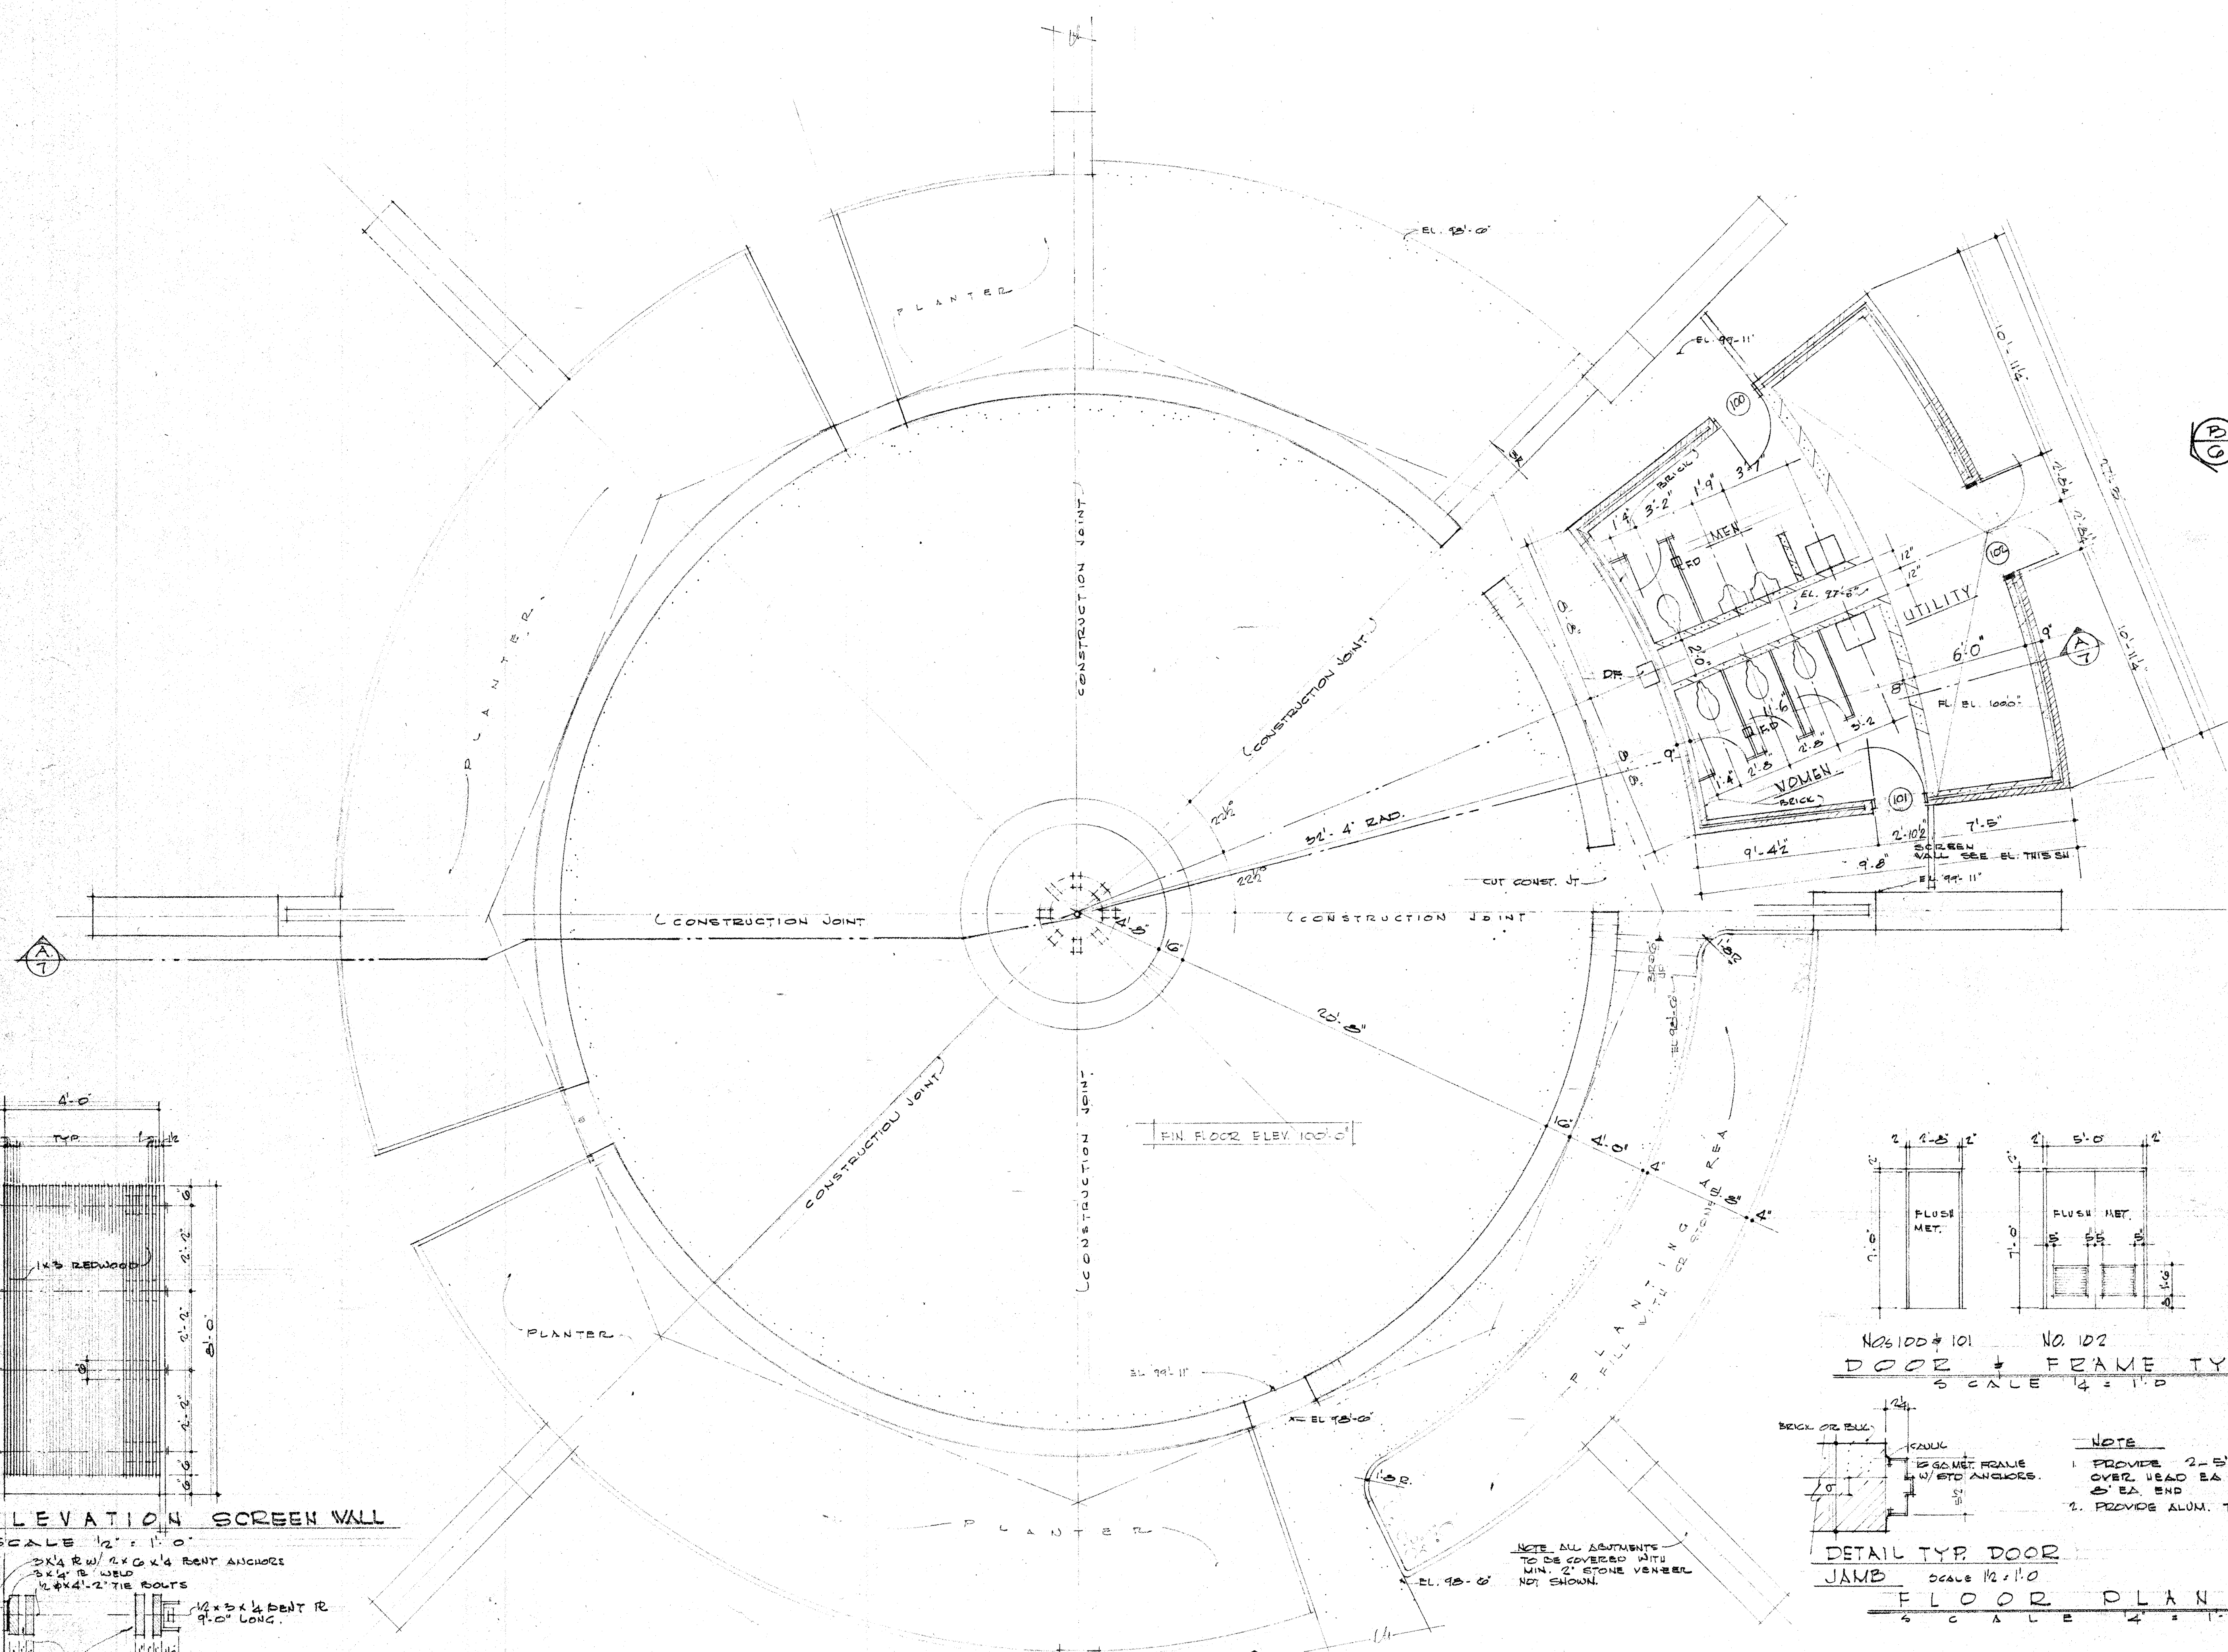


(6) ELEVATION

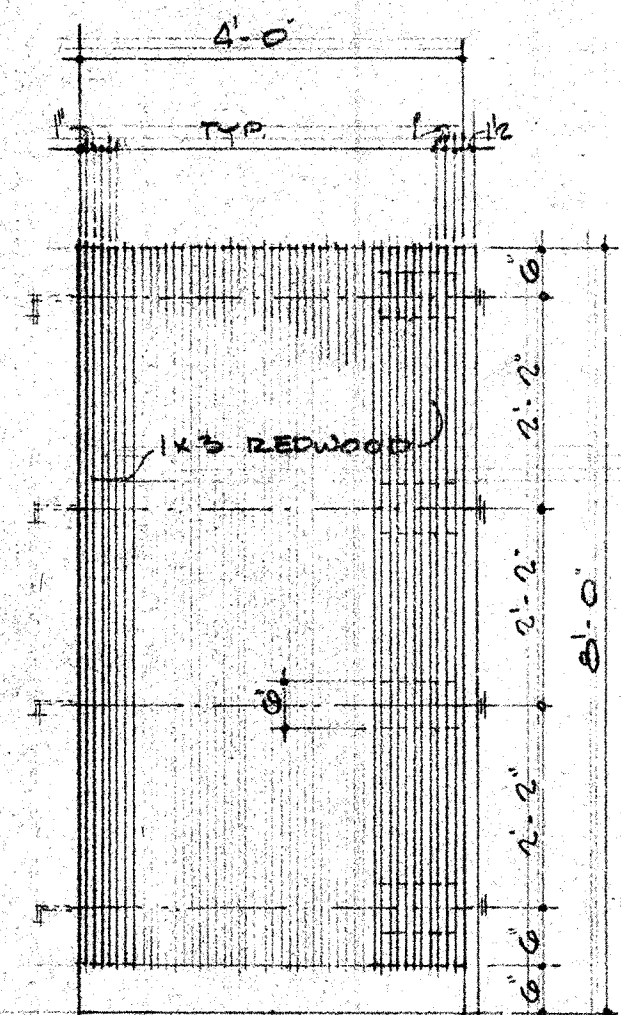


ELEVATION SCREEN WALL  
 SCALE 1/2" = 1'-0"

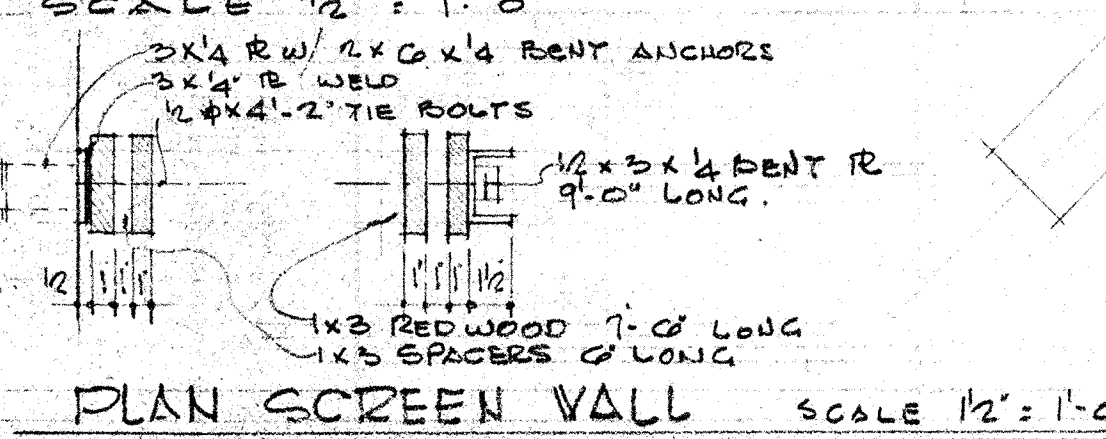

PLAN SCREEN WALL SCALE 1/2" = 1'-0"

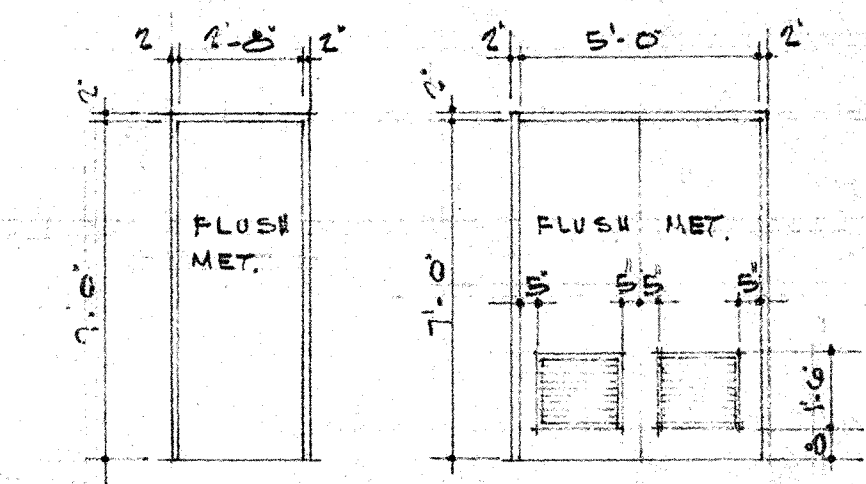

NO. 100 & 101 NO. 102  
 DOOR & FRAME TYPES  
 SCALE 1/4" = 1'-0"

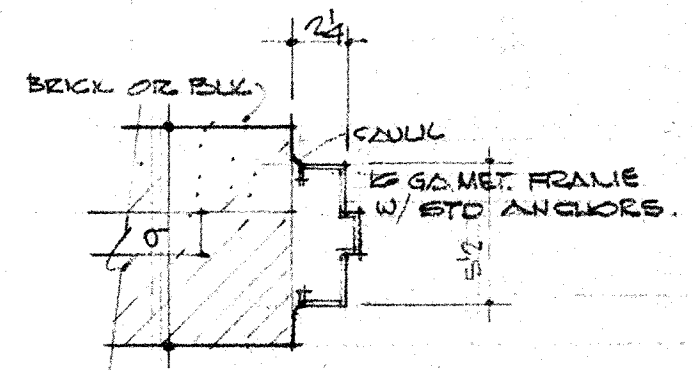


DETAIL TYP. DOOR  
 JAMB SCALE 1/2" = 1'-0"  
 FLOOR PLAN SCALE 1/4" = 1'-0"

- NOTE
1. PROVIDE 2-5" x 5/8" x 5/16" C'S OVER HEAD EA DOOR. MIN BRG 5' EA. END
  2. PROVIDE ALUM. THRESH @ EA. DOOR

NOTE ALL DIMENSIONS TO BE COVERED WITH MIN 2" STONE VENEER NOT SHOWN



(5) ELEVATION

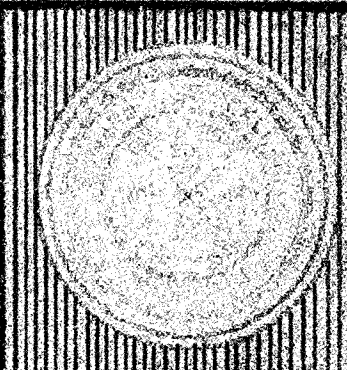


SHEET NO.  
 3  
 OF 9

DATE: 27 JAN 34  
 Dwg. NEWTON


T. A. SCHICKEL  
 ARCHITECT & ENGINEER  
 310 WEST LIBERTY  
 LOUISVILLE 2, KY

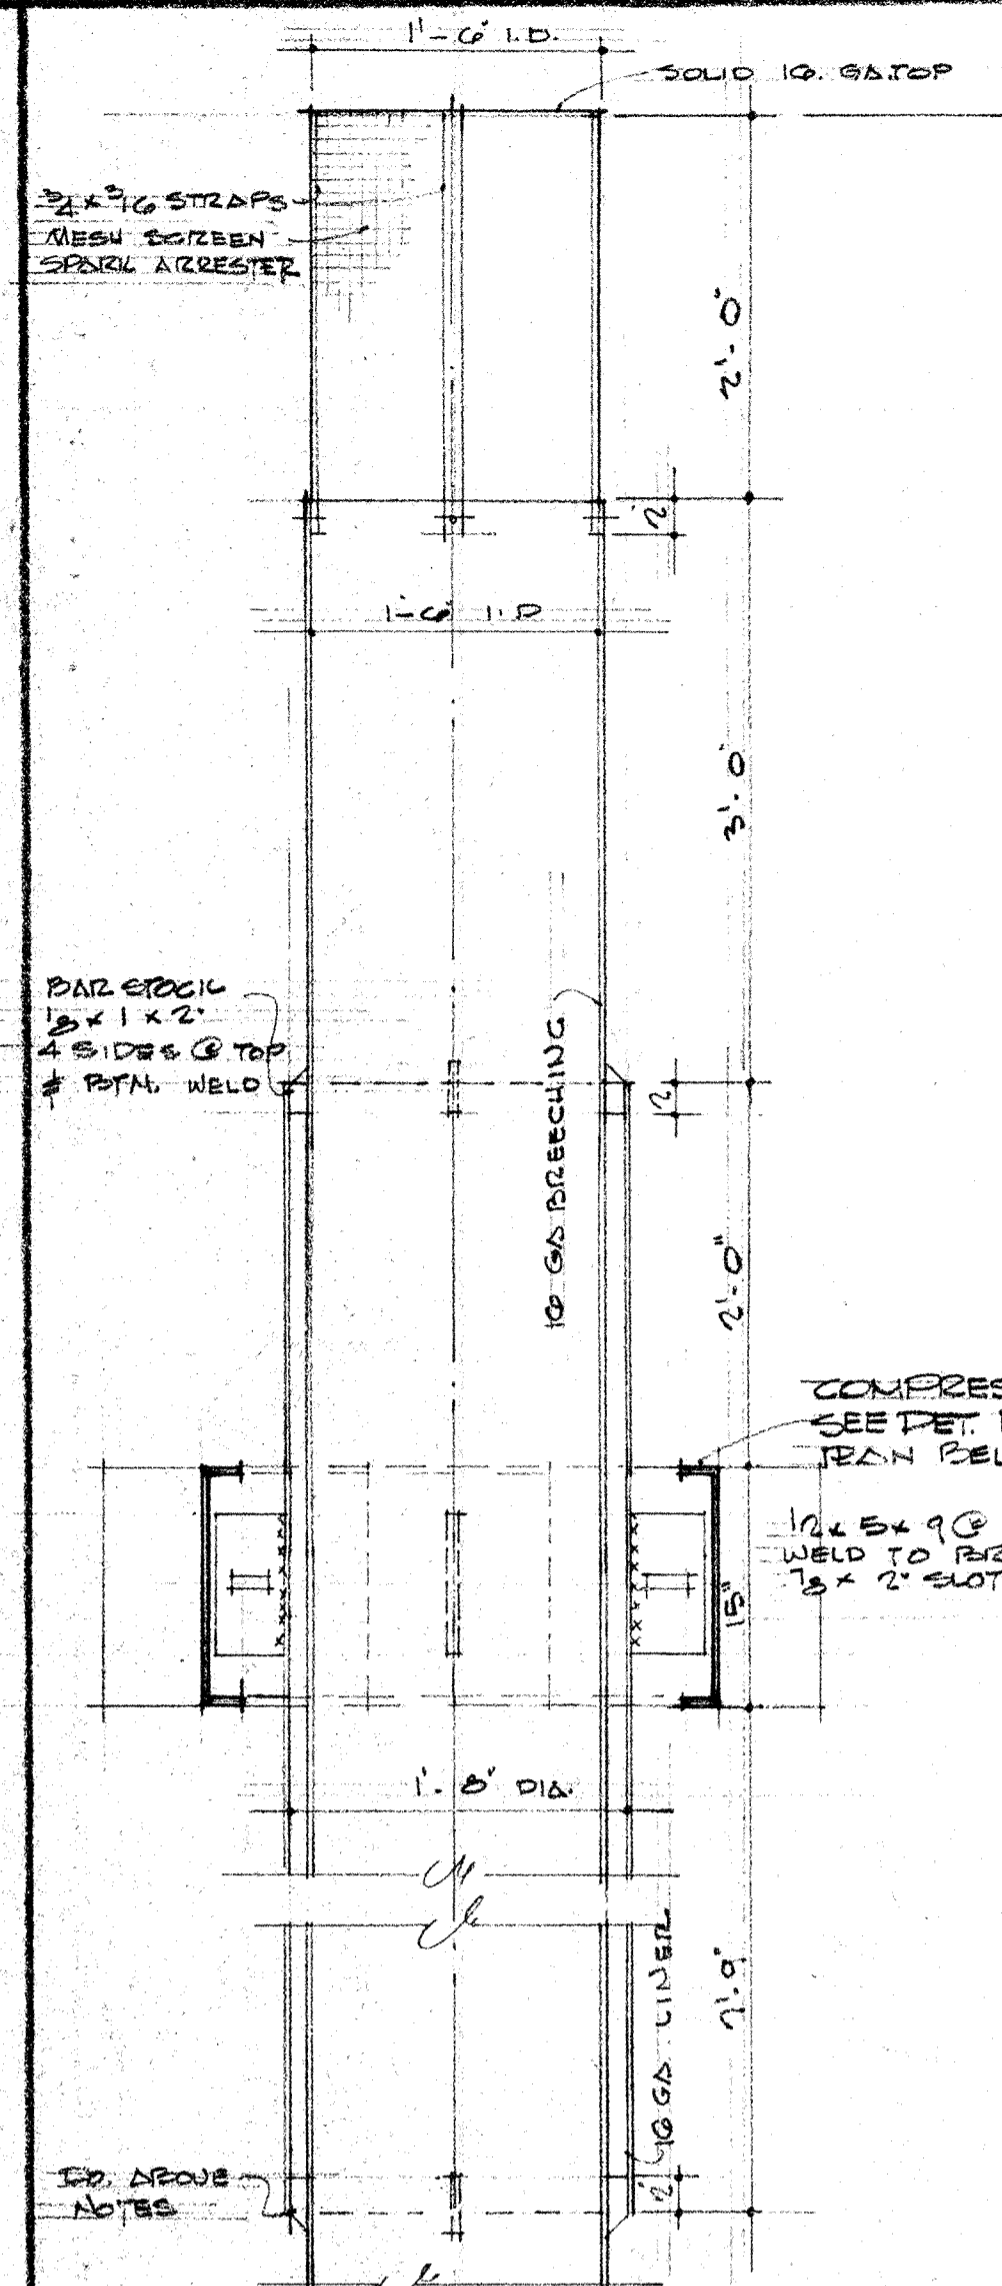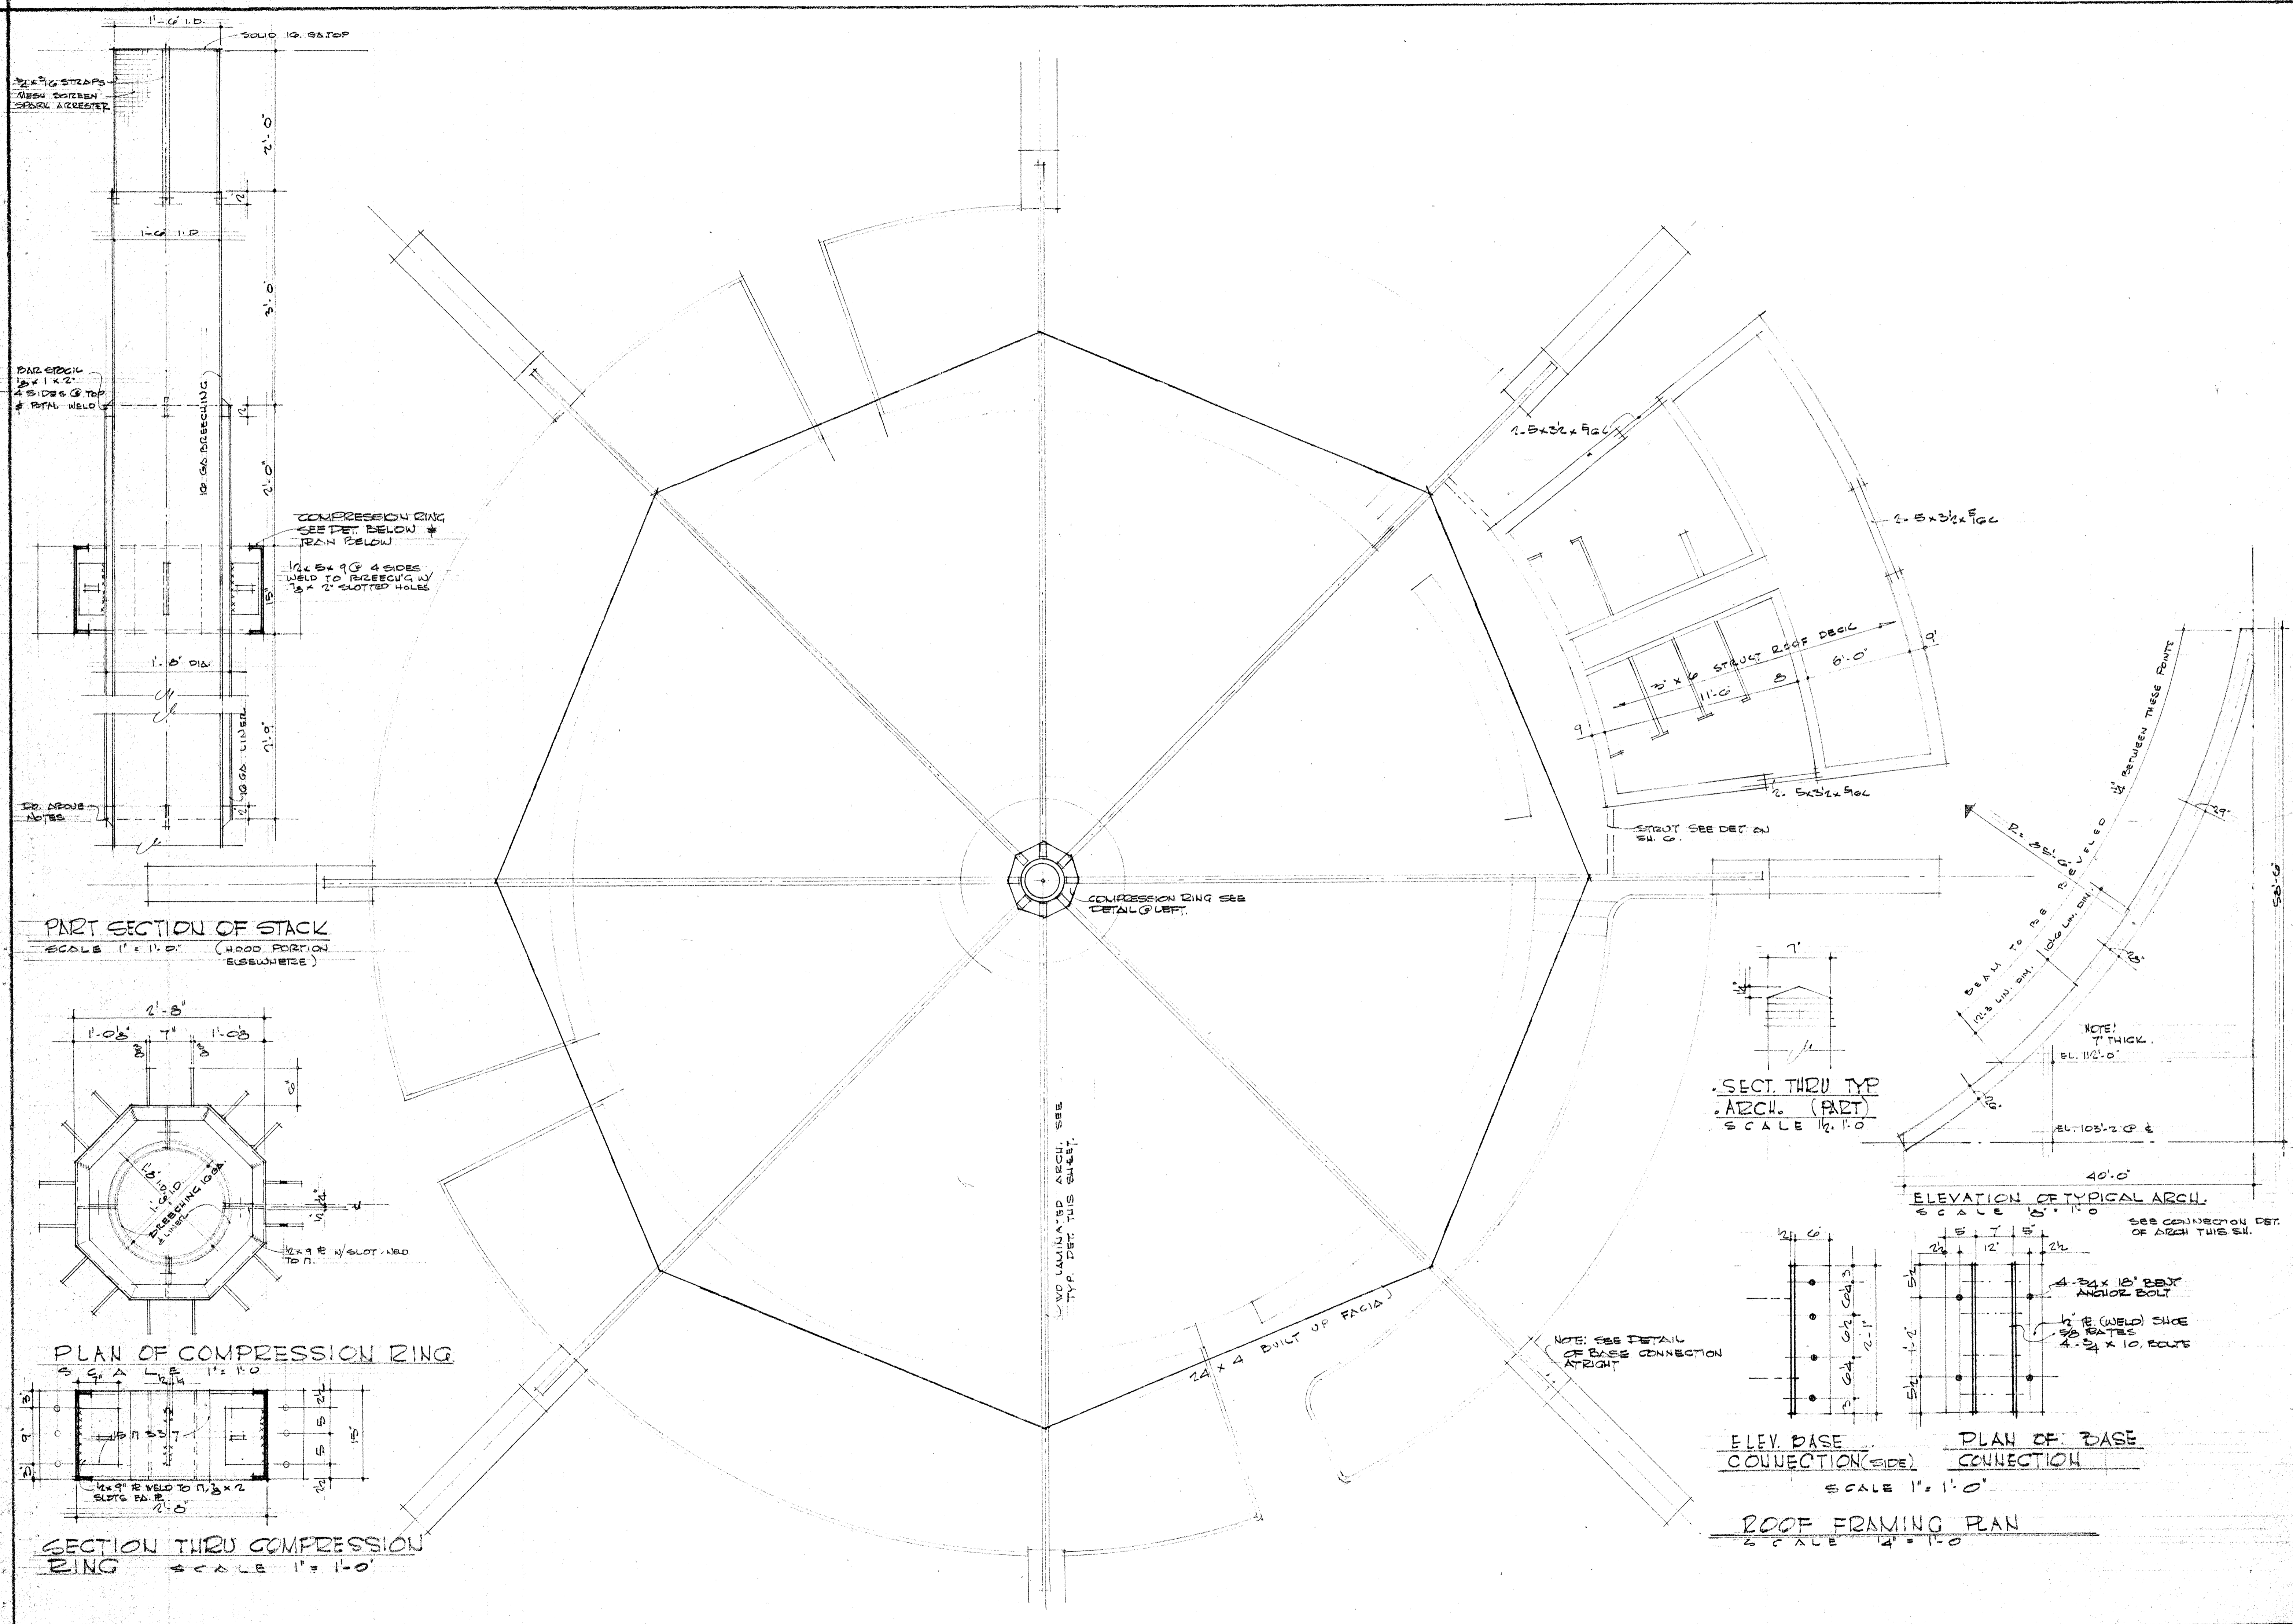


PART SECTION OF STACK  
SCALE 1" = 1'-0"

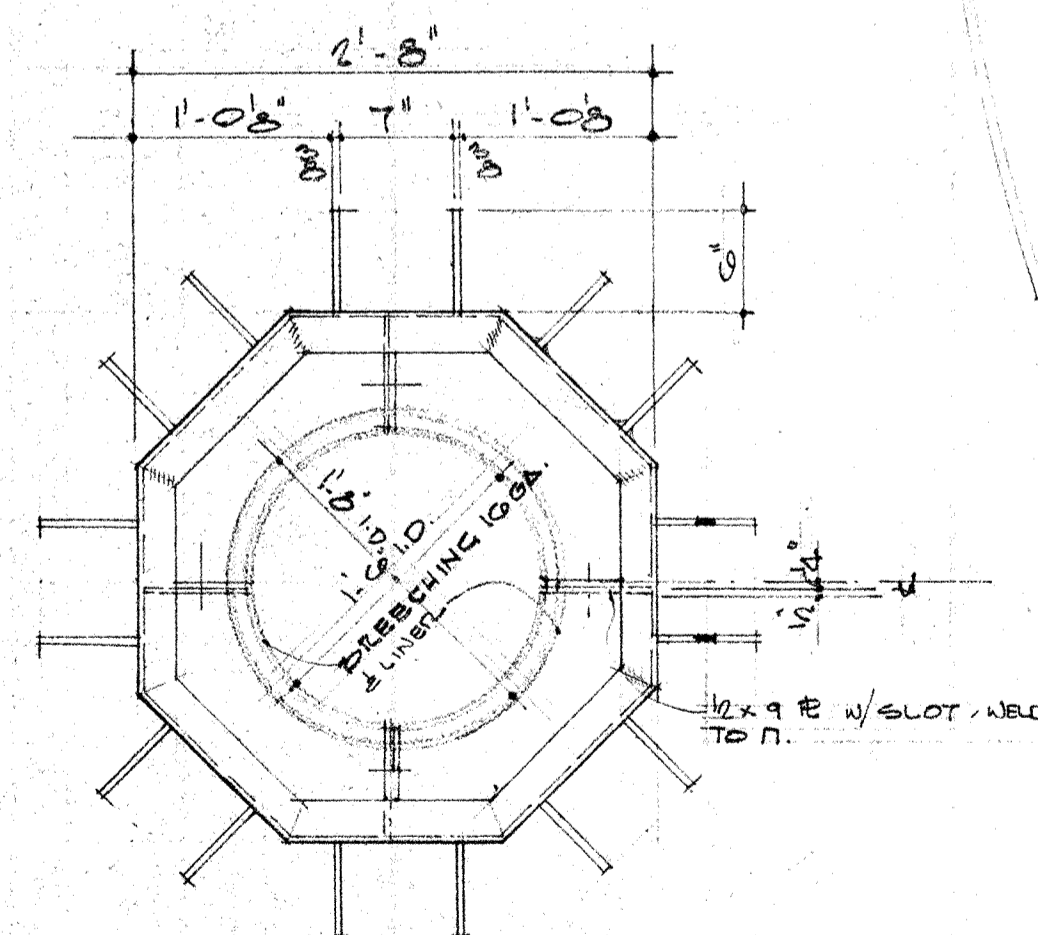


PLAN OF COMPRESSION RING  
SCALE 1" = 1'-0"

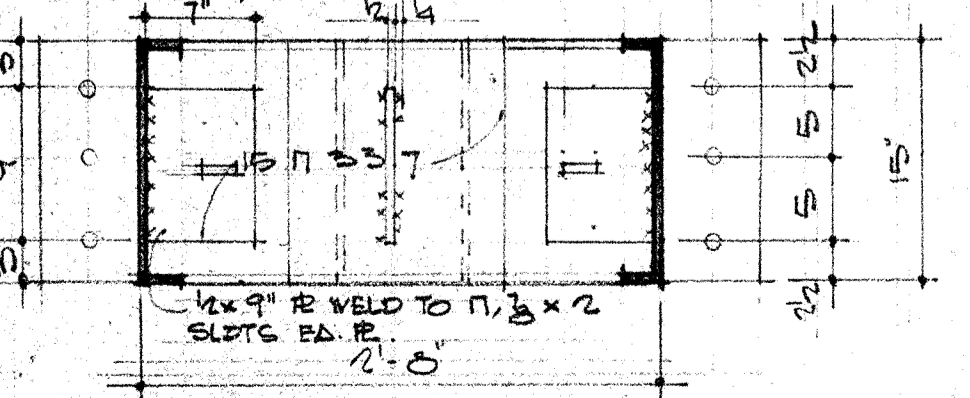


SECTION THRU COMPRESSION RING  
SCALE 1" = 1'-0"

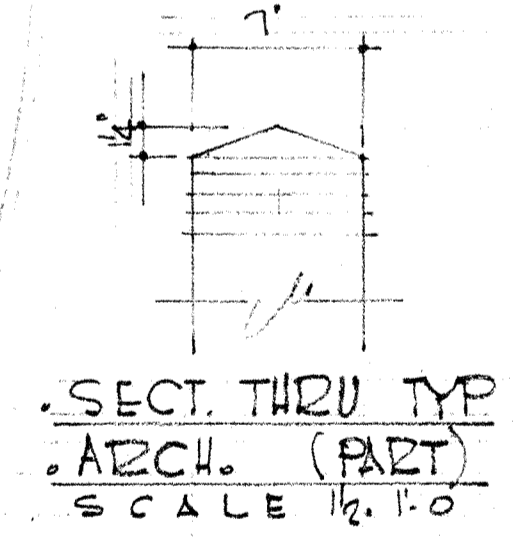

SECTION THRU TYP. ARCH. (PART)  
SCALE 1/2" = 1'-0"

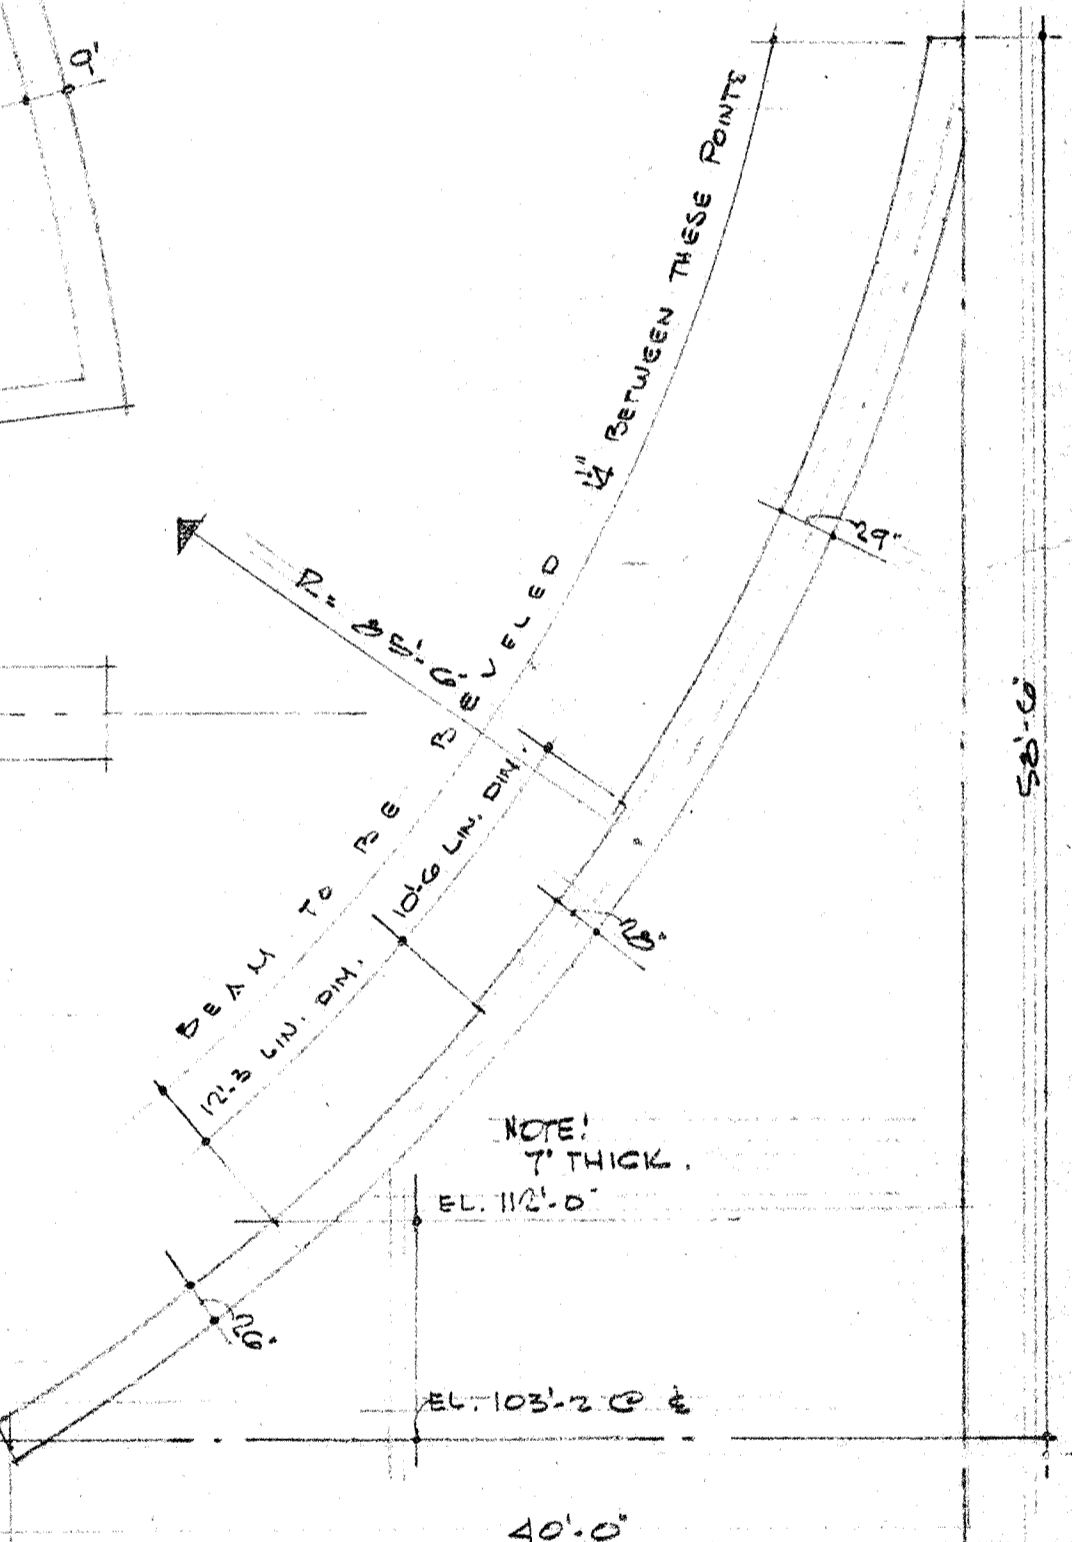




ELEVATION OF TYPICAL ARCH.  
SCALE 1/2" = 1'-0"

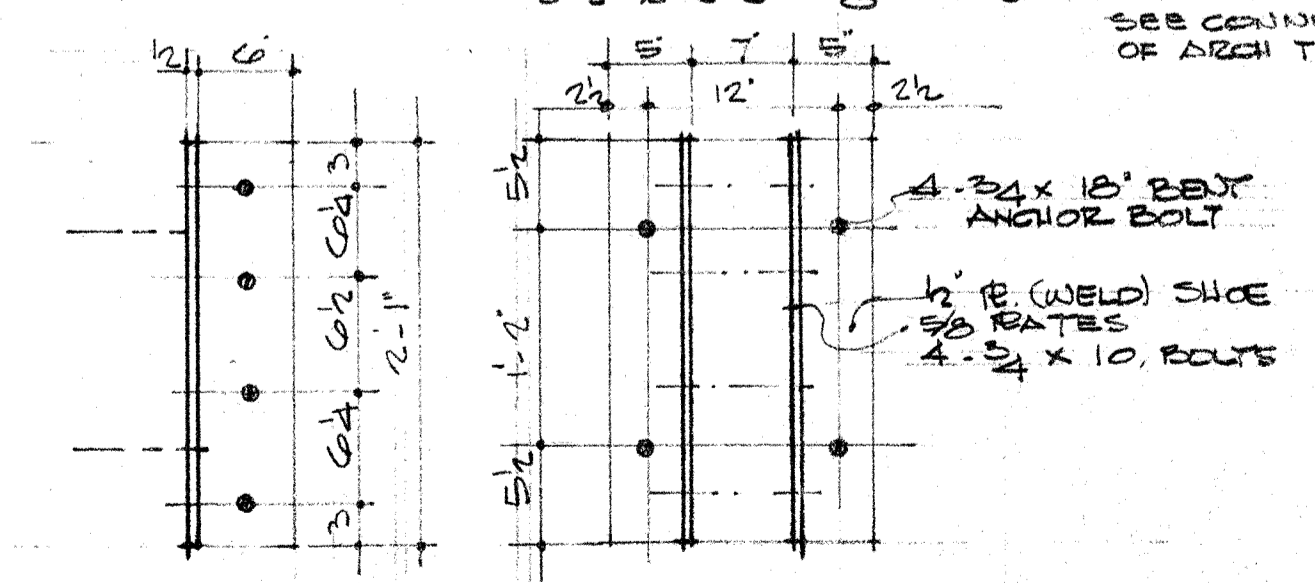

ELEV. BASE CONNECTION (SIDE) and PLAN OF BASE CONNECTION  
SCALE 1" = 1'-0"


ROOF FRAMING PLAN  
SCALE 1/4" = 1'-0"

A NEW SHELTER HOUSE • COMFORT STATION  
FOR THE DEPARTMENT OF PARKS & RECREATION  
CITY OF LOUISVILLE, LOUISVILLE, KENTUCKY  
HOGANS FOUNTAIN AT CHEROKEE PARK

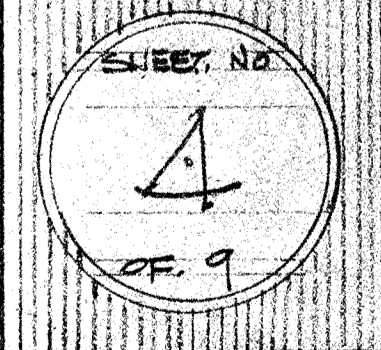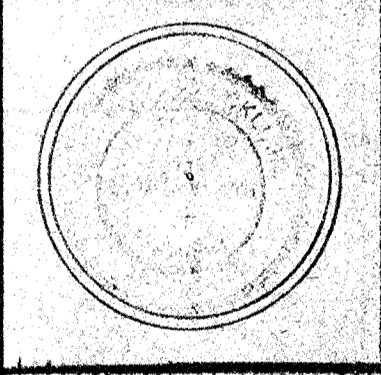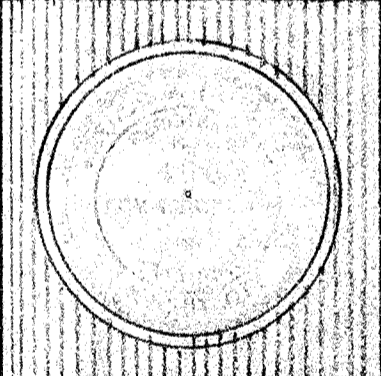


DATE: 2 JUN 68  
DWG: GN


TAFEL & SCHICKLI  
ARCHITECTS  
& ENGINEERS  
100 W. LIBERTY  
LOUISVILLE, KY

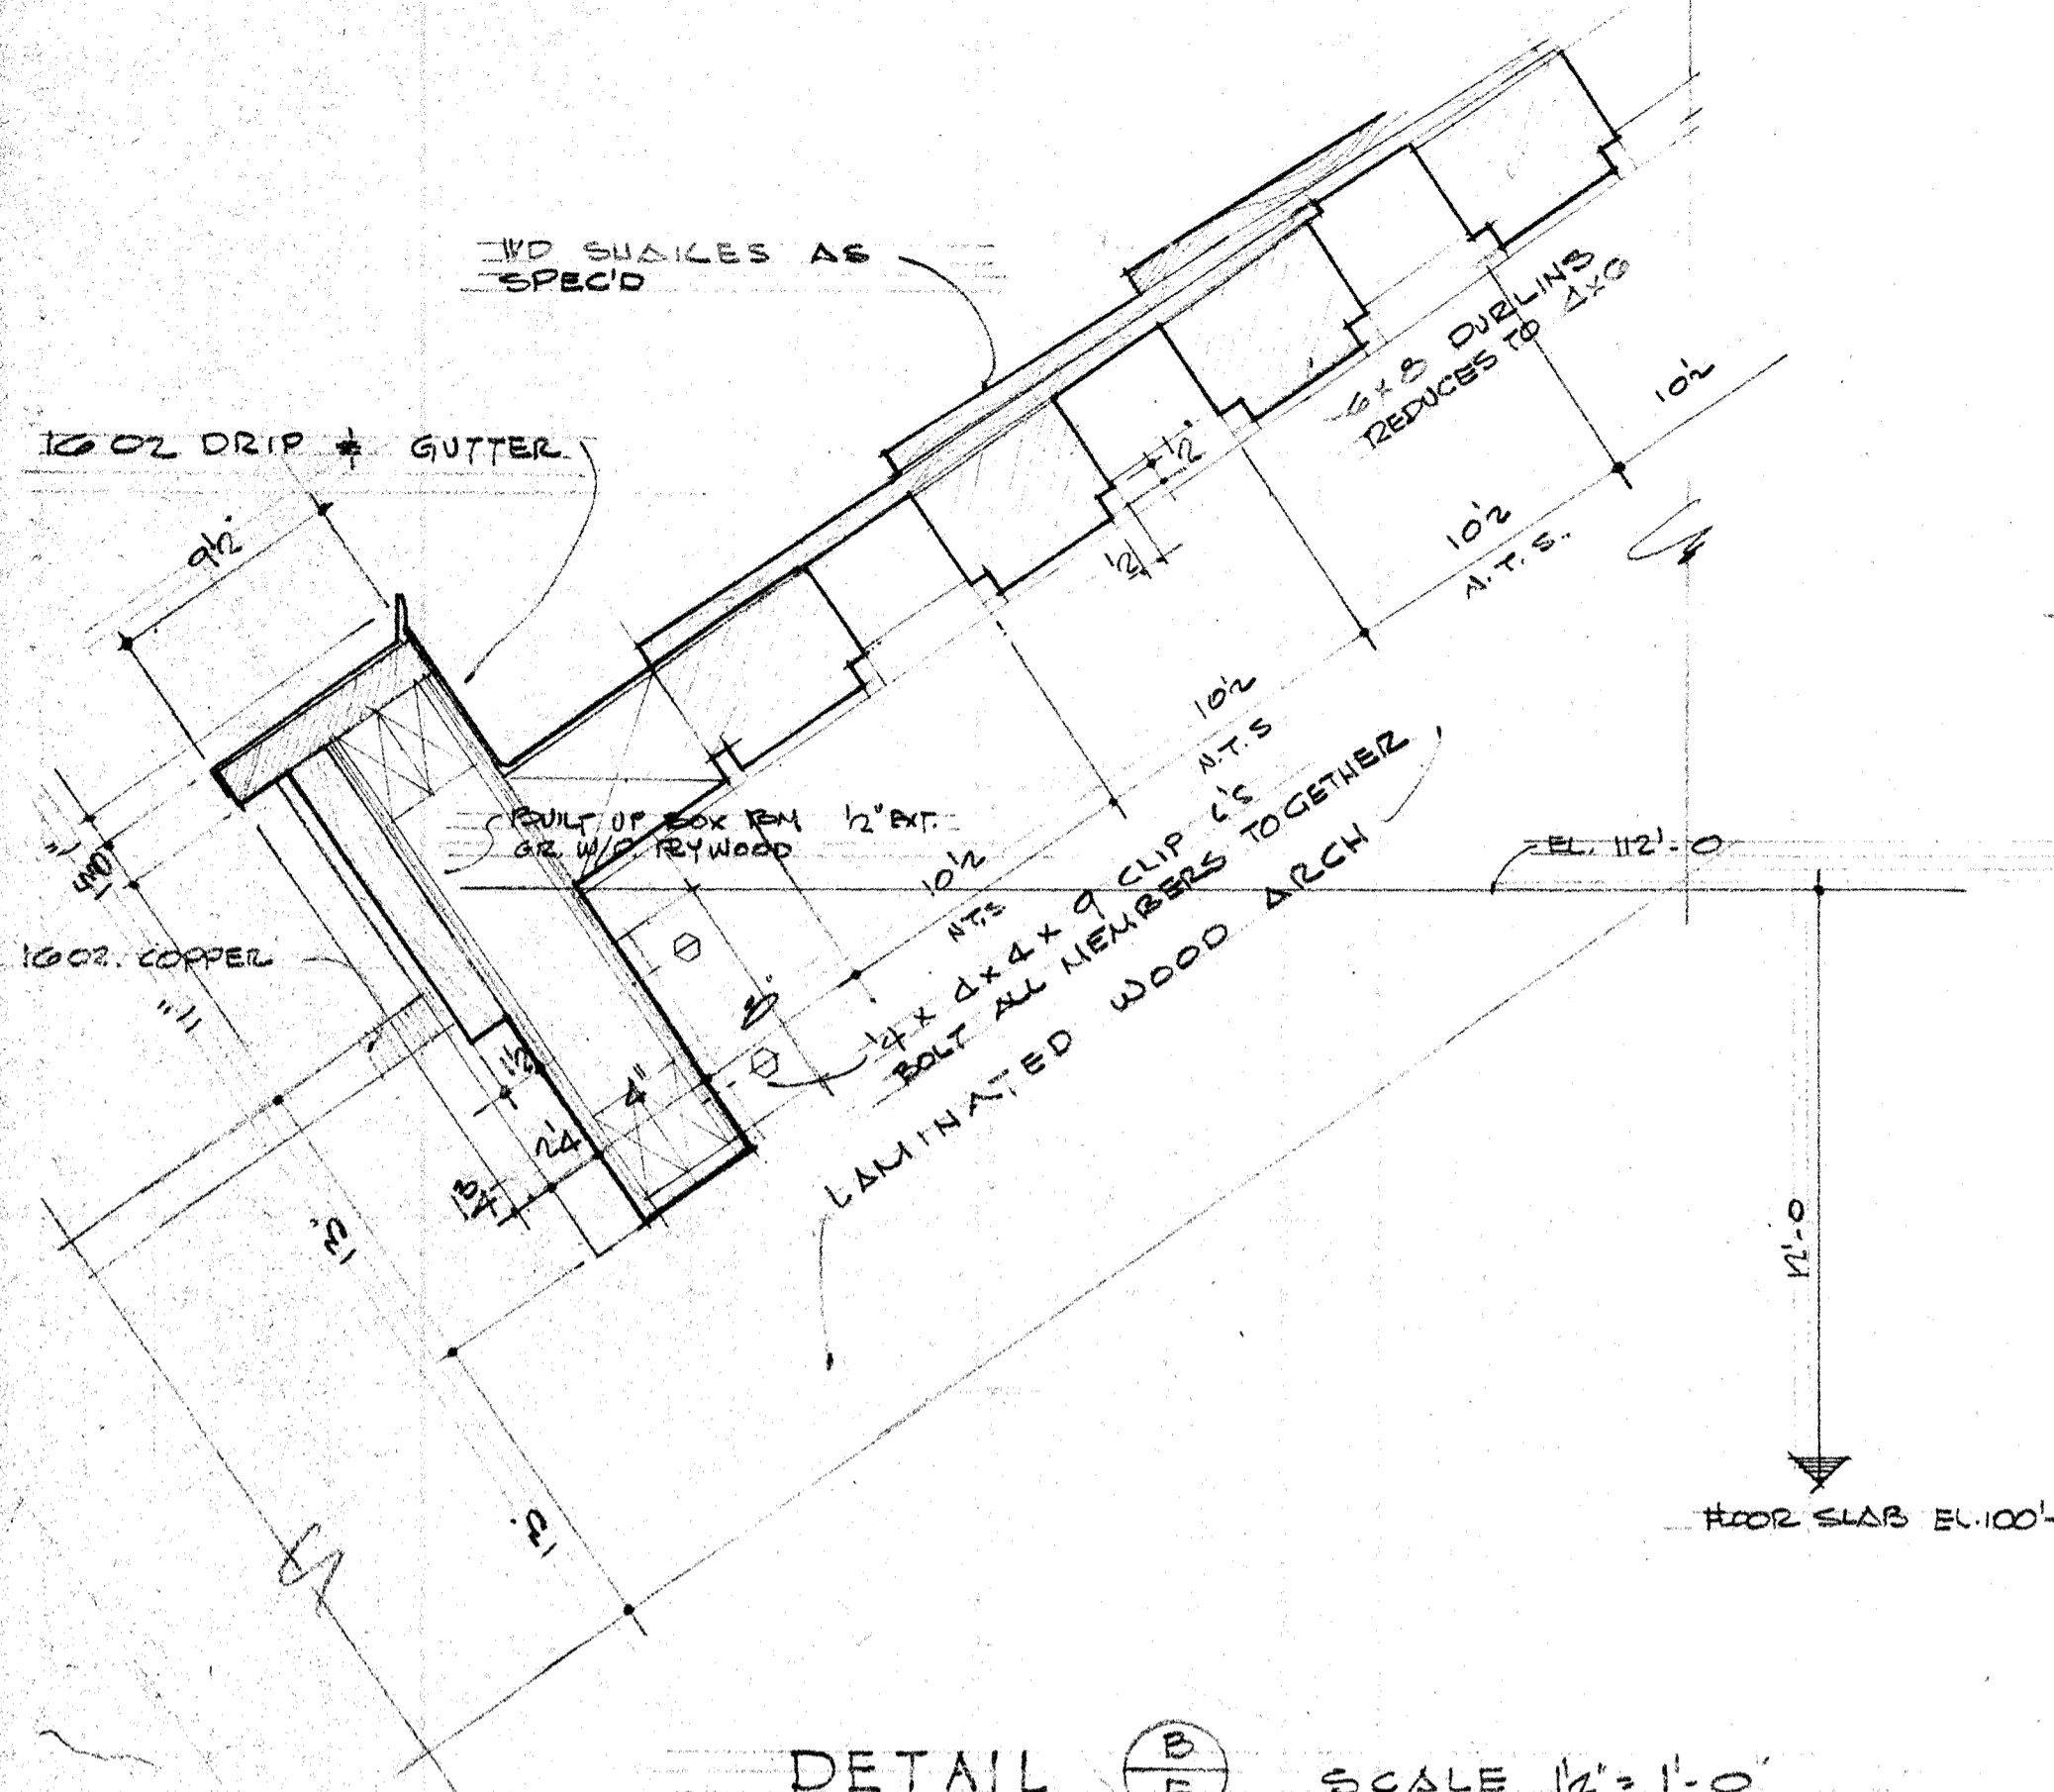


DETAIL B / 5 SCALE 1/2" = 1'-0"

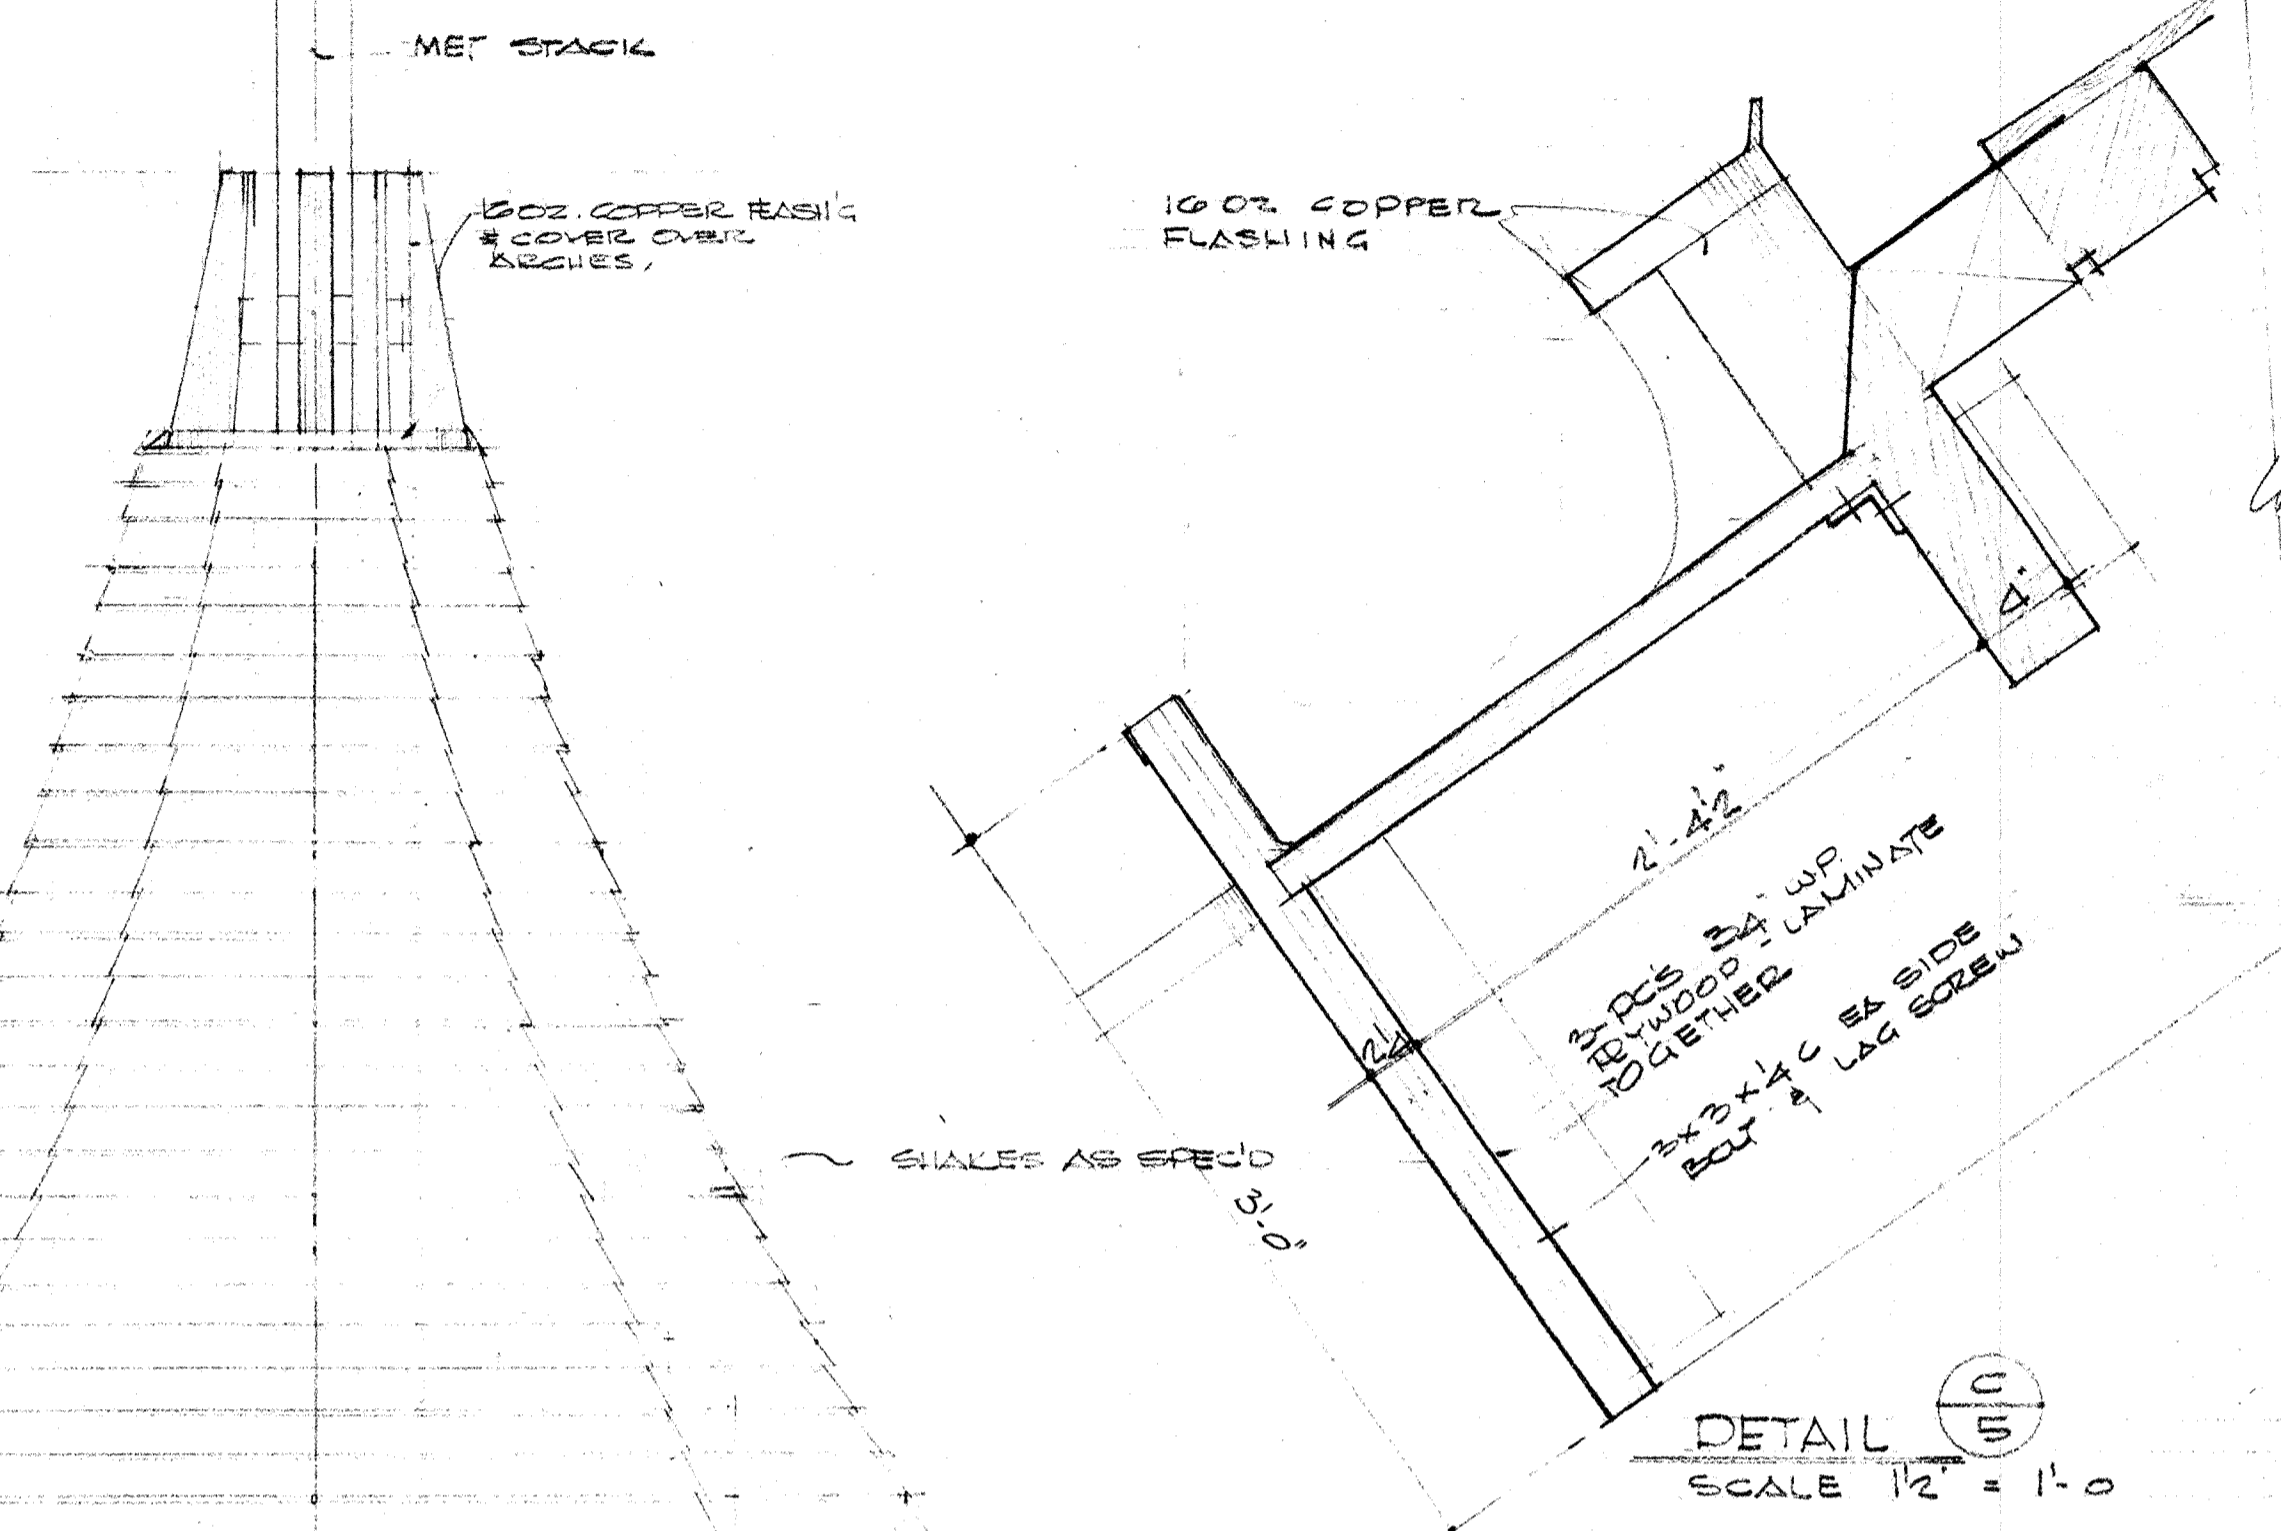

DETAIL C / 5 SCALE 1/2" = 1'-0"

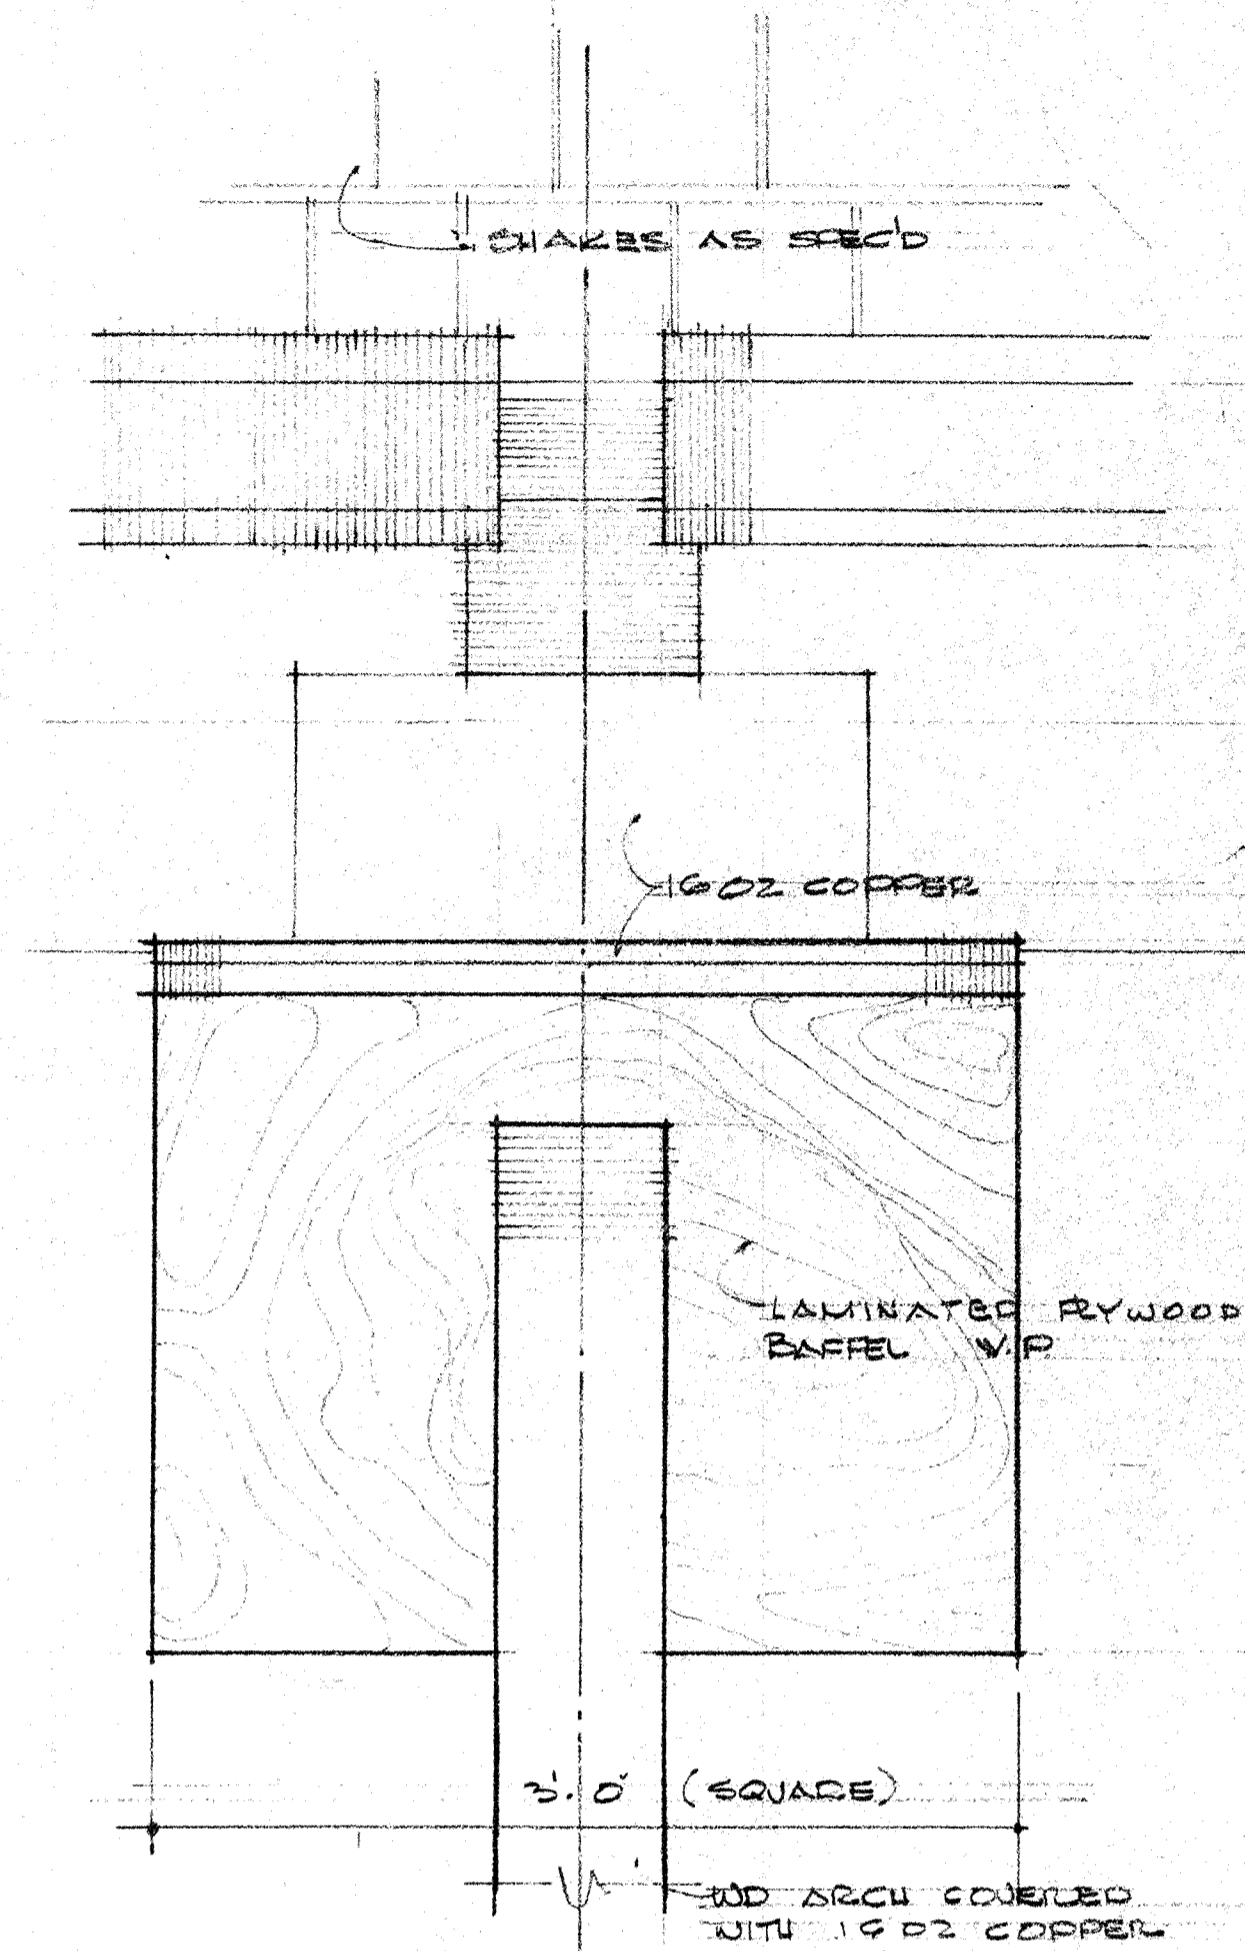


DETAIL D / 5 SCALE 1/2" = 1'-0"

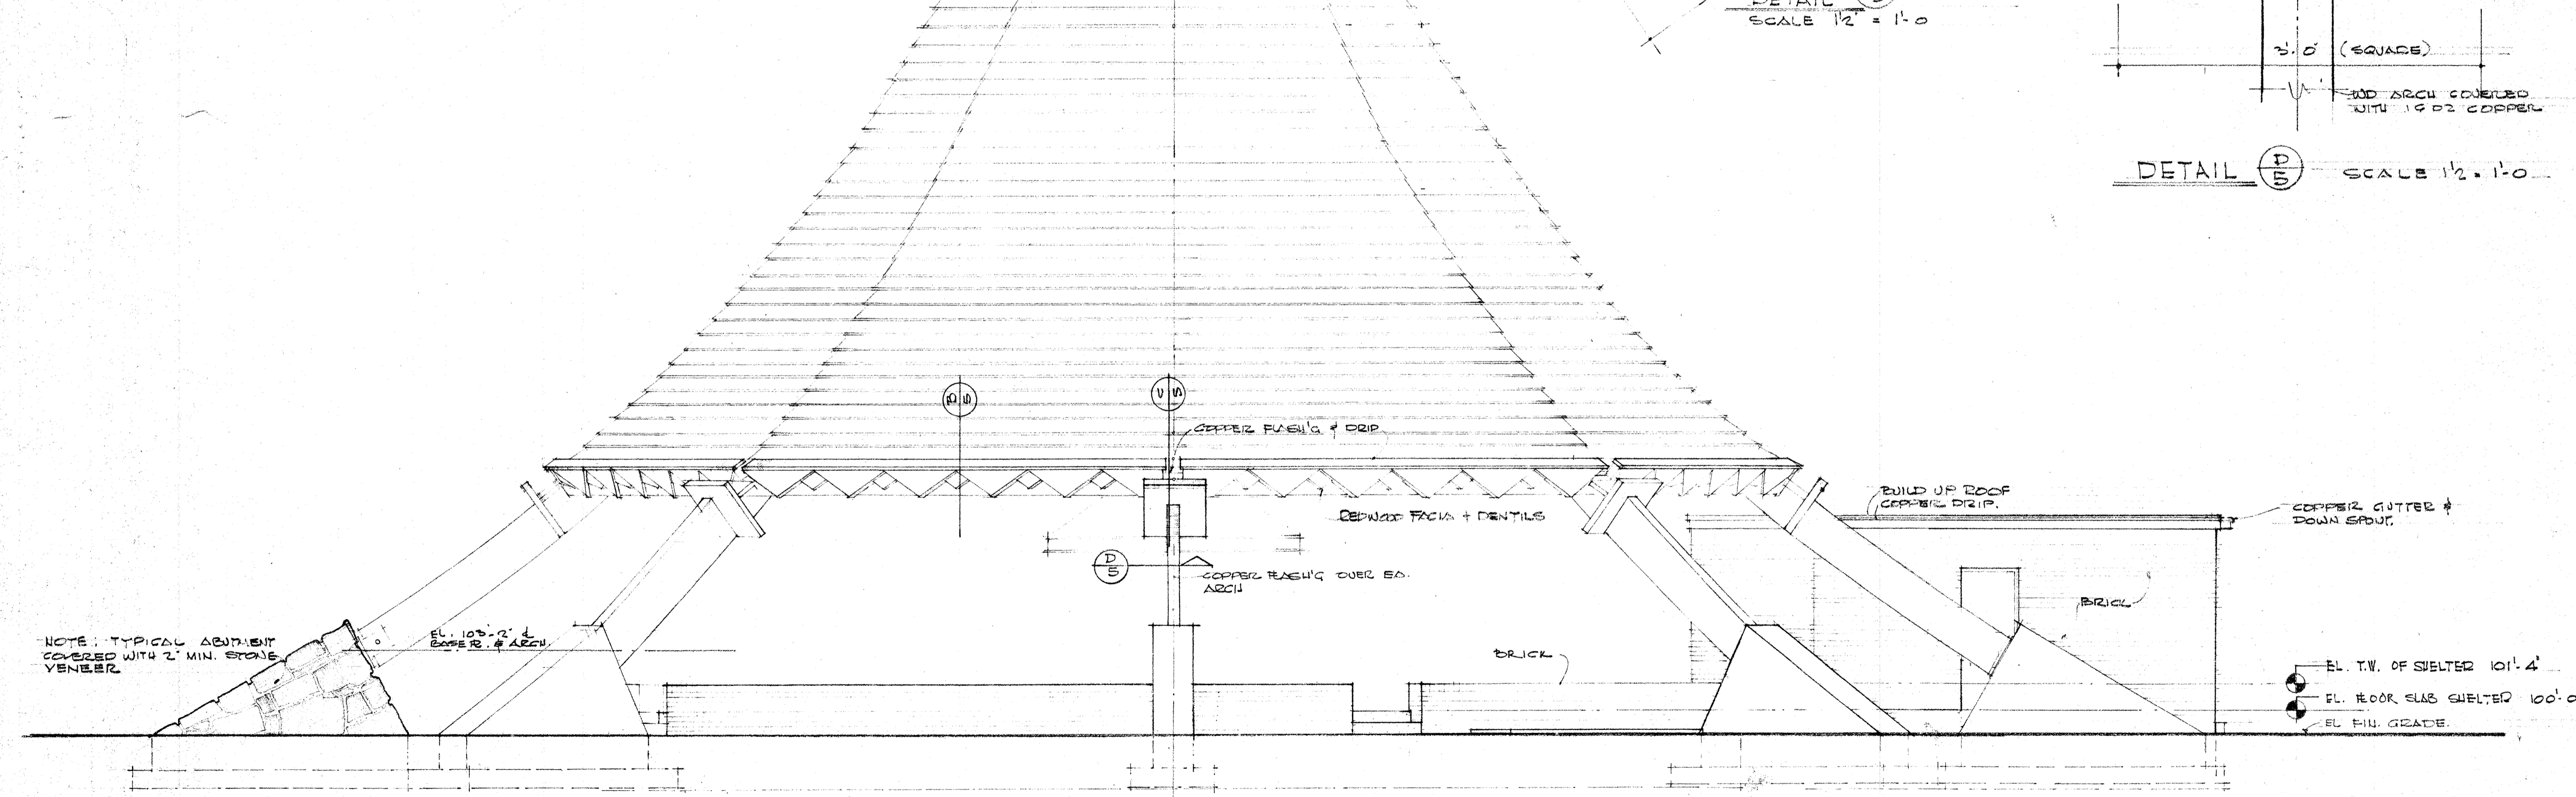



NOTE: TYPICAL ABUTMENT COVERED WITH 2\"/>

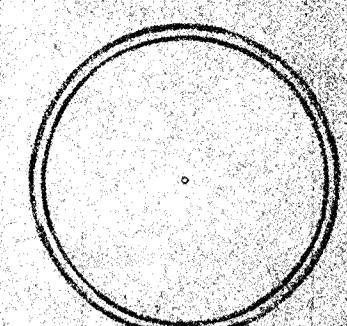ELEVATION A/5  
SCALE 1/4" = 1'-0"




**A NEW SHELTER HOUSE & COMFORT STATION**  
FOR THE DEPARTMENT OF PARKS & RECREATION  
CITY OF LOUISVILLE, KENTUCKY  
**HOGANS FOUNTAIN IN CHEROKEE PARK**


SHEET NO.  
**5**  
OF 9

DATE 2 JAN '06  
DWG. G.N.


**TAYLOR & SCHICKLI**  
ARCHITECTS & ENGINEERS  
310 WEST LIBERTY  
LOUISVILLE 2, KY.

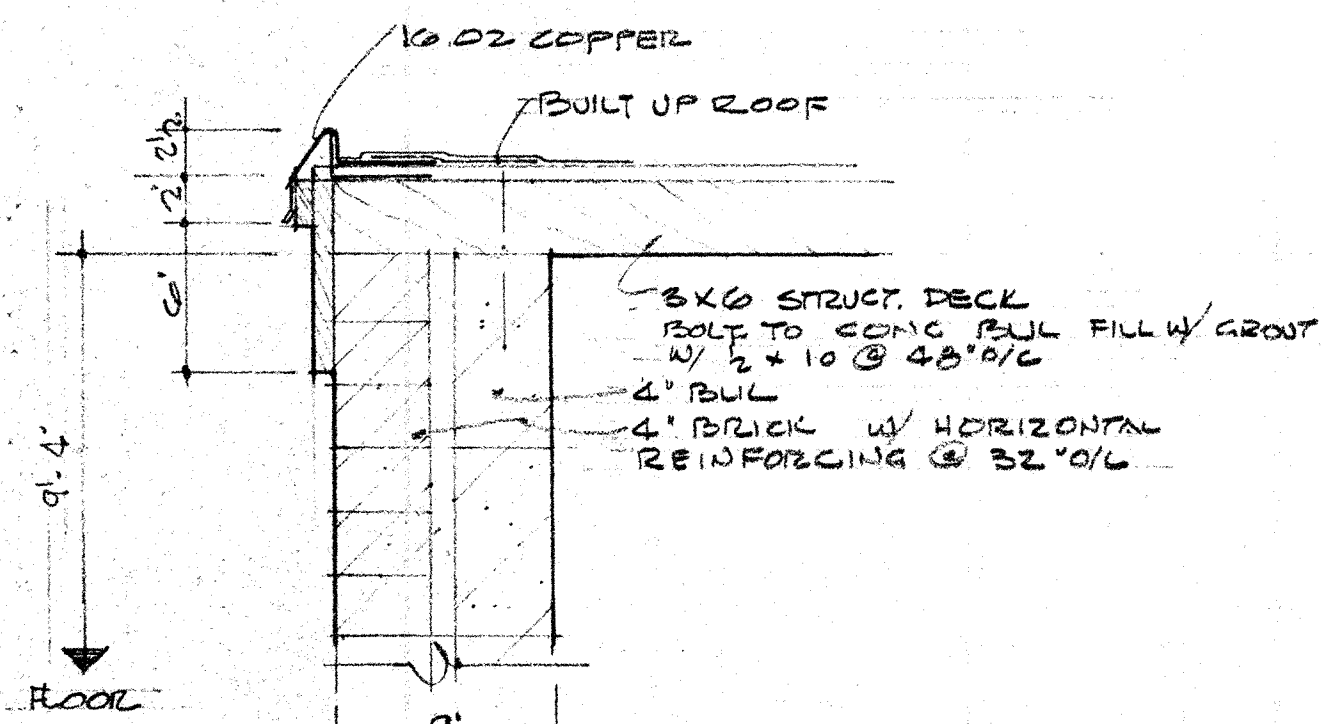


DETAIL A/6  
 SIMILAR FOR GUTTER DETAIL  
 CONDITION PROVIDE STD BOX GUTTER  
 # 4x6 D.S. OF COPPER  
 SCALE 1/2" = 1'-0"

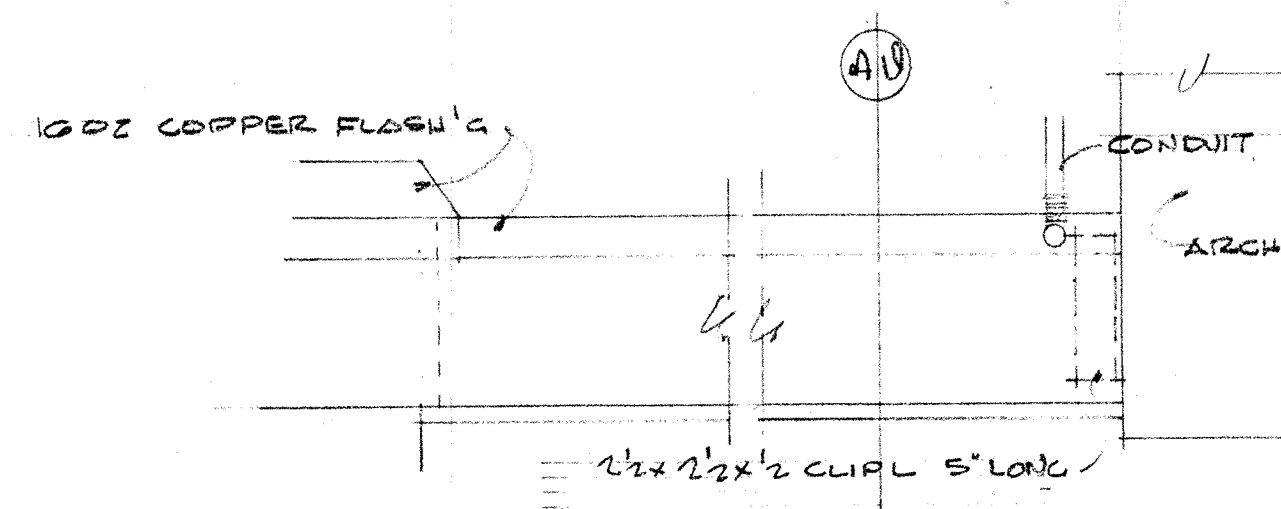

STRUT FROM TOILET ROOMS TO  
 ARCHES. (2 REQ'D) SCALE 1/2" = 1'-0"

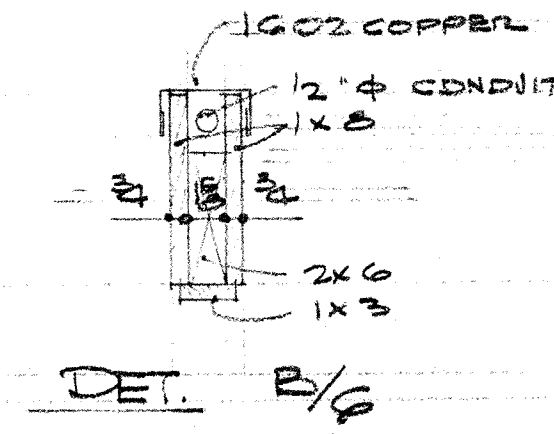


DETAIL B/6

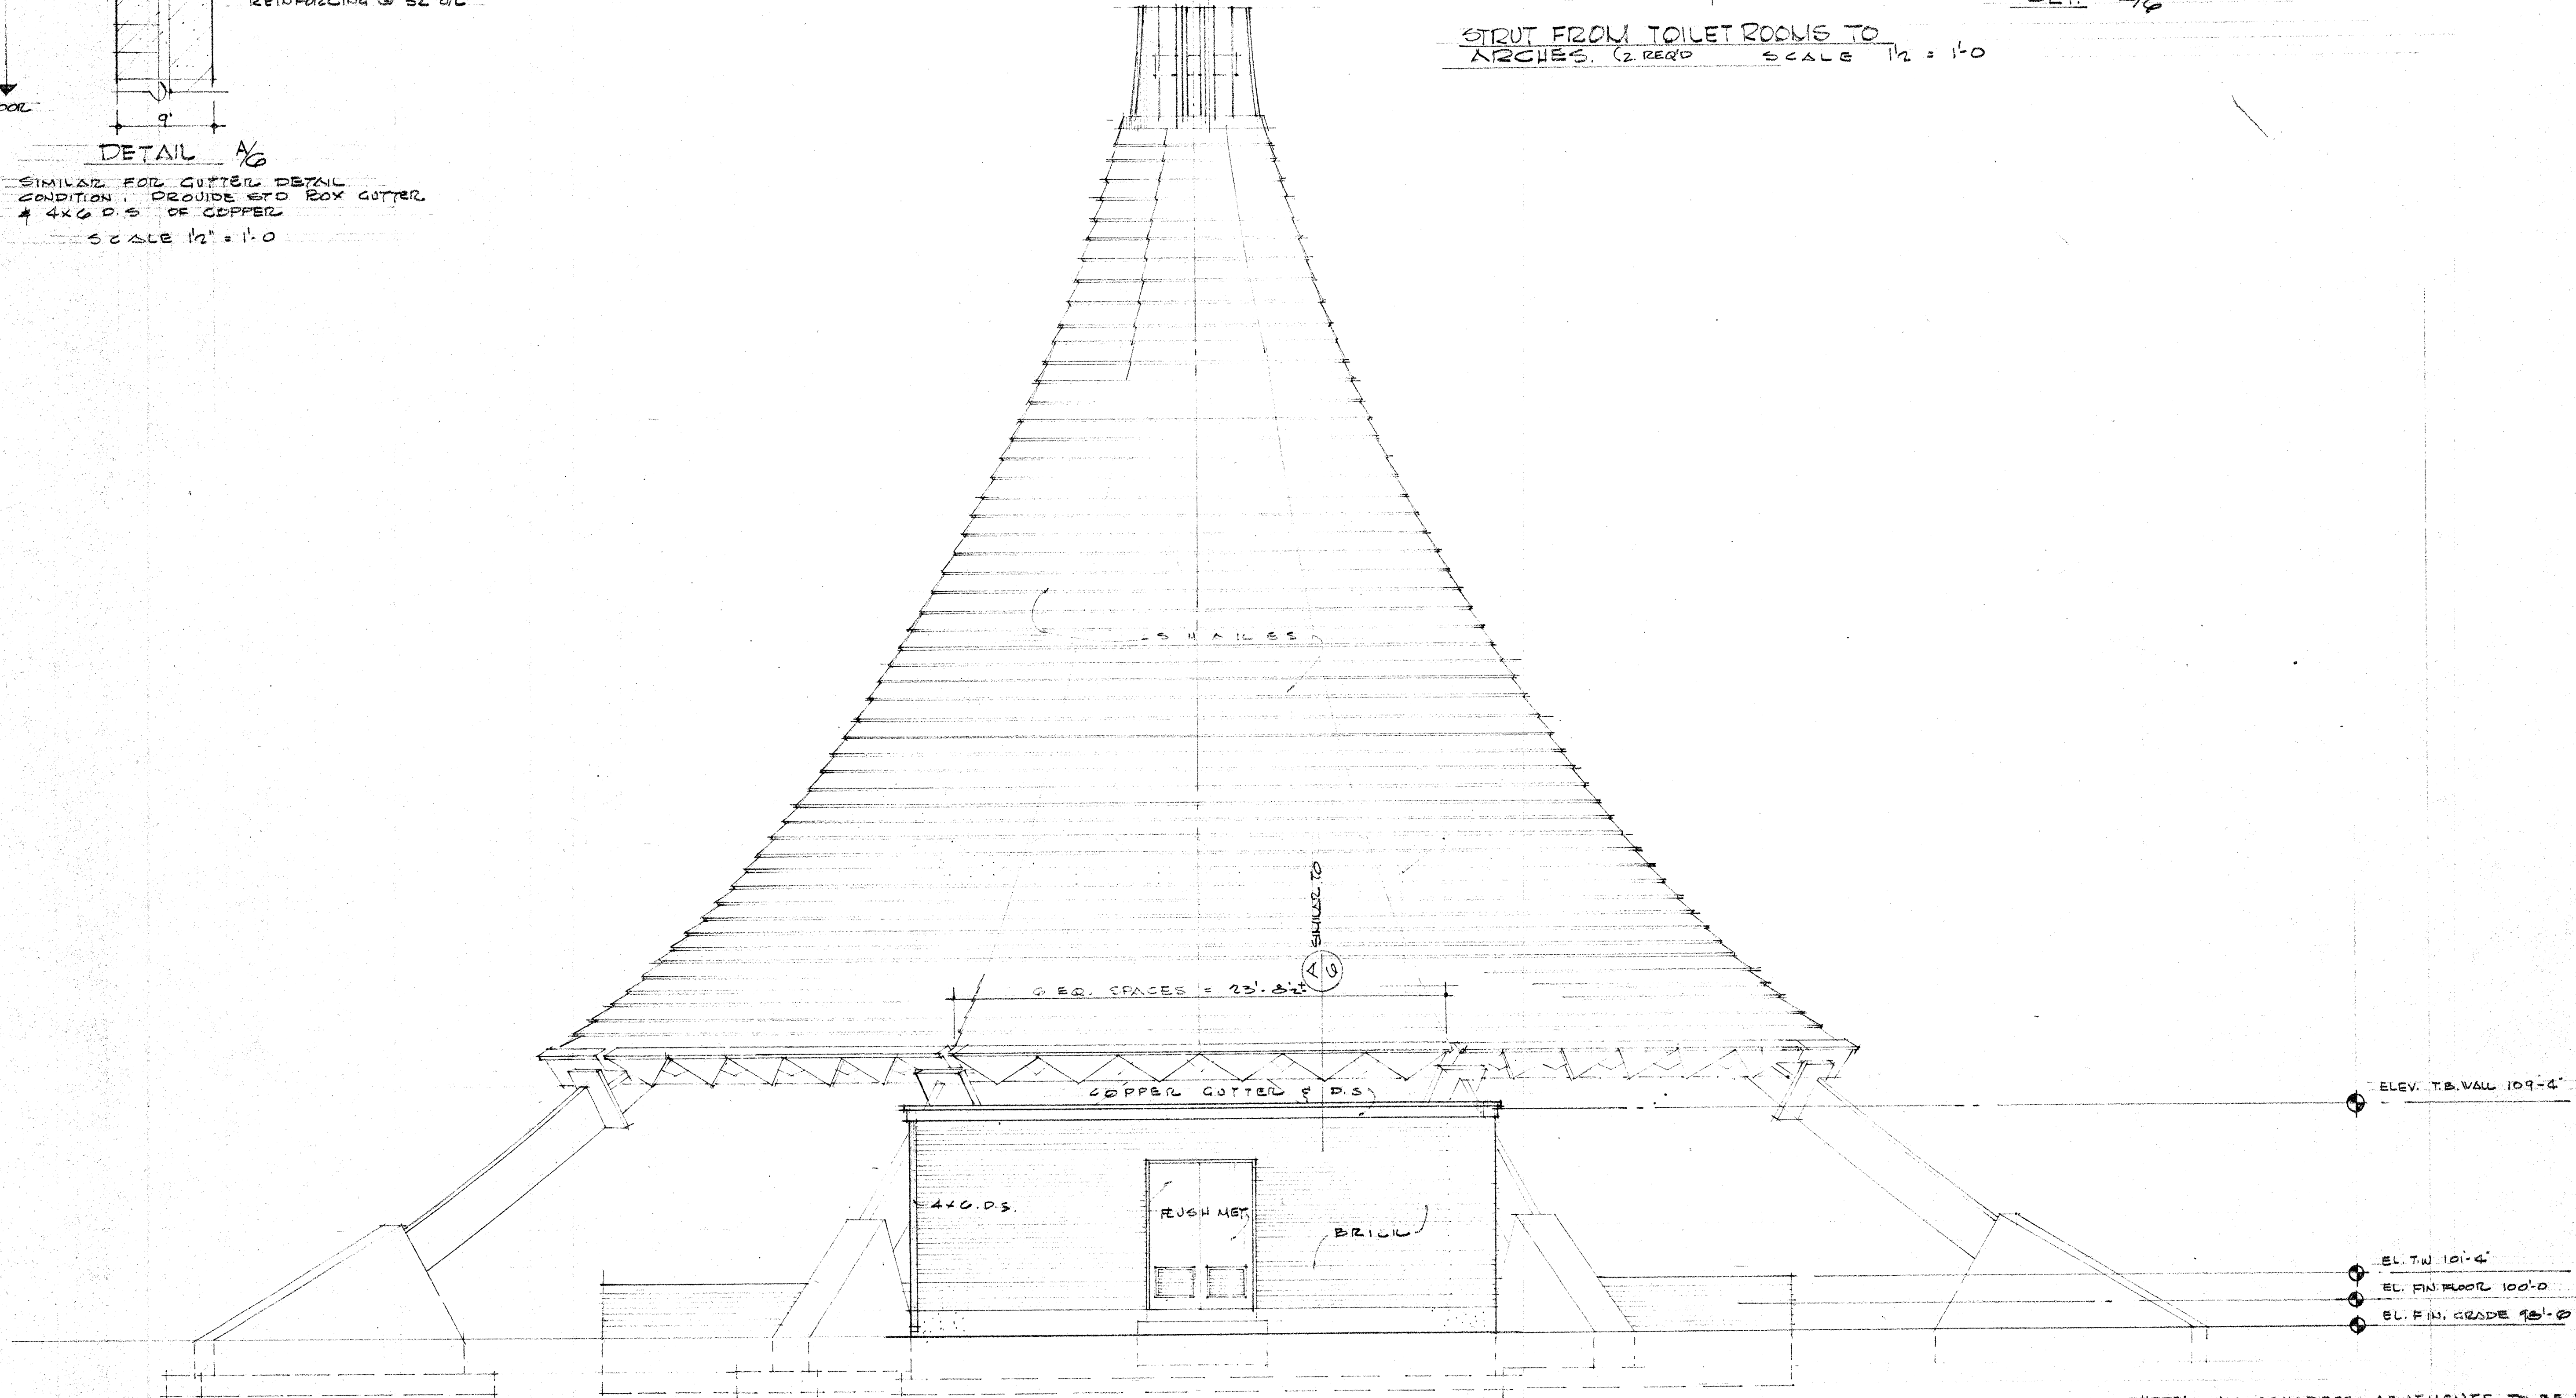


ELEVATION B/6 SCALE 1/4" = 1'-0"

- ELEV. T.B. WALL 109'-4"
- EL. T.W. 101'-4"
- EL. FIN. FLOOR 100'-0"
- EL. FIN. GRADE 98'-0"

NOTE: ALL CONCRETE ABUTMENTS TO BE VENEERED  
 W/ 2" MINIMUM STONE SEE S.D.S.  
 COVER TOP EDGE OF ARCH WITH 1602 COPPER

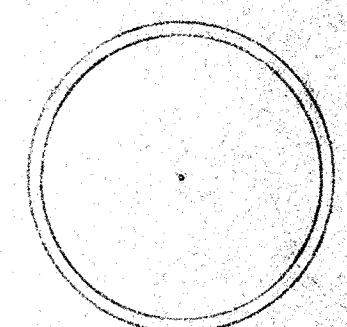



A NEW SHELTER HOUSE & COMFORT STATION  
 FOR THE DEPARTMENT OF PARKS & RECREATION  
 CITY OF LOUISVILLE, LOUISVILLE, KENTUCKY  
 HOGANS FOUNTAIN AT CHEROKEE PARK

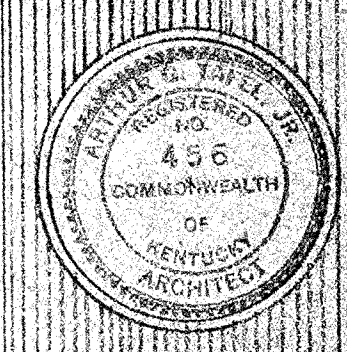

SHEET NO.  
 6  
 OF 9

DATE: JUN 2, 1966  
 DWG: G.N.

MEMBER OF THE  
 AMERICAN INSTITUTE OF ARCHITECTS  
 TAFEL & SCHICKL  
 ARCHITECTS  
 & ENGINEER  
 310 WEST LIBERTY  
 LOUISVILLE 2, KY

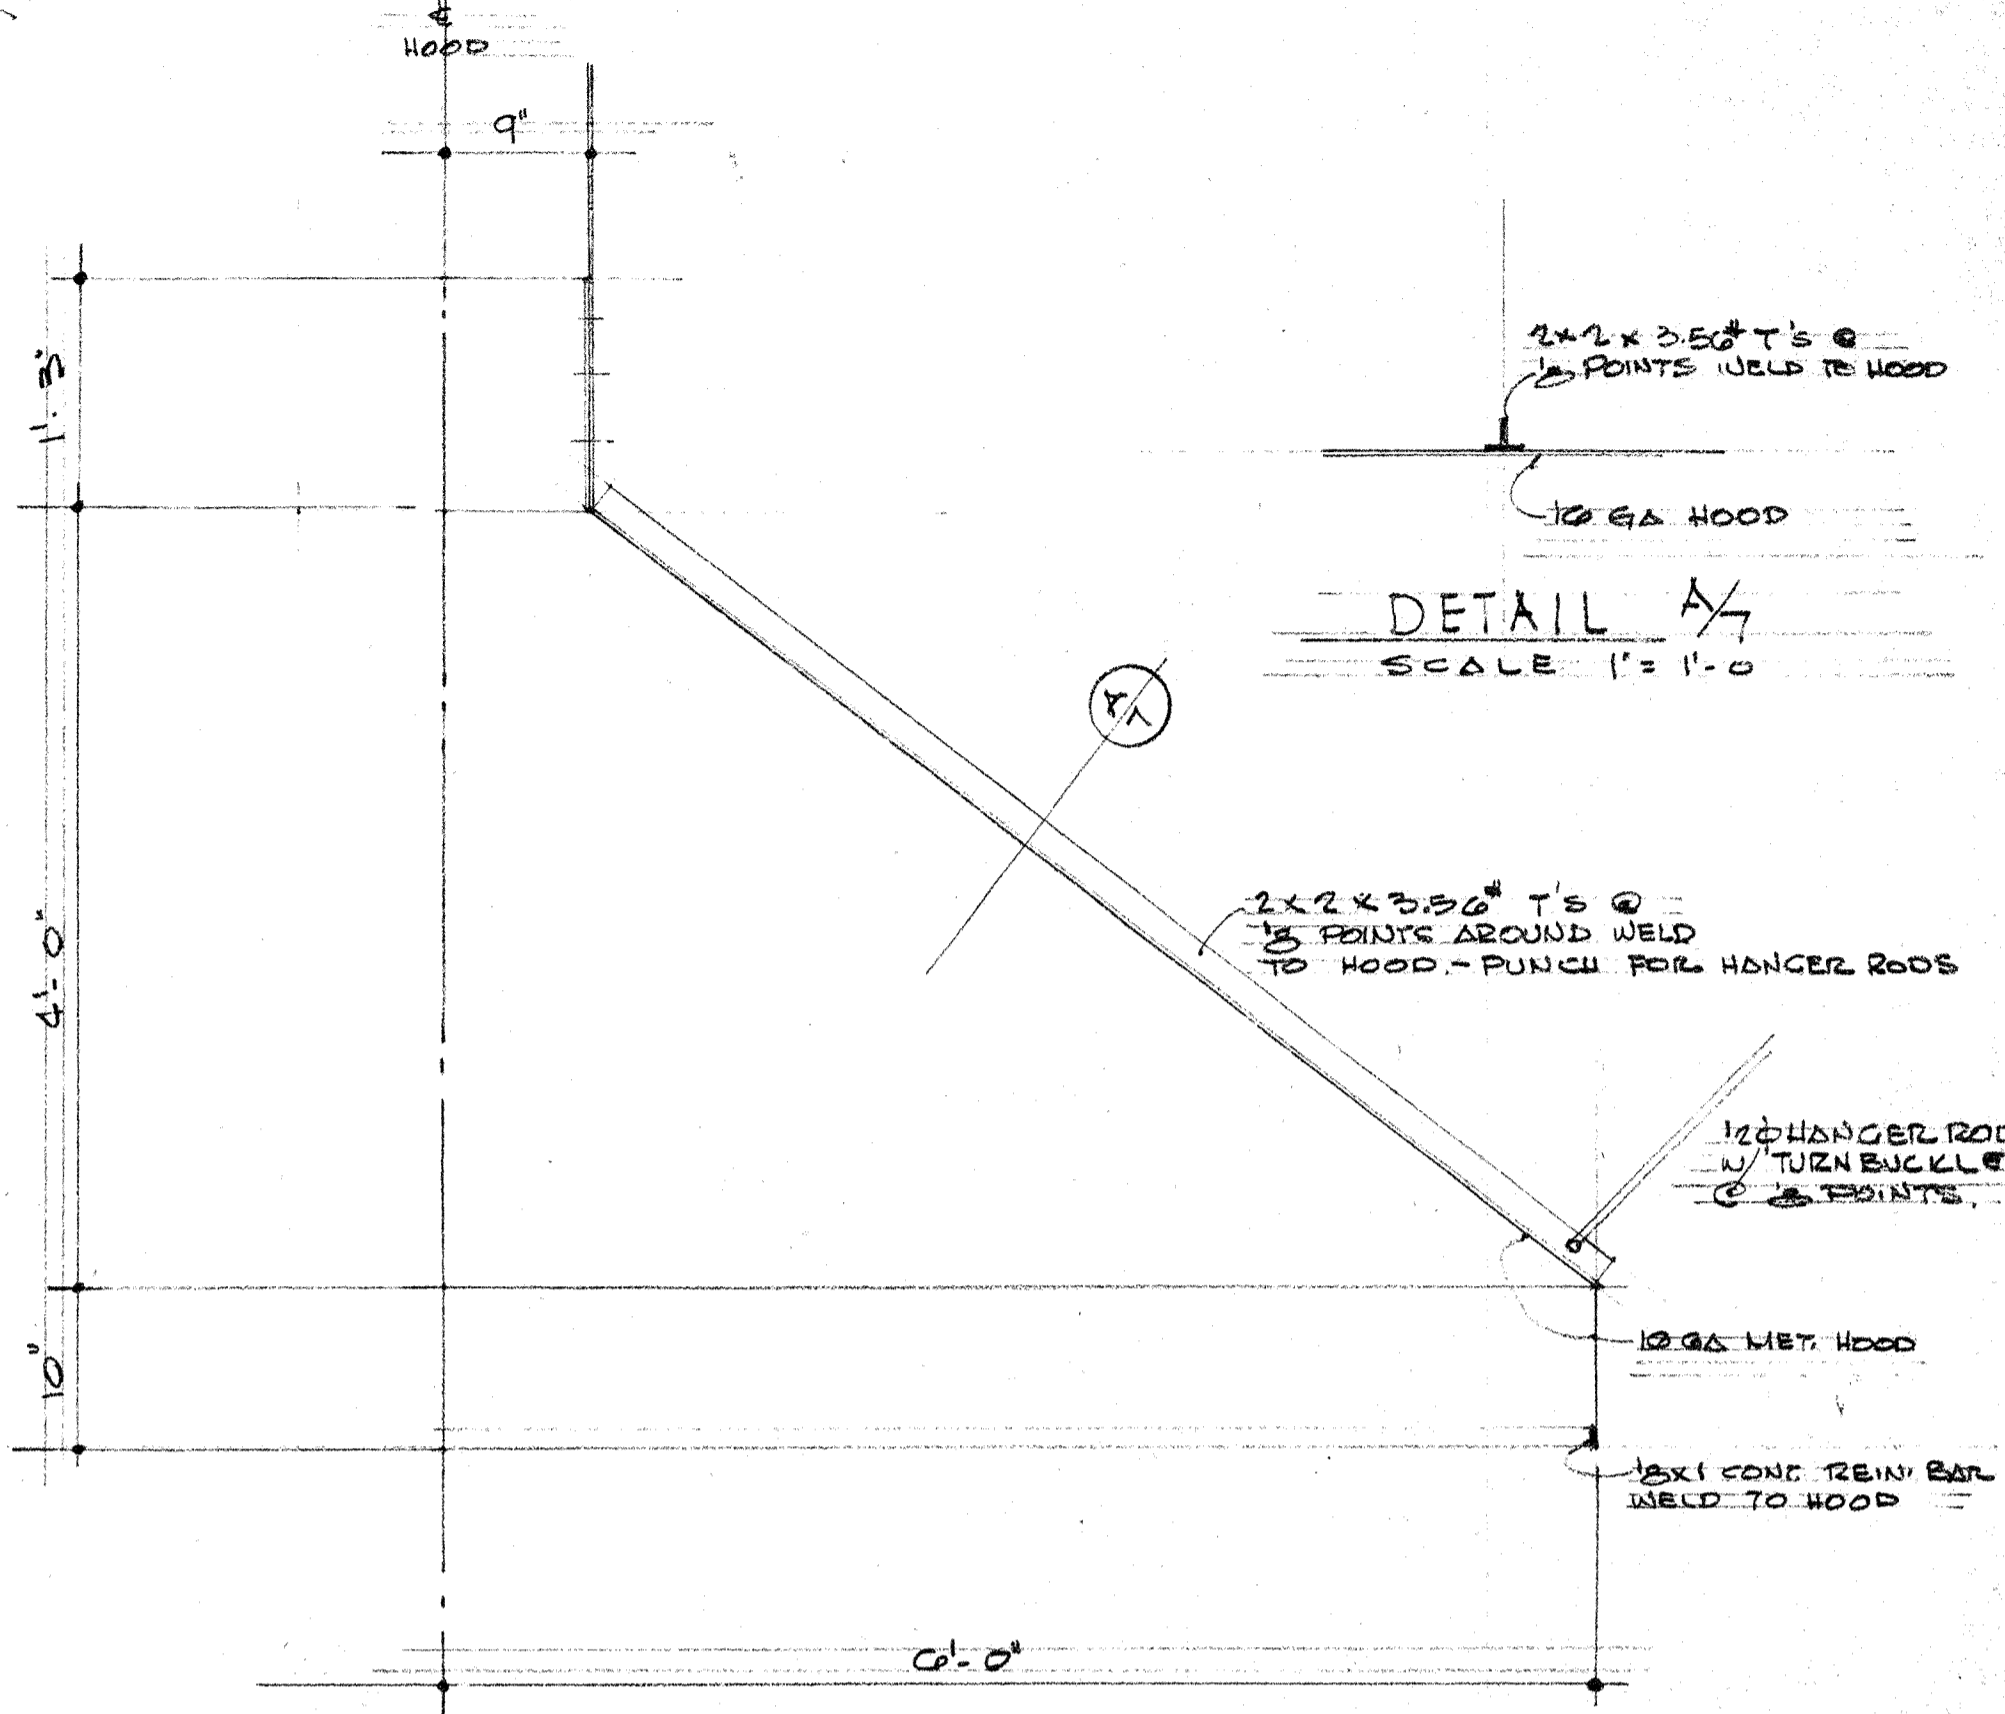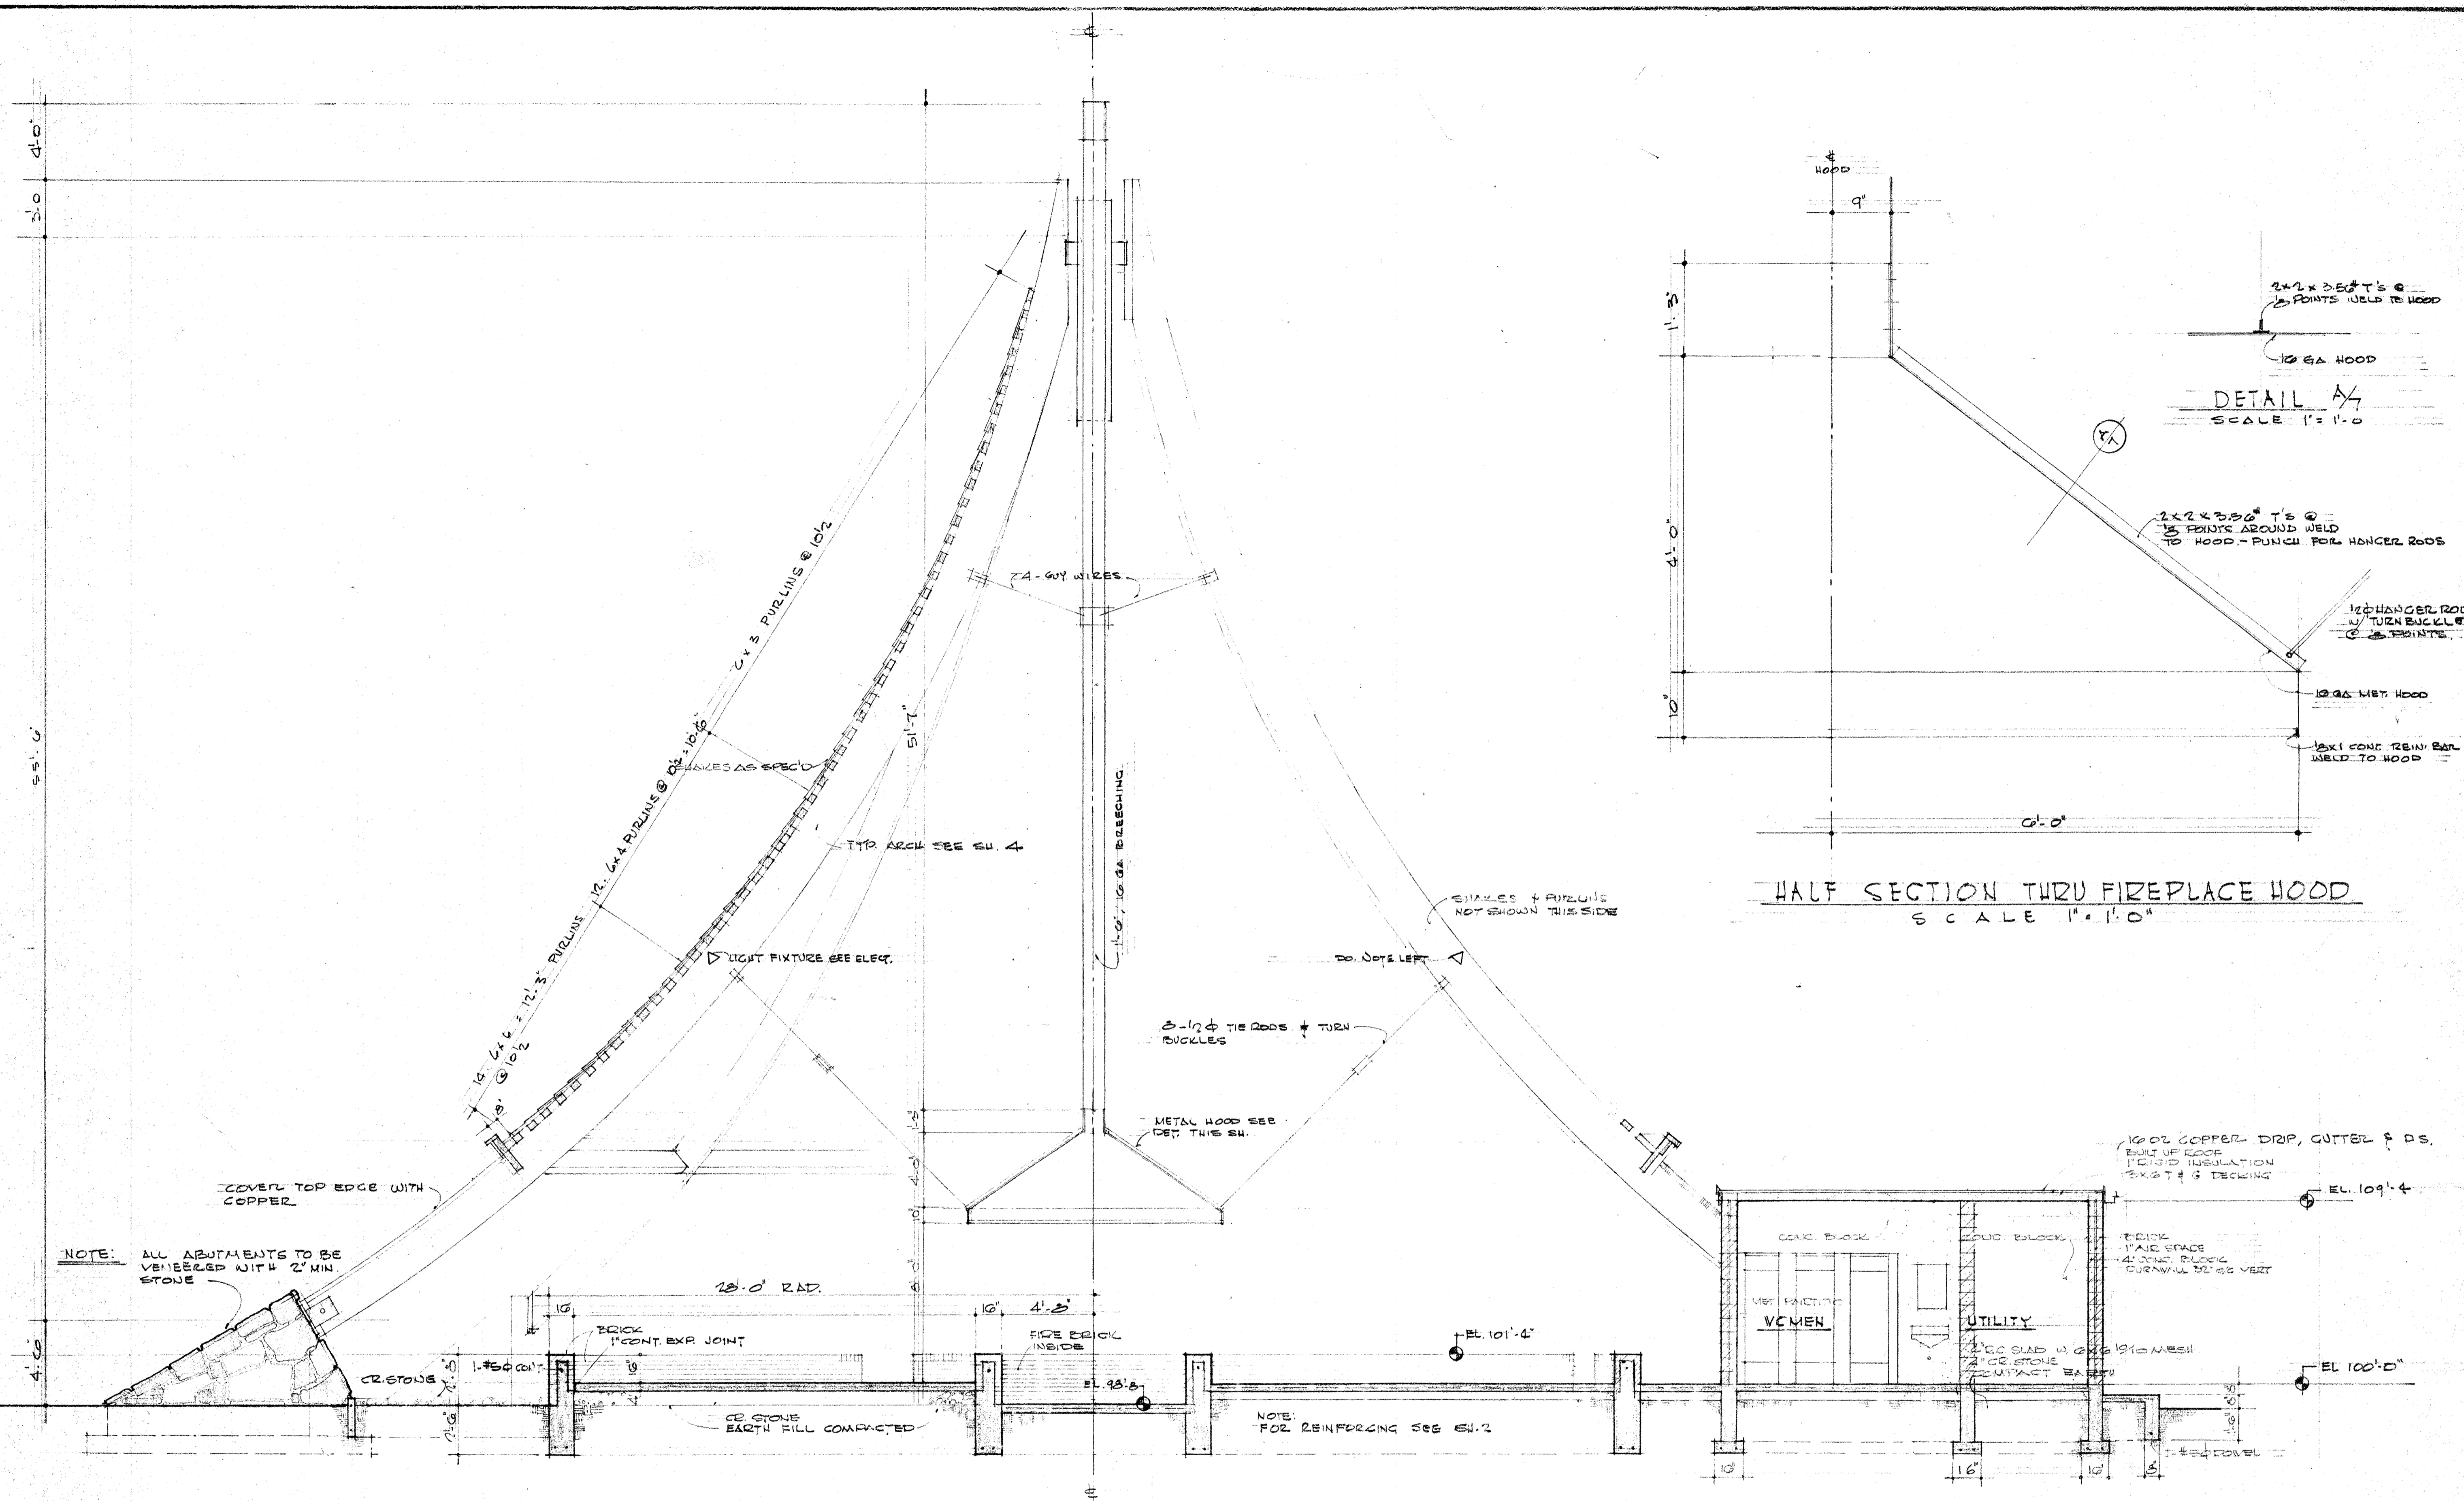

HALF SECTION THRU FIREPLACE HOOD  
SCALE 1" = 1'-0"

LONGITUDINAL SECTION A/7 - A/7  
SCALE 1/4" = 1'-0"

NOTE: ALL ABUTMENTS TO BE VENEERED WITH 2" MIN. STONE

COVER TOP EDGE WITH COPPER

12. 6x4 x 12'-3" PURLINS @ 12'-0" O.C.  
12. 6x4 x 12'-3" PURLINS @ 12'-0" O.C.  
12. 6x4 x 12'-3" PURLINS @ 12'-0" O.C.

24 - 5/16" WIRE

1.0" 10 GA BRACING

CHANGES & PURCHASE NOT SHOWN THIS SIDE

DO NOTS LEFT

2-1/2" TIE RODS + TURN BUCKLES

METAL HOOD SEE DET. THIS SH.

18'-0" RAD.

BRICK 1" CONT. EXP. JOINT

FIRE BRICK INSIDE

CR. STONE

CR. STONE EARTH FILL COMPACTED

NOTE: FOR REINFORCING SEE SH. 2

CONC. BLOCK

CONC. BLOCK

VENT. PRACTICE

WC MEN

UTILITY

1" CONC. SLAB w/ 2# 10# MESH

1" CR. STONE

1" COMPACT EARTH

100# COPPER DRIP, GUTTER & DS. BUILD UP EDGE. FIBER INSULATION. EXIST. 4" DECKING

EL. 109'-4"

EL. 100'-0"

A NEW SHELTER HOUSE & COMFORT STATION  
 FOR THE DEPARTMENT OF PARKS & RECREATION  
 CITY OF LOUISVILLE, LOUISVILLE, KENTUCKY  
 HOGANS FOUNTAIN AT CHEROKEE PARK

SHEET NO. 7 OF 9

DATE: 2 JAN 67  
 DWS: G.R.


MEMBER OF THE AMERICAN INSTITUTE OF ARCHITECTS  
 TAFEL SCHICKEL ARCHITECTS & ENGINEERS  
 310 WEST LEXINGTON  
 LOUISVILLE, KY

PANEL "A" SCHEDULE					
CIRC. No	WATTS OR FLA	BRKR SIZE	WIRE SIZE	POLES	EQUIPMENT SERVED
1	200W	20A	#12	1	LIGHTING
2	600W	20A	#12	1	LIGHTING
3	600W	20A	#12	1	LIGHTING
4	17A	30A	#10	2	ELEC. HEATER
5	17A	30A	#10	2	ELEC. HEATER
6					
7					
8	750W	30A	10	2	ELEC. HEATER
9	400W	20A	#12	1	LIGHTING
10					
11		20A	#12	1	RECPT (2)
12		20A			SPARE
13		20A			SPARE
14		20A			SPARE
15#16		20A			SPARE

WESTINGHOUSE NLAB-16 SURFACE MOUNT  
 115/230 VOLTS, 1 $\phi$ , 3 WIRE, 200 A. BUSS &  
 125 A. MAIN BREAKER

FIXTURE SCHEDULE	
A	STONCO CLD-1500 ADJUSTABLE SOCKET ON 2-B BASE 150 WATT PAR-38 SPOT OR FLOOD AS DETERMINED ON JOB. PROVIDE WITH B-1550 WIRE GUARD, MOUNT 22" O AFF
B	GUTH B-1334/TP RECESSED NIGHT LIGHT IN EXTERIOR WALL 6" O AFF WITH TAMPER PROOF SCREWS, 100 WATT IF LAMP.
C	L & P #PC-150 SURFACE MOUNT, TAMPER PROOF WITH 2- 100 WATT IF LAMPS.
D	PORCELAIN RECEPTACLE LESS CHAIN WITH 100 WATT IF LAMP.

NOTE - ALL LIGHTS TO BE SWITCHED FROM PANEL EXCEPT IN UTILITY ROOM.

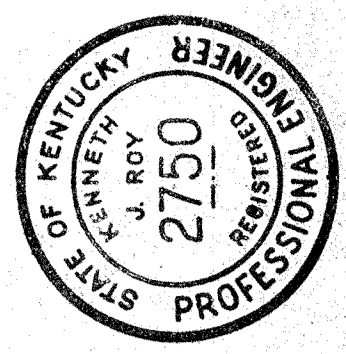


A NEW SHELTER HOUSE & COMFORT STATION  
 FOR THE DEPARTMENT OF PARKS & RECREATION  
 CITY OF LOUISVILLE LOUISVILLE KENTUCKY  
 HOGANS FOUNTAIN IN CHEROKEE PARK

KENNETH J. ROY, P.E.  
 ENGINEER  
 304 W. LIBERTY  
 LOUISVILLE  
 KENTUCKY


SHEET NO.  
 8  
 OF 9

DATE: 2- JAN 65  
 D.G.


AIA  
 TAFEL &  
 SCHICKLI  
 ARCHITECTS  
 & ENGINEER  
 310 WEST LIBERTY  
 LOUISVILLE 2, KY.

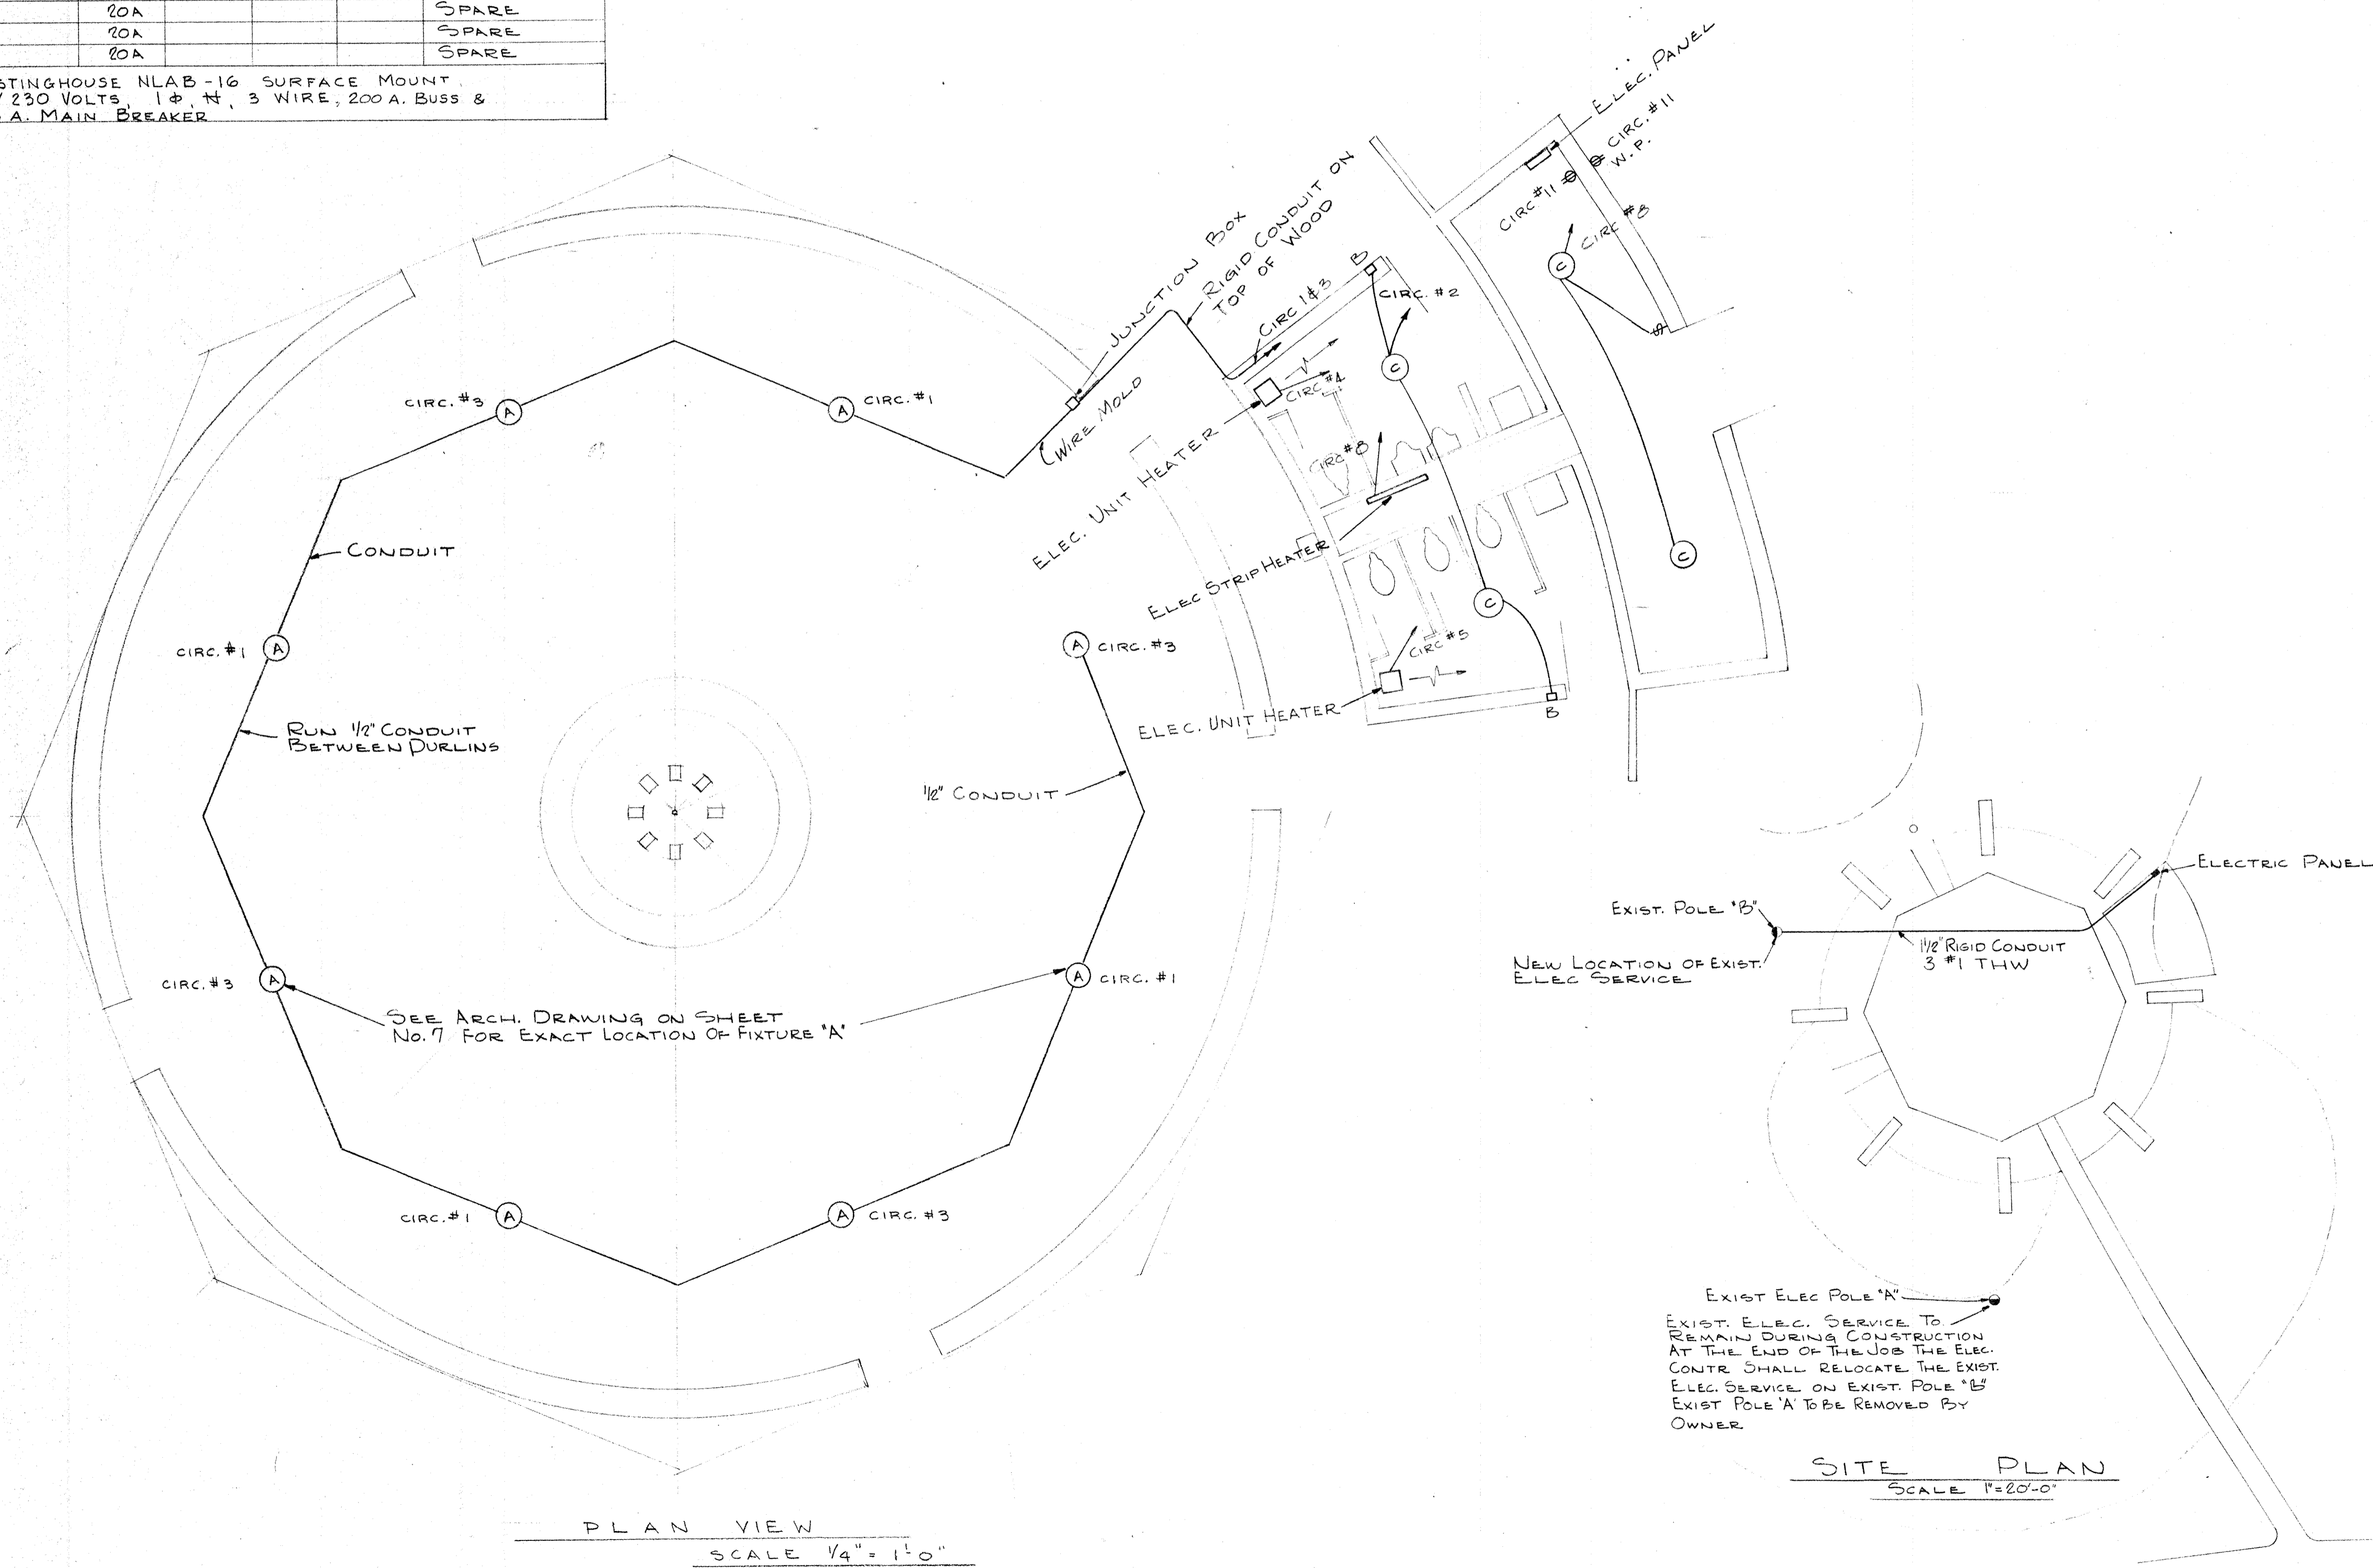



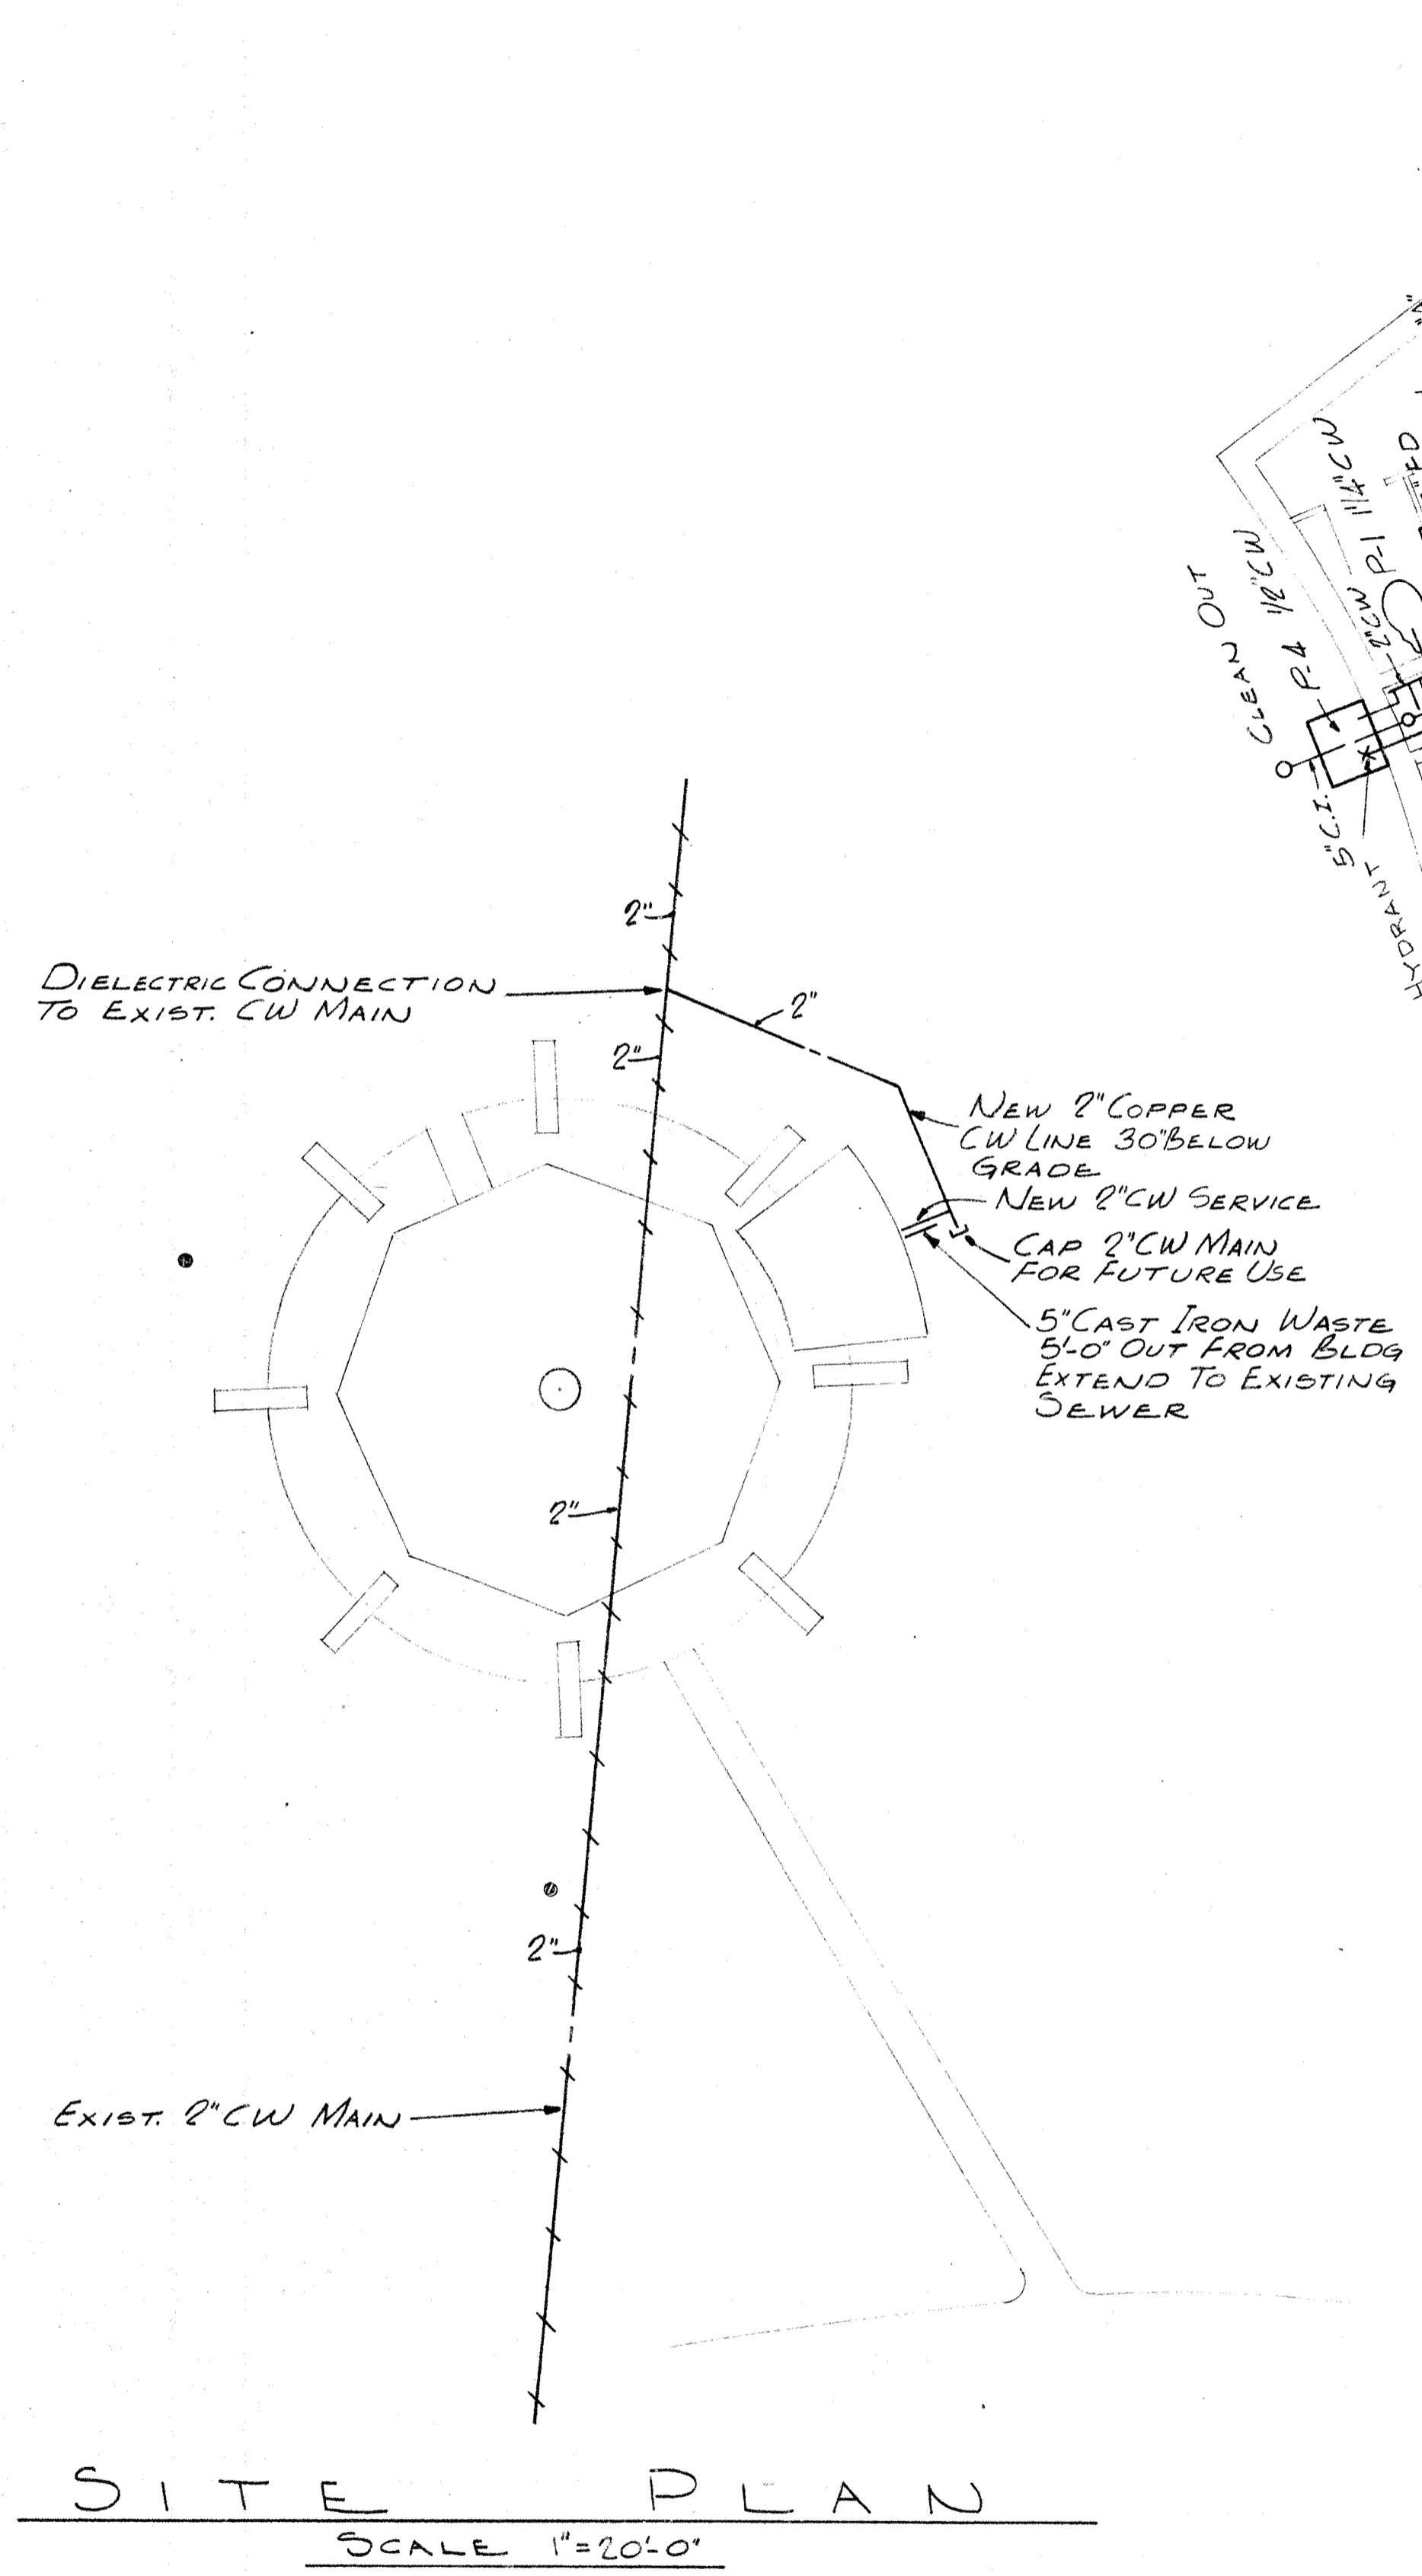


**SITE PLAN**  
 SCALE 1"=20'-0"

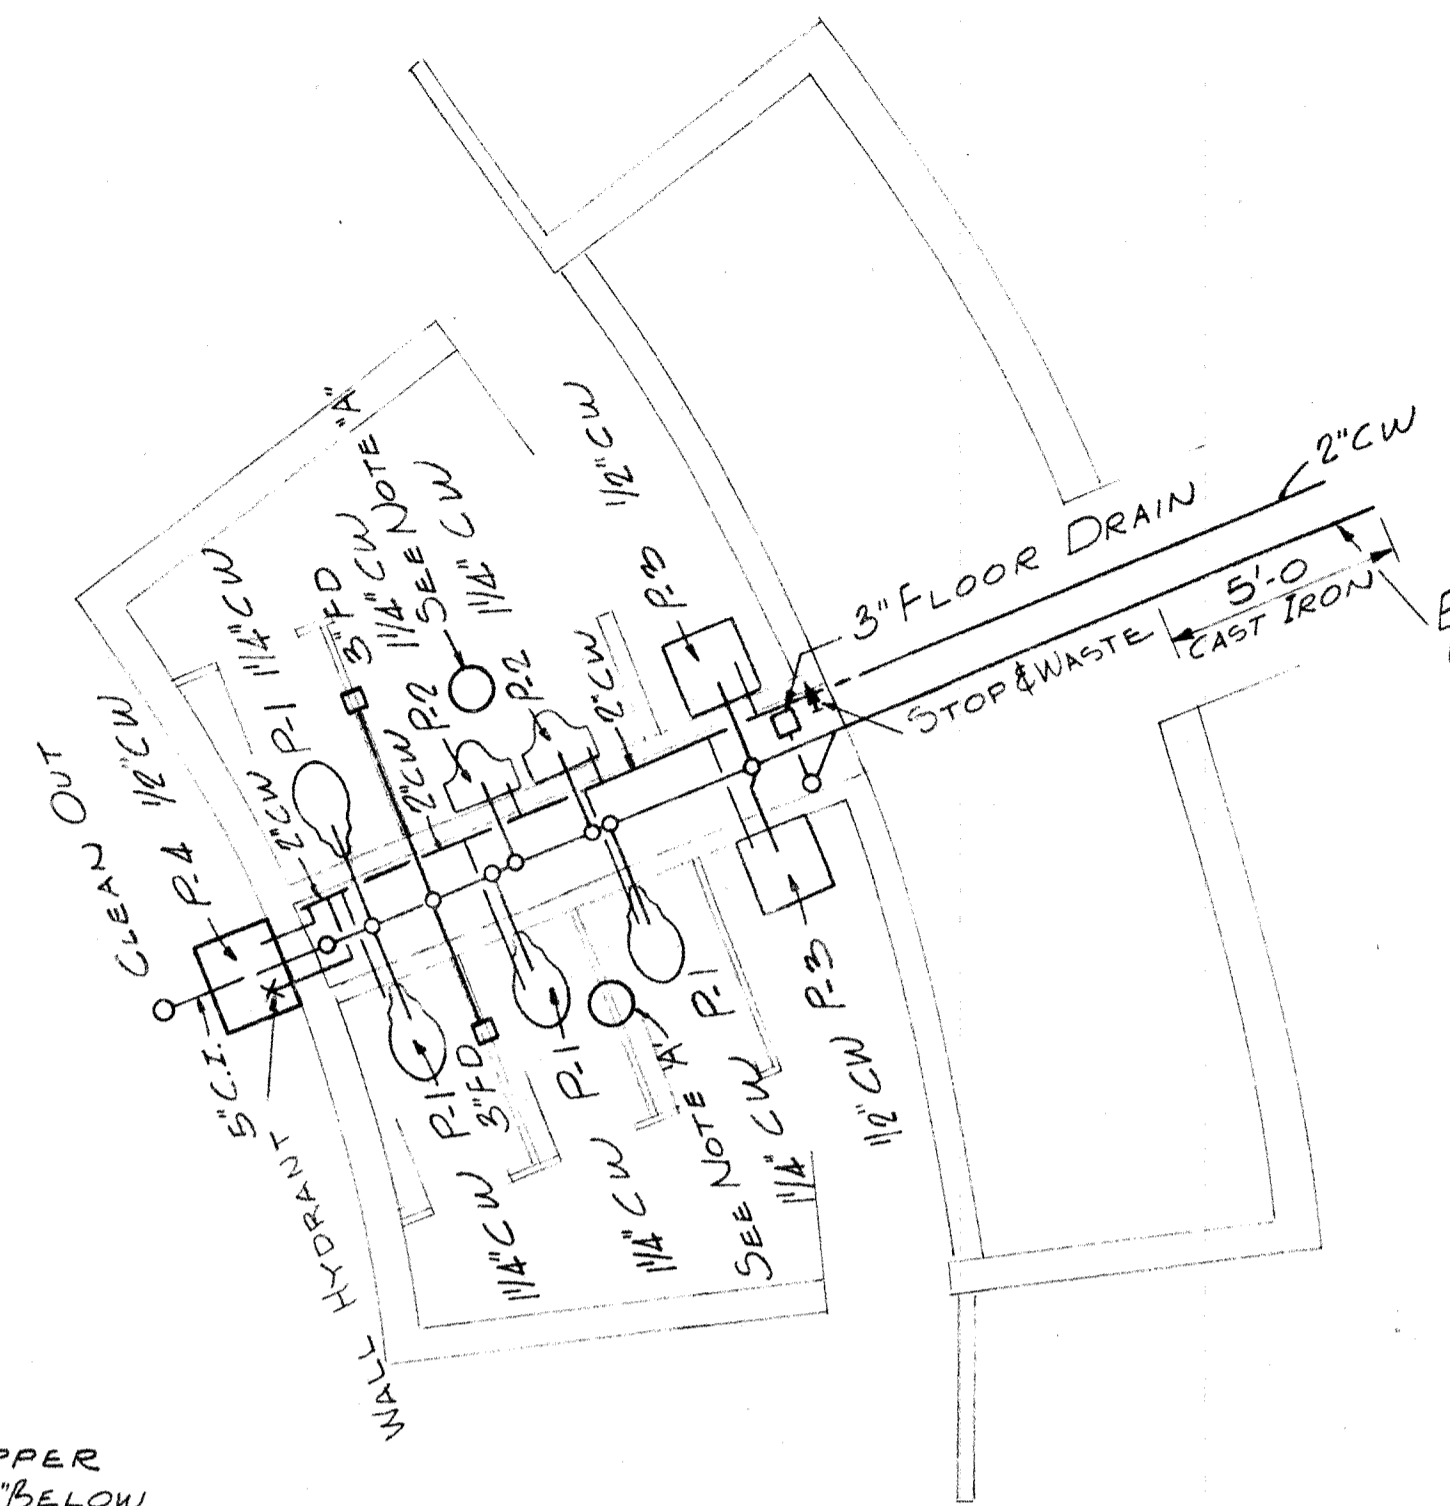

**PART FLOOR PLAN**  
 SCALE 1/4"=1'-0"

- NOTES**
- (A) 8" GRAVITY VENTILATOR PROVIDE BIRD SCREEN COMP. WITH H&C 8" CIG. DIFF. PRIME & PAINT WITH 2 COATS OF OUTSIDE ENAMEL
  - (B) ALL PIPING TO BE INSTALLED TO PROVIDE FOR COMP. DRAINAGE

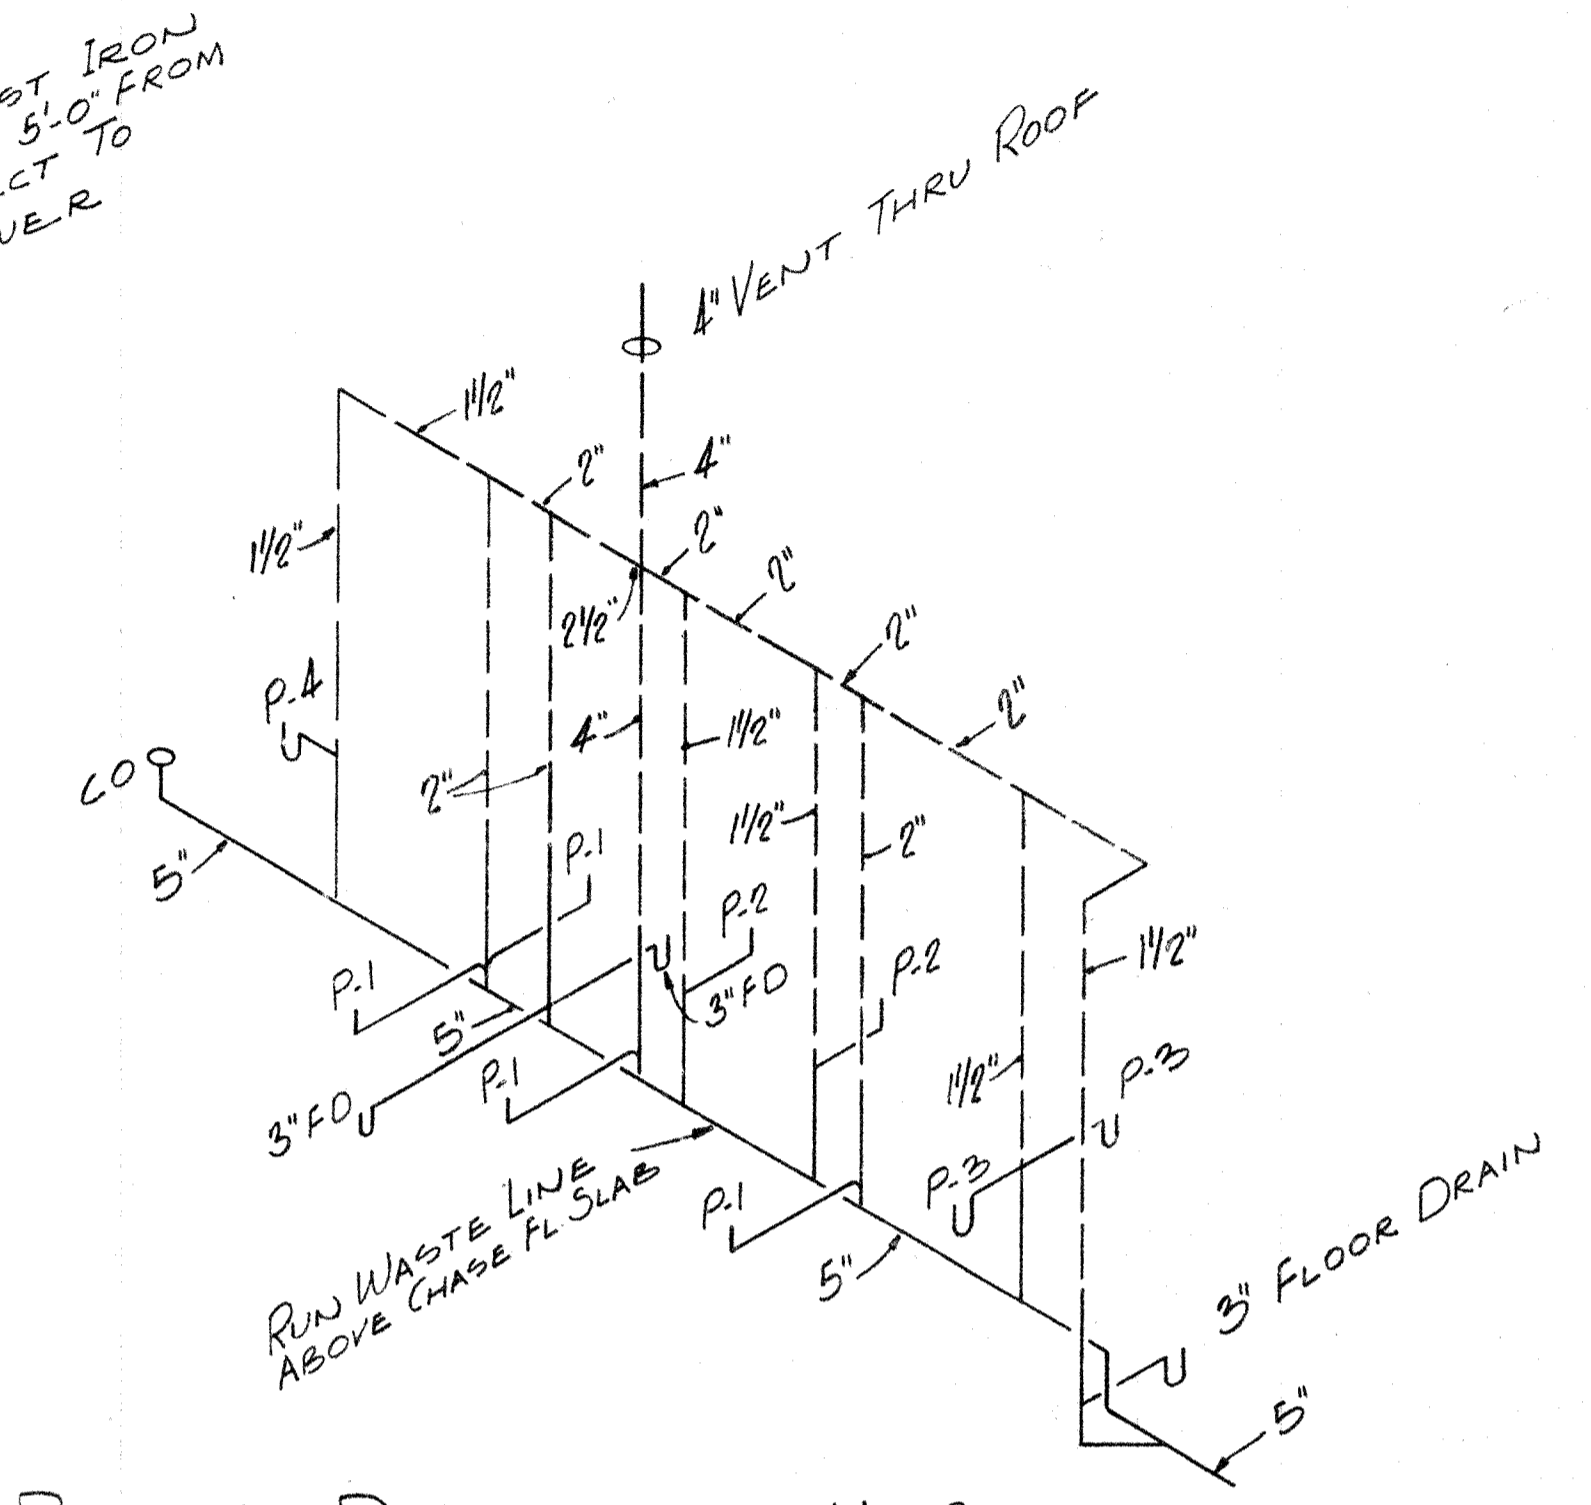

**RISER DIAGRAM** No SCALE