


PLAN VIEW
SCALE: AS SHOWN

No.	Equipment Description	P&ID Tag	No.	Equipment Description	P&ID Tag	No.	Equipment Description	P&ID Tag
01	LFG BLOWER SKID	ME-101	16	PSA BLOWDOWN VESSEL	ME-501	32	RECYCLE GAS SEPARATOR	ME-901
02	BLOWER AFTERCOOLER	HX-102	17	CARBON VESSELS	V-403A/B	33	THERMAL OXIDIZER	ME-502
03	DISCHARGE SEPARATOR	ME-103	18	ADSORBER VESSELS AND SKID	ME-601	34	AIR COMPRESSOR AND DRYER	ME-1400
04	H2S REMOVAL-A/B	V-201/V-202	19	VACUUM PUMP SKID	ME-701	35	MCC ROOM	
05	SUMP	SU-1004	20	BUFFER BAG/BUILDING	FLX-4100	36	MAINTENANCE ROOM	
06	PRIMARY COMPRESSOR	CMP-301A/B/C	21	RECYCLE BLOWER SKID	ME-801	37	CONTROL ROOM	
07	COMPRESSOR OIL COOLER	HX-302A/B/C	22	RECYCLE BLOWER AFTERCOOLER	HX-802	38	FUTURE COMPRESSOR SPACE	
08	COMPRESSOR AFTERCOOLER	HX-404	23	RECYCLE COMPRESSOR	CMP-803A/B	39	FUTURE AFTERCOOLER SPACE	
09	REFRIGERATION SKID	ME-203	24	RECYCLE AFTERCOOLER	HX-805	40	EXISTING ELECTRICAL EQUIPMENT	
10	FEED DISCHARGE SCRUBBER	ME-205	25	RECYCLE COMP. OIL COOLER	HX-804A/B	41	EXISTING FLARE #2	
11	REFRIGERANT CONDENSER	HX-204	26	HEAVY PRODUCT RECEIVER	RCV-4400	42	EXISTING FLARE #3	
12	FILTER	FLT-207	27	PRODUCT GAS COMPRESSOR	CMP-902	43	EXISTING STEEL TANK	
13a	AIR LIQUIDE SKID 1	ME-401	28	PRODUCT GAS OIL COOLER	HX-903	44	TRANSFORMER T2- 4160/480 V	
13b	AIR LIQUIDE SKID 2	ME-402	29	PRODUCT GAS AFTERCOOLER	HX-904	45	TRANSFORMER T1- 13.8KV-4160V	
14	BUFFER VESSEL	RCV-100	30	SALES GAS SEPARATOR	ME-905	46	CUSTOMER POLE	
15	LIGHT PRODUCT RECEIVERS	RCV-2100A/B	31	POLISHING VESSELS	V-906/V-907	47	UTILITY METER POLE	

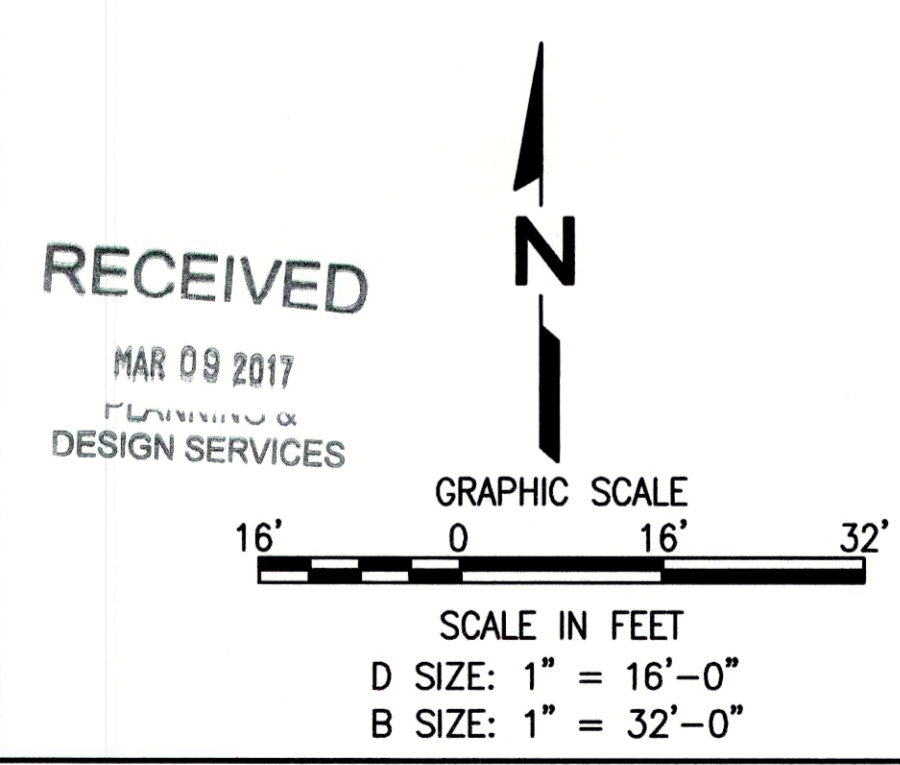

NOT FOR CONSTRUCTION

N: \JOBS\2016 - JOBS\06216014.00 - WM Outer Loop LF Drawings\0.01 General\G-100 Site Layout.dwg Mar 06, 2017 - 10:44am Bx: 4144.rvt

SCS ENERGY
 3900 KILROY AIRPORT WAY
 LONG BEACH, CA 90806
 (562) 426-9544
 KENTUCKY LICENSE NO: 109 (SCS ENGINEERS)

PROJ. NO. 06216014.00	DWN. BY: RN	ACAD FILE:
DSN. BY: RN	CHK. BY: RV	APP. BY: RV

CLIENT
WM OF KENTUCKY, LLC
 2673 OUTER LOOP
 LOUISVILLE, KY 40219

SHEET TITLE
SITE LAYOUT

PROJECT TITLE
**OUTER LOOP RDF
 HIGH BTU PROJECT**

NO.	REVISION	DATE	PROJECT DATE:
1	ISSUED FOR REVIEW	01-12-17	02/02/17
			SCALE: AS SHOWN
			DRAWING NO. G-100