

A.02 - Lou City FC

RS!
RUEFF SIGNS
www.rueffsigns.com

1530 East Washington St.
Louisville, Kentucky 40206
502-582-1714 - Phone
502-584-6427 - Fax

CUSTOMER

Louisville City Soccer Stadium

LOCATION

LC Soccer Stadium

SALESMAN

Carl Rueff

DATE

8-14-19

SCALE

3/16" = 1'

FILE NAME

Louisville City Soccer Stadium \ Signs for Production

Underwriters
Laboratories Inc.
LISTED
ELECTRIC SIGN
COMPLIES TO UL 48

ALL ELECTRICAL SIGNS ARE 120 VOLTS UNLESS OTHERWISE INDICATED


This sign is intended to be installed in accordance with the requirements of Article 600 of the National Electrical Code and/or other applicable local codes. This includes proper grounding and bonding of the sign.

This is a sketch, NOT A BLUEPRINT. Any photo overlays or images are merely an attempt to show the sign(s) as close as possible to how they may appear installed.


FINAL SIZES ARE AS LISTED ON THE MECHANICAL BREAKDOWN.

The contents of this drawing and all design elements are the property of Rueff Signs, Inc. They are not to be reproduced, changed, or exhibited to anyone outside of your company in whole or in part without written permission from the owner of Rueff Signs, Inc. All such actions are prohibited by law.

© RUEFF SIGNS, 2018 ALL RIGHTS RESERVED

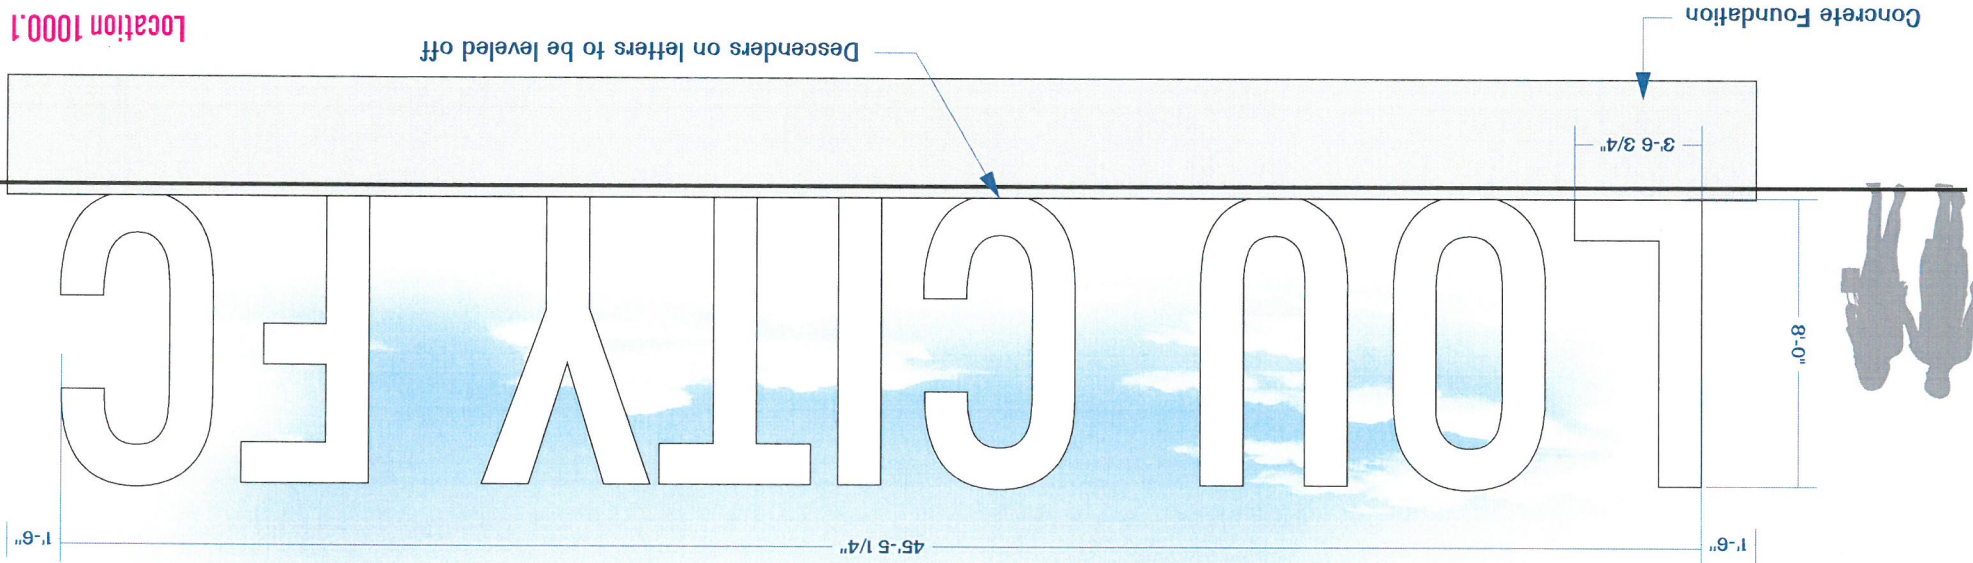

- .090 Aluminum Manufactured Letters with Internal Framework consisting of 3" Steel Square tubes and .090 Aluminum Baffles/Gussets.
- 1/4" x 28" x 12" x 12" Steel Plate Base Hilt Anchored into Concrete Foundation
- No Visible Fasteners on Face or Sides
- Counter Sunk Fasteners on Backs Painted to Match
- Beam Returns even to face & Backer
- Face Painted MP 04561 Snowmist White
- Returns & Back Painted to match PMS 269 Purple

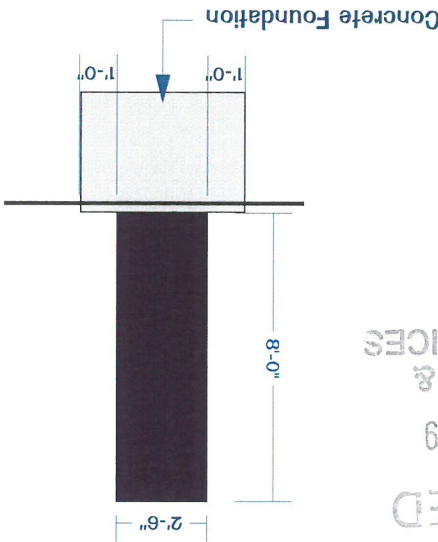

RECEIVED
SEP 23 2019
PLANNING &
DESIGN SERVICES

MP 04561 Snowmist White
PMS 269



www.rueffsigns.com

1530 East Washington St.
Louisville, Kentucky 40206
502-582-1714 - Phone
502-584-6427 - Fax

CUSTOMER

Louisville City Soccer Stadium

LOCATION

LC Soccer Stadium

SALESMAN

Carl Rueff

DATE

 
8-14-19

SCALE

3/16" = 1'

FILE NAME

Louisville City Soccer Stadium \ Signs for Production



Underwriters
Laboratories Inc.
LISTED
ELECTRIC SIGN
COMPLIES TO UL 48

ALL ELECTRICAL SIGNS ARE 120 VOLTS UNLESS OTHERWISE INDICATED

This sign is intended to be installed in accordance with the requirements of Article 600 of the National Electrical Code and/or other applicable local codes. This includes proper grounding and bonding of the sign.


This is a sketch, NOT A BLUEPRINT. Any photo overlays or images are merely an attempt to show the sign(s) as close as possible to how they may appear installed.

FINAL SIZES ARE AS LISTED ON THE MECHANICAL BREAKDOWN.

The contents of this drawing and all design elements are the property of Rueff Signs, Inc. They are not to be reproduced, changed, or exhibited to anyone outside of your company in whole or in part without written permission from the owner of Rueff Signs, Inc. All such actions are prohibited by law.

© RUEFF SIGNS, 2018 ALL RIGHTS RESERVED

A.02 - Lou City FC

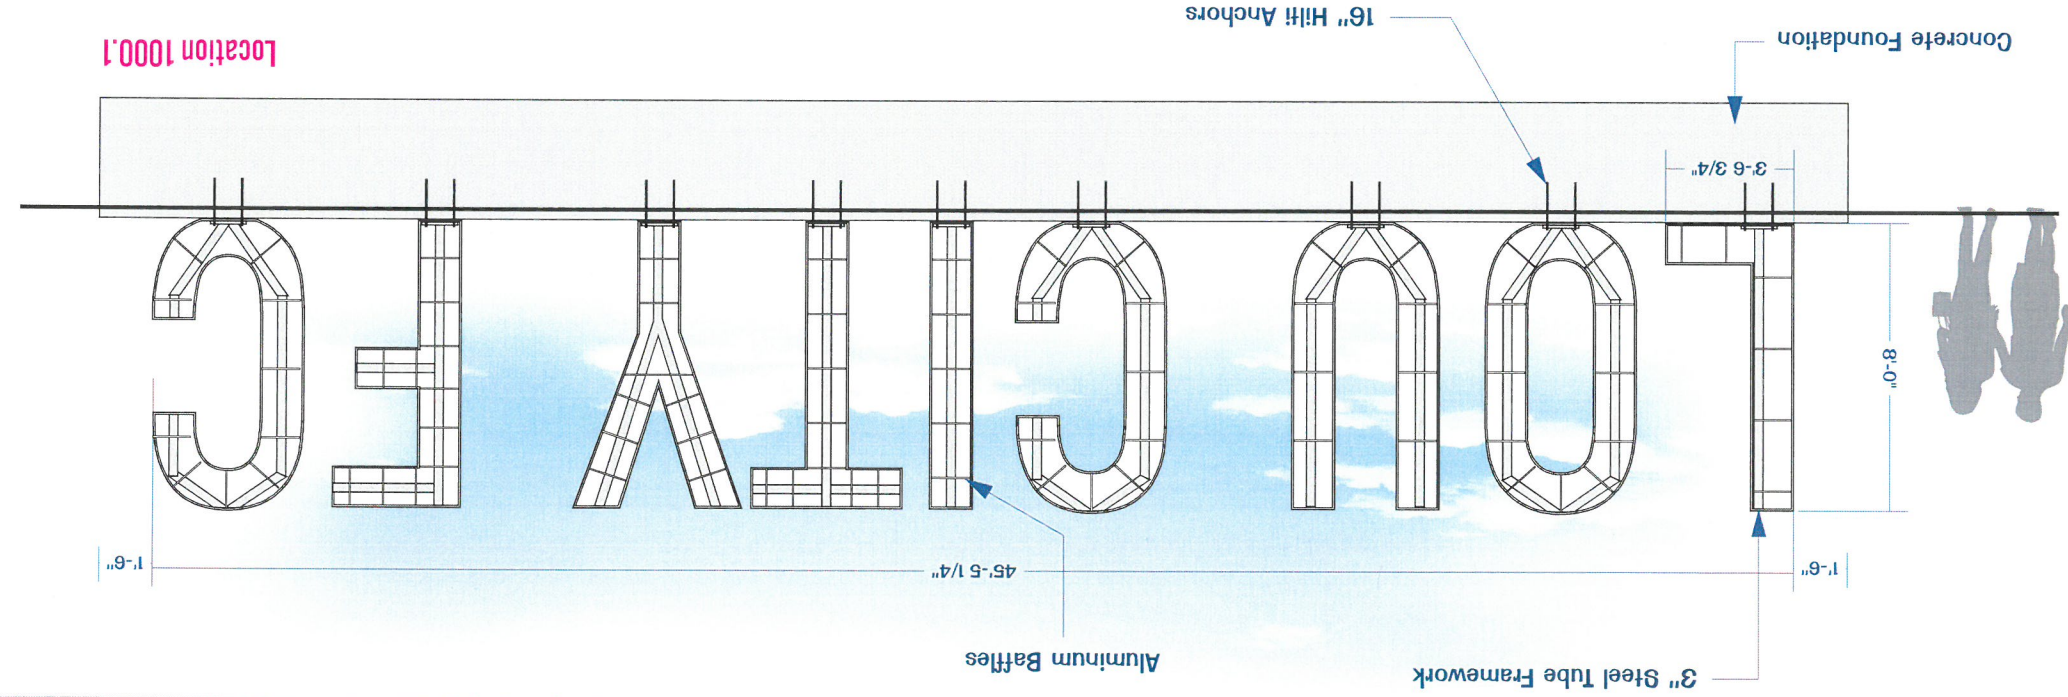

- .090 Aluminum Manufactured Letters with Internal Framework consisting of 3" Steel Square tubes and .090 Aluminum Baffles/Gussets.
- 1/4" x 12" x 28" Steel Plate Base Hilt Anchored into Concrete Foundation
- No Visible Fasteners on Face or Sides
- Counter Sunk Fasteners on Backs Painted to Match
- Seam Returns even to face & Backer
- Face Painted MP 04561 Snowmist White
- Returns & Back Painted to match PMS 269 Purple

RECEIVED
SEP 23 2019
PLANNING &
DESIGN SERVICES

MP 04561 Snowmist White
PMS 269

19 - VARIANCE - 0050

A.02 - Lou City FC

RS!
RUEFF SIGNS
www.rueffsigns.com

1530 East Washington St.
Louisville, Kentucky 40206
502-582-1714 - Phone
502-584-6427 - Fax

CUSTOMER

Louisville City Soccer Stadium

LOCATION

LC Soccer Stadium

SALESMAN

Carl Rueff

DATE

 
8-14-19

SCALE

3/16" = 1'

FILE NAME

Louisville City Soccer Stadium \ Signs for Production



ELECTRIC SIGN
COMPLIES TO UL 48

ALL ELECTRICAL SIGNS ARE 120 VOLTS UNLESS OTHERWISE INDICATED



This sign is intended to be installed in accordance with the requirements of Article 600 of the National Electrical Code and/or other applicable local codes. This includes proper grounding and bonding of the sign.

This is a sketch, NOT A BLUEPRINT. Any photo overlays or images are merely an attempt to show the sign(s) as close as possible to how they may appear installed.

FINAL SIZES ARE AS LISTED ON THE MECHANICAL BREAKDOWN.

The contents of this drawing and all design elements are the property of Rueff Signs, Inc. They are not to be reproduced, changed, or exhibited to anyone outside of your company in whole or in part without written permission from the owner of Rueff Signs, Inc. All such actions are prohibited by law.


© RUEFF SIGNS, 2018 ALL RIGHTS RESERVED

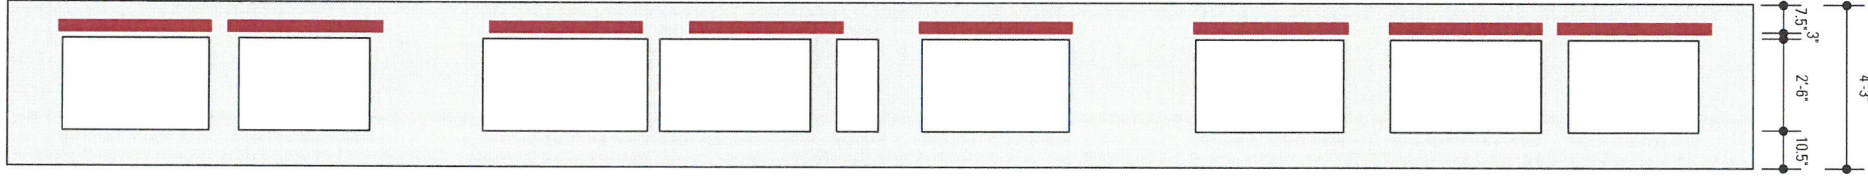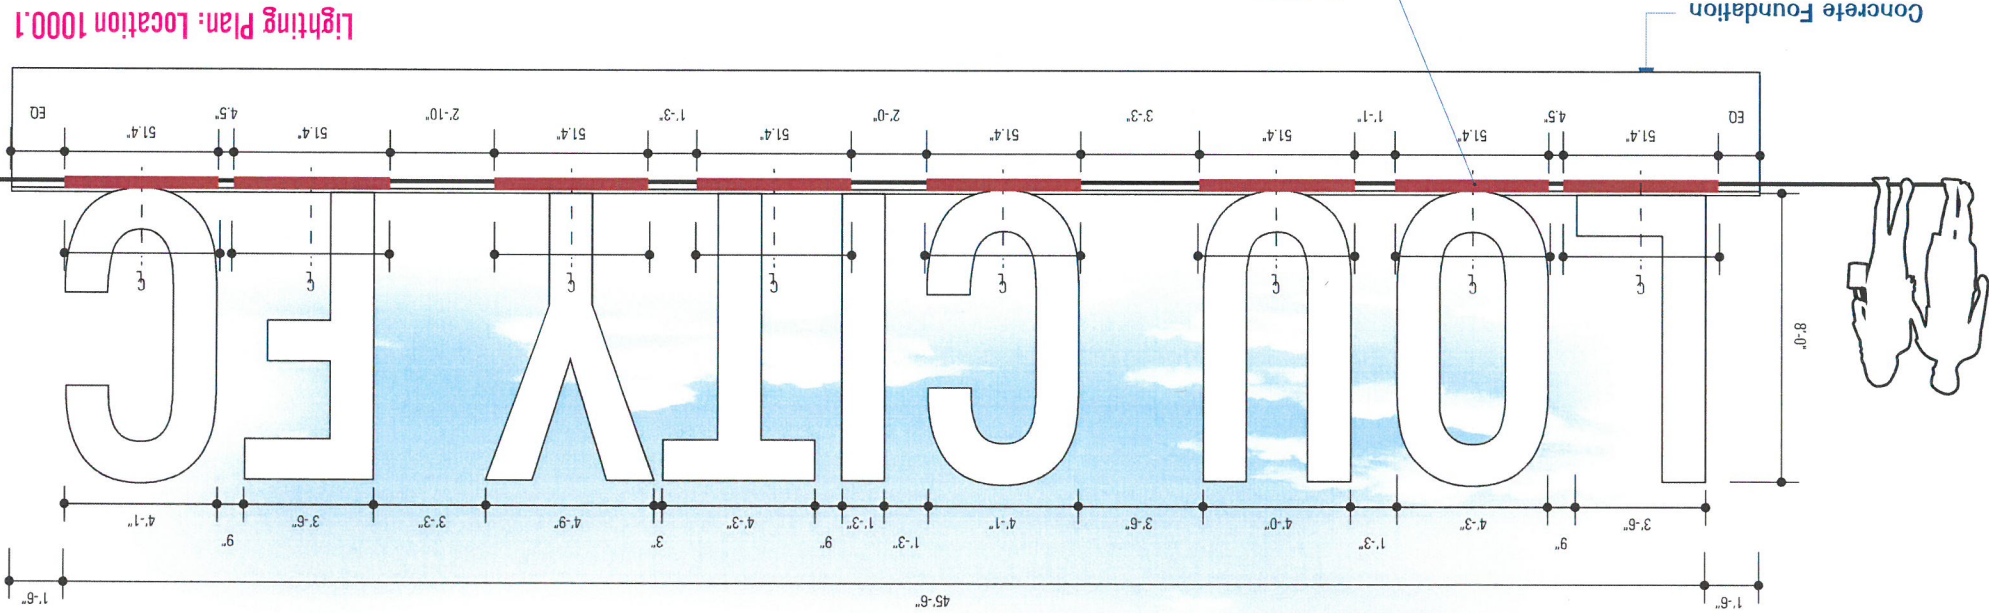

Light fixtures to be centered in front of each letterform. For the Letters "L" and "T", center the light fixture between the two base legs of the letterforms. Set back the light fix 3" from the face of the letterforms.

Strip Square Inground LED 1300
LED, 35W, 120/277V, 80 400 - 15 degree x 45 Degree, 3990 lm, 2633 lm - 50000 h, 070087.

Lighting Plan: Location 1000.1

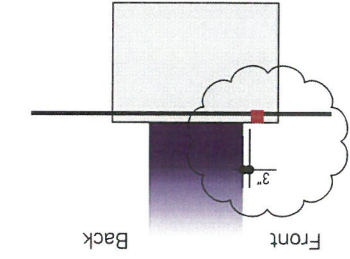

RECEIVED
SEP 23 2019
PLANNING &
DESIGN SERVICES

MP 04561 Snowmist White

PMS 269