


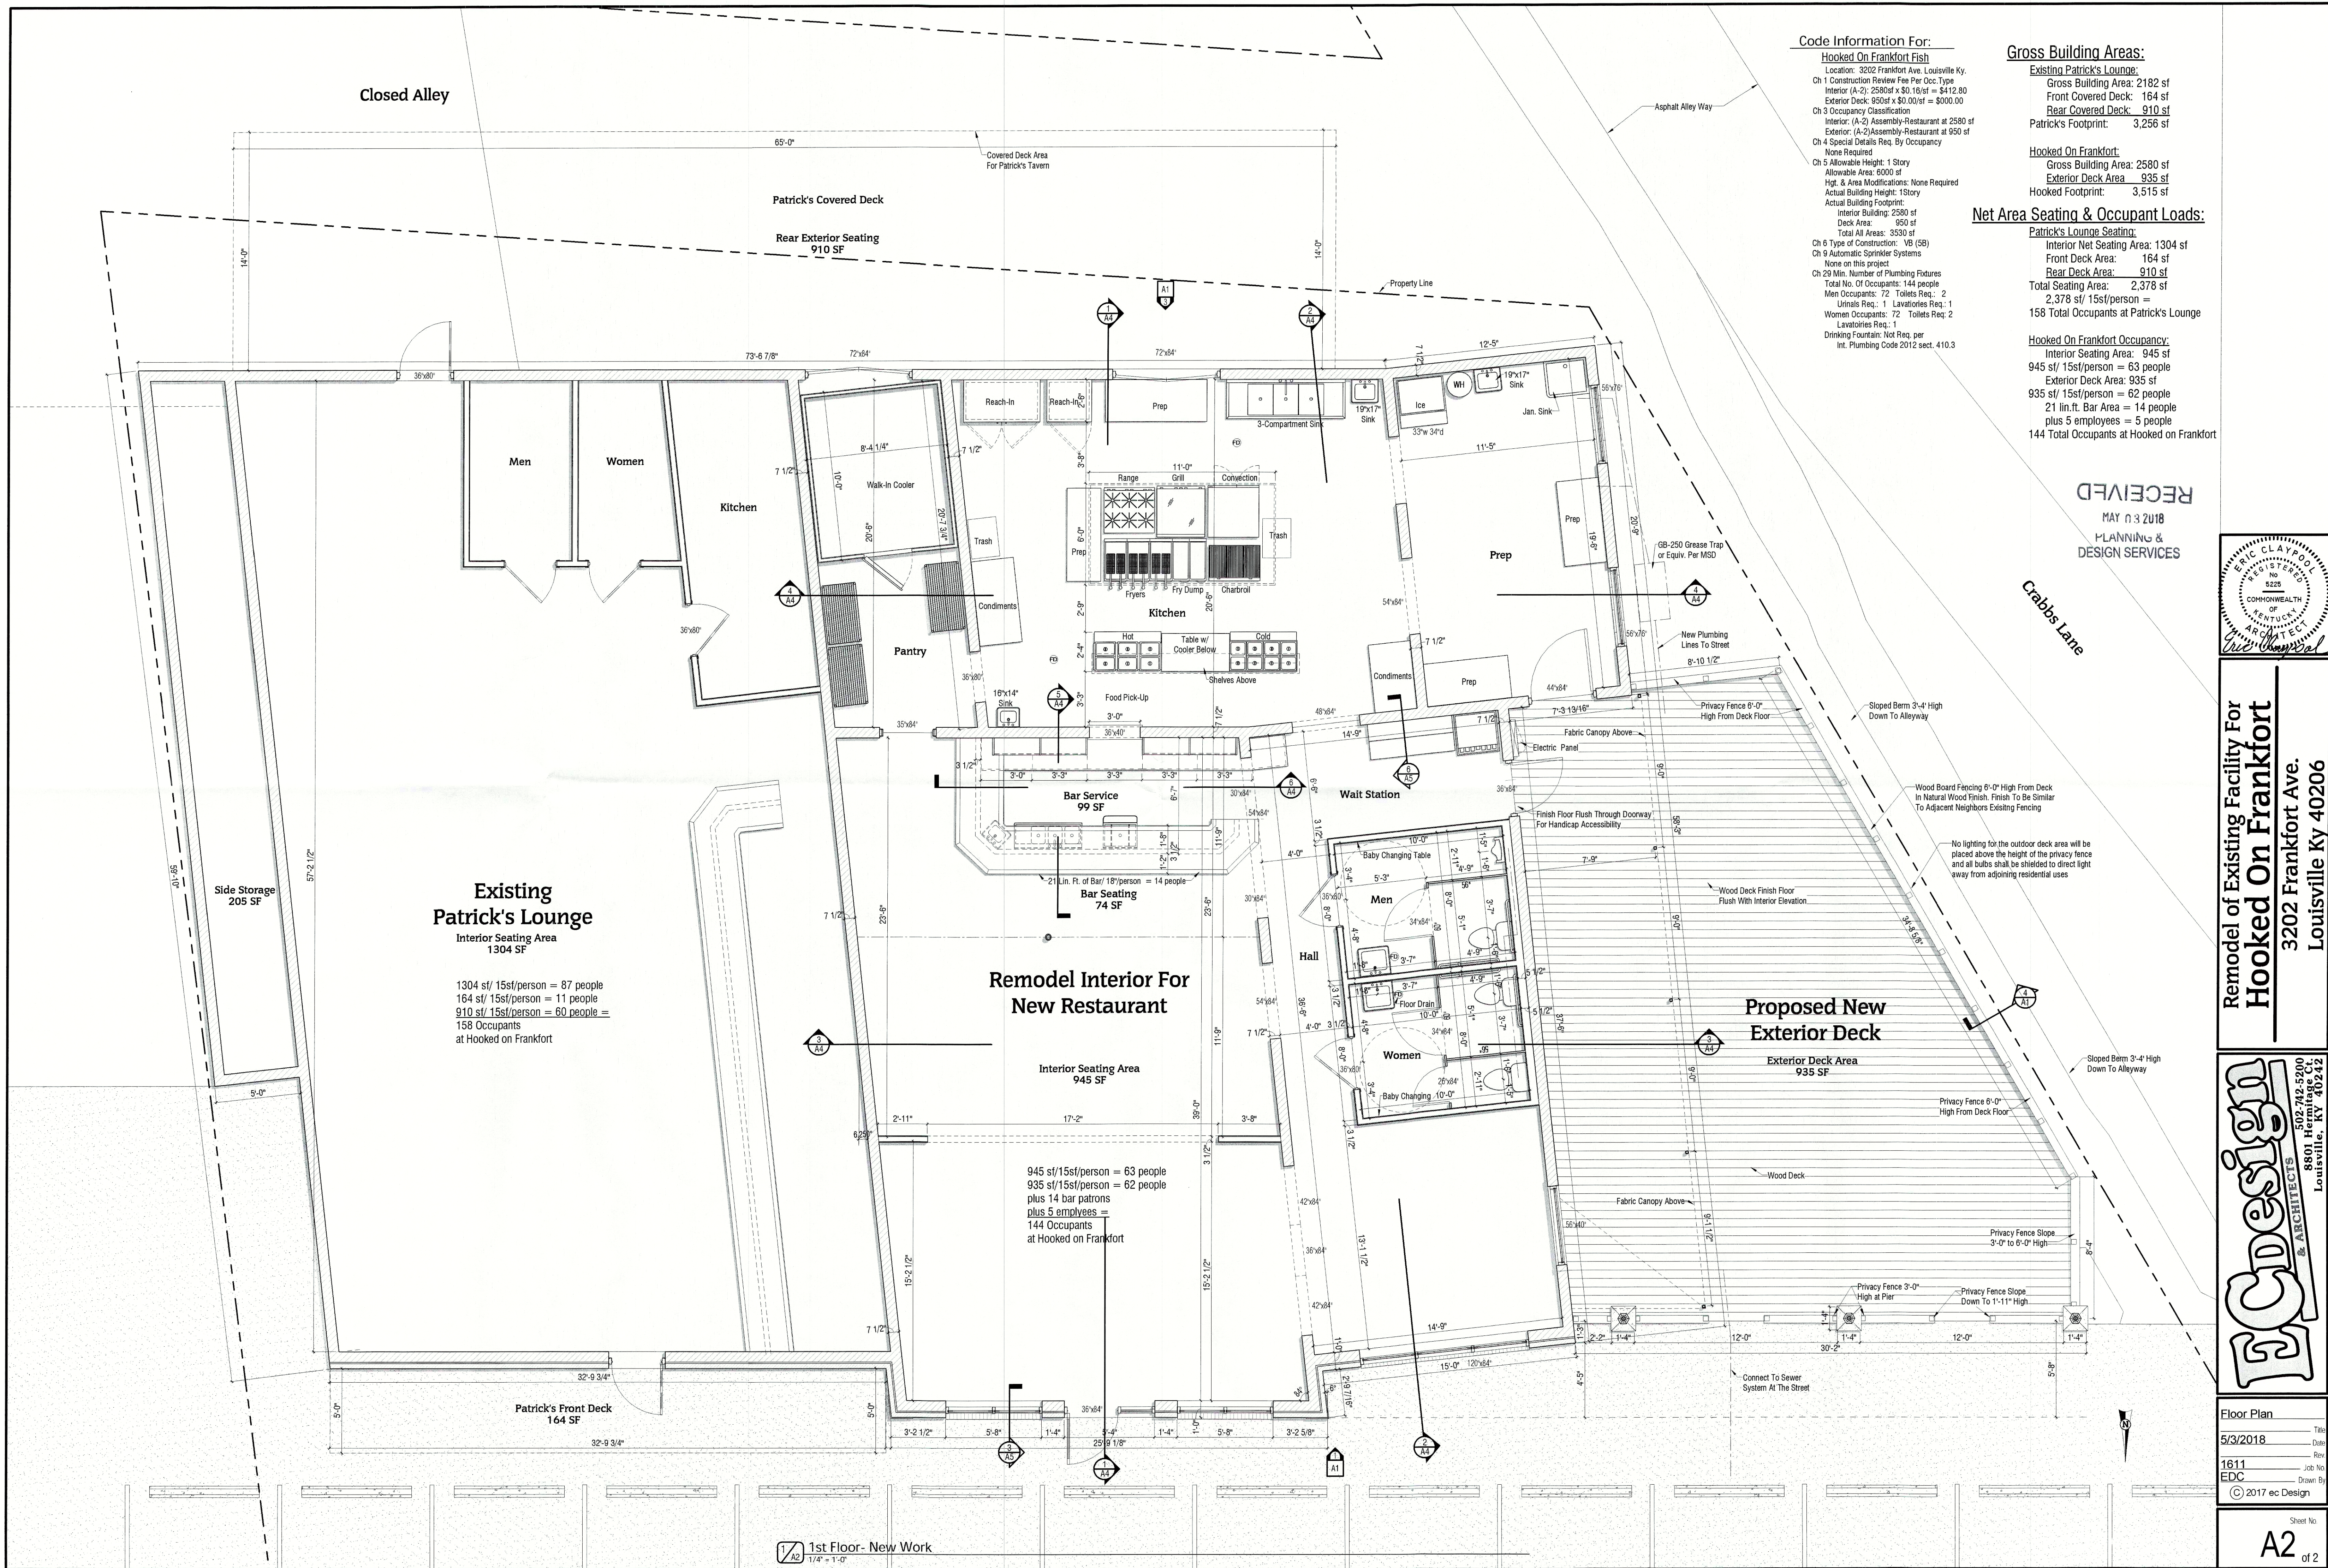

Code Information For:

Hooked On Frankfort Fish
Location: 3202 Frankfort Ave. Louisville Ky.
Ch 1 Construction Review Fee Per Occ. Type
Interior (A-2): 2580sf x \$0.16/sf = \$412.80
Exterior Deck: 935sf x \$0.00/sf = \$000.00
Ch 3 Occupancy Classification
Interior: (A-2) Assembly-Restaurant at 2580 sf
Exterior: (A-2) Assembly-Restaurant at 935 sf
Ch 4 Special Details Req. By Occupancy
None Required
Ch 5 Allowable Height: 1 Story
Allowable Area: 6000 sf
Hgt. & Area Modifications: None Required
Actual Building Height: 1 Story
Actual Building Footprint:
Interior Building: 2580 sf
Deck Area: 935 sf
Total All Areas: 3530 sf
Ch 6 Type of Construction: V8 (SB)
Ch 9 Automatic Sprinkler Systems
None on this project
Ch 29 Min. Number of Plumbing Fixtures
Total No. Of Occupants: 144 people
Men Occupants: 72 Toilets Req.: 2
Urinals Req.: 1 Lavatories Req.: 1
Women Occupants: 72 Toilets Req.: 2
Lavatories Req.: 1
Drinking Fountain: Not Req. per
Int. Plumbing Code 2012 sect. 410.3

Gross Building Areas:

Existing Patrick's Lounge:
Gross Building Area: 2182 sf
Front Covered Deck: 164 sf
Rear Covered Deck: 910 sf
Patrick's Footprint: 3,256 sf

Hooked On Frankfort:
Gross Building Area: 2580 sf
Exterior Deck Area: 935 sf
Hooked Footprint: 3,515 sf


Net Area Seating & Occupant Loads:

Patrick's Lounge Seating:
Interior Net Seating Area: 1304 sf
Front Deck Area: 164 sf
Rear Deck Area: 910 sf
Total Seating Area: 2,378 sf
2,378 sf/ 15sf/person = 158
158 Total Occupants at Patrick's Lounge

Hooked On Frankfort Occupancy:
Interior Seating Area: 945 sf
945 sf/ 15sf/person = 63 people
Exterior Deck Area: 935 sf
935 sf/ 15sf/person = 62 people
21 lin.ft. Bar Area = 14 people
plus 5 employees = 5 people
144 Total Occupants at Hooked on Frankfort

RECEIVED

MAY 13 2018
PLANNING &
DESIGN SERVICES

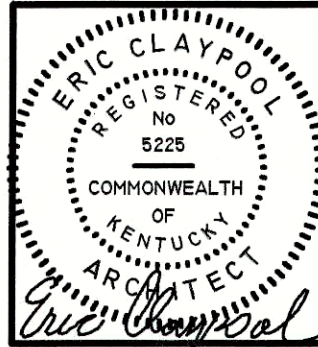

Remodel of Existing Facility For
Hooked On Frankfort
3202 Frankfort Ave.
Louisville Ky 40206

EC Design
& ARCHITECTS
502-742-5200
8801 Hermitage Ct
Louisville, KY 40242

Floor Plan
5/3/2018
1611
EDC
© 2017 ec Design

Sheet No.
A2
of 2