




Existing Rear Elevation



New Enlarged Porch

PROPOSED REAR ELEVATION

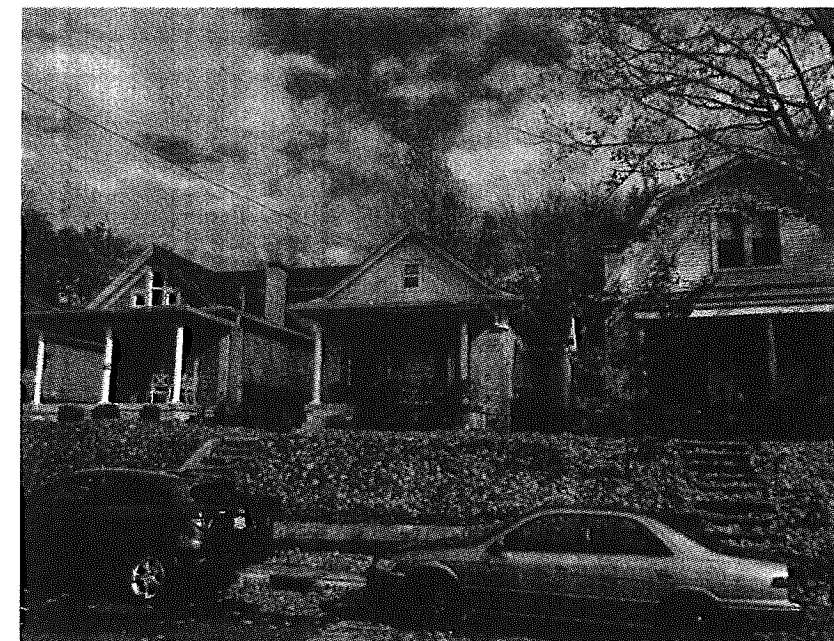

Existing Front Elevation

REVISION TABLE		REVISION BY	DESCRIPTION
NUMBER	DATE		

225 Saunders Ave.
2nd Floor Addition

DRAWINGS PROVIDED BY:
Designer Builders

DATE:

5/16/2016


SCALE:

SHEET:

A#1

RECEIVED

MAY 17 2016
PLANNING &
DESIGN SERVICES

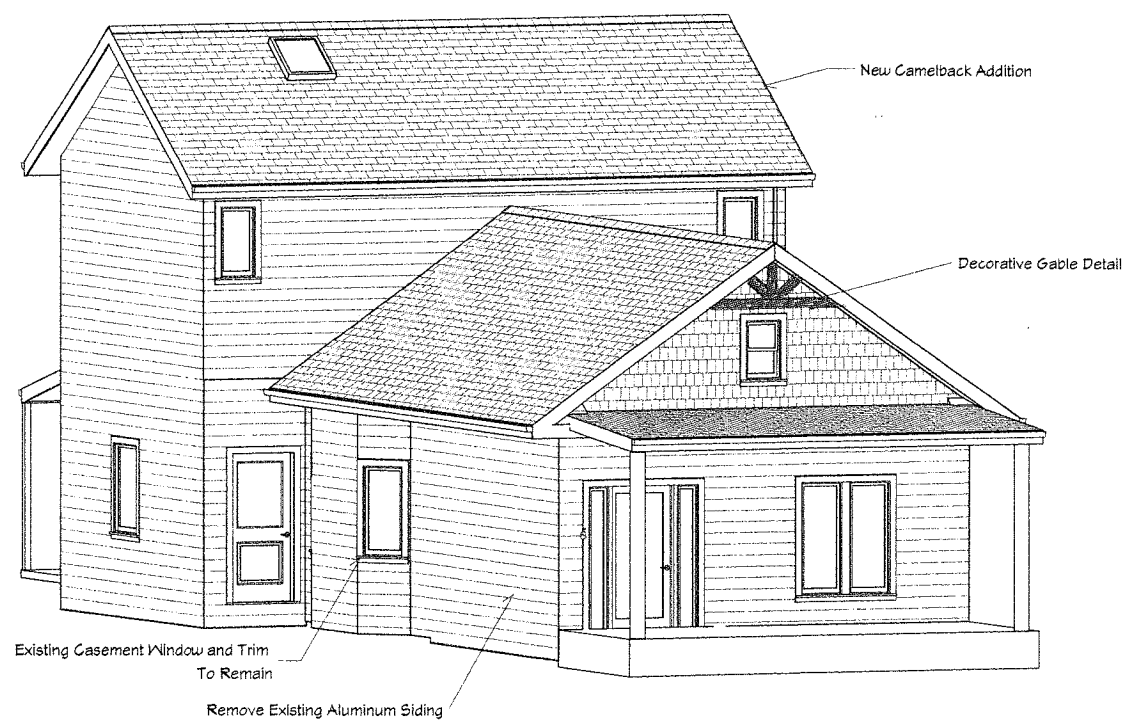


New Camelback Addition

Decorative Gable Detail

Existing Casement Window and Trim
To Remain

Remove Existing Aluminum Siding

3D Front Elevation

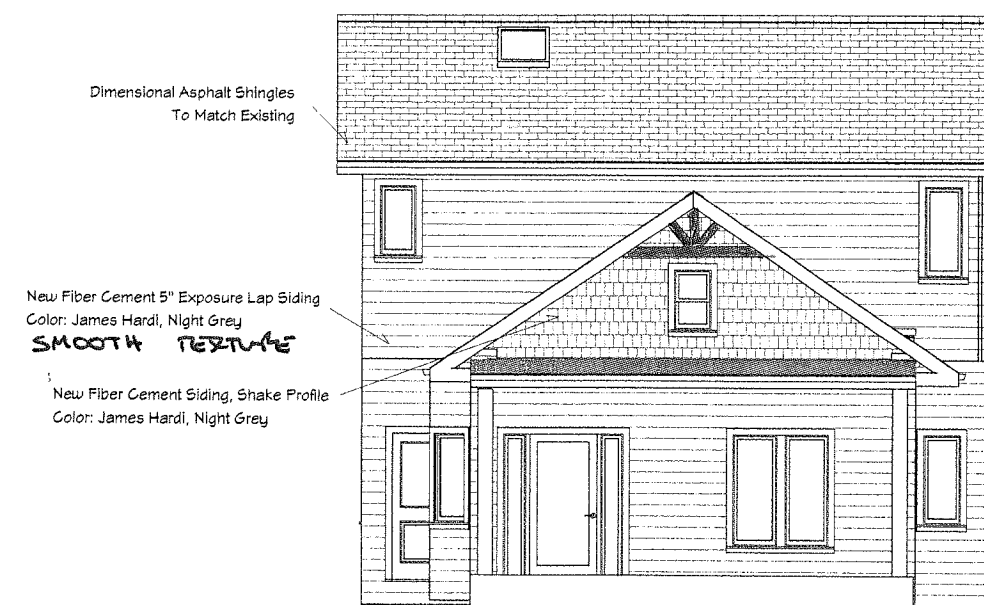


Dimensional Asphalt Shingles
To Match Existing

New Fiber Cement 5" Exposure Lap Siding
Color: James Hardi, Night Grey
SMOOTH TEXTURE

New Fiber Cement Siding, Shake Profile
Color: James Hardi, Night Grey

PROPOSED FRONT ELEVATION

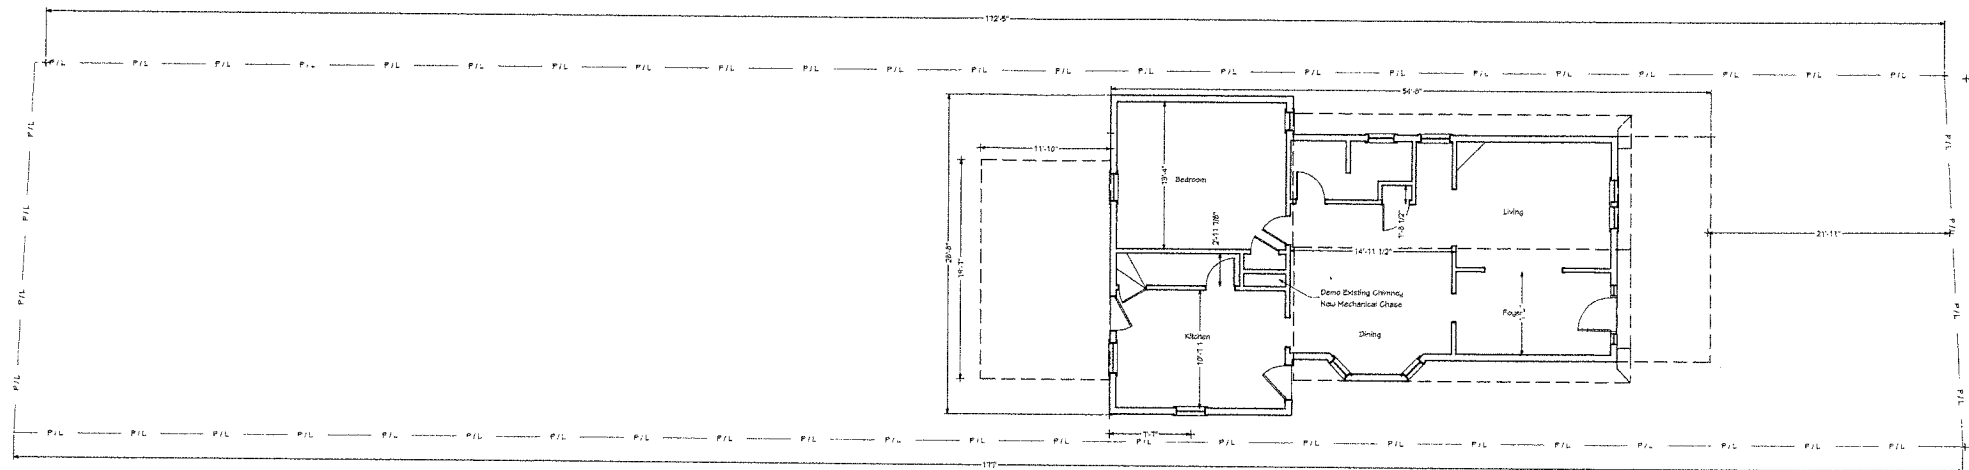

SITE PLAN

~~SCALE 1/8"~~
NOT TO SCALE

RECEIVED
MAY 17 2016
PLANNING &
DESIGN SERVICES

N

SAUNDERS
AVE.

REVISION TABLE	
NUMBER	DATE

DRAWINGS PROVIDED BY:
Designer Builders

DATE:


5/16/2016

SCALE:


SHEET:

S-1


OWENS CORNING DURATION DIMENSIONAL
ASPHALT SHIN(print at 1"=1')

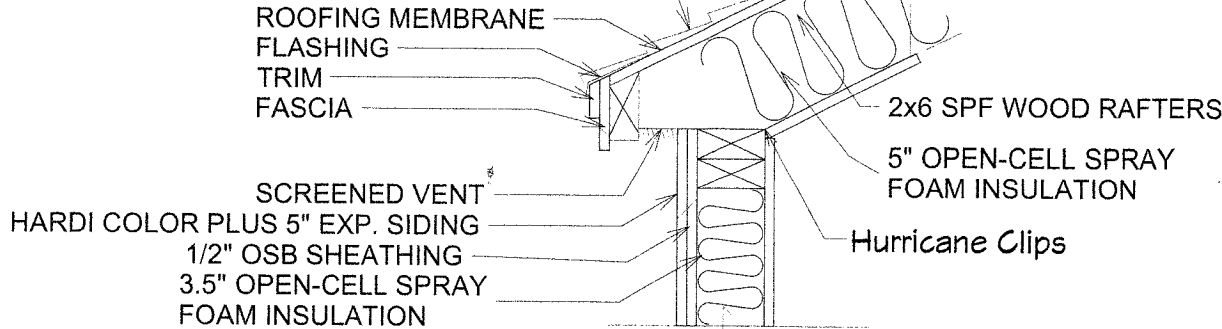

Eave Detail

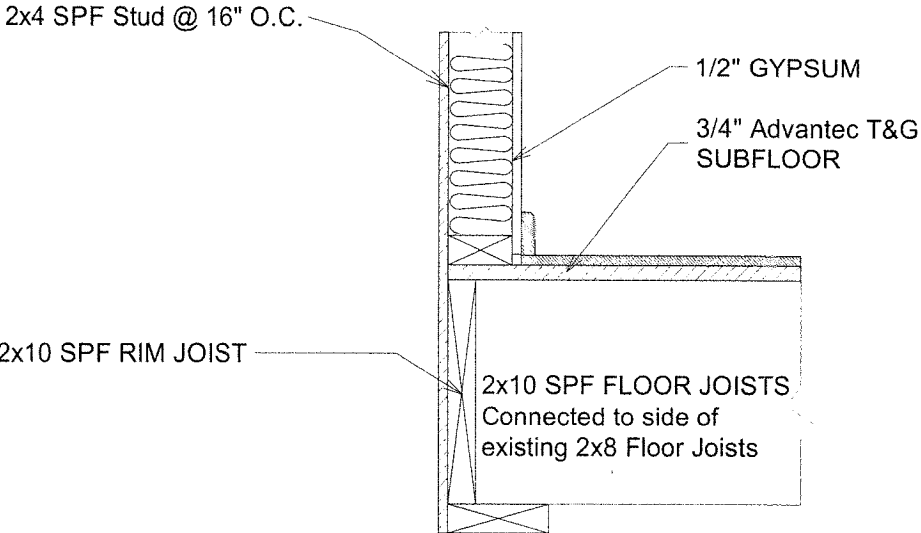

Floor Detail

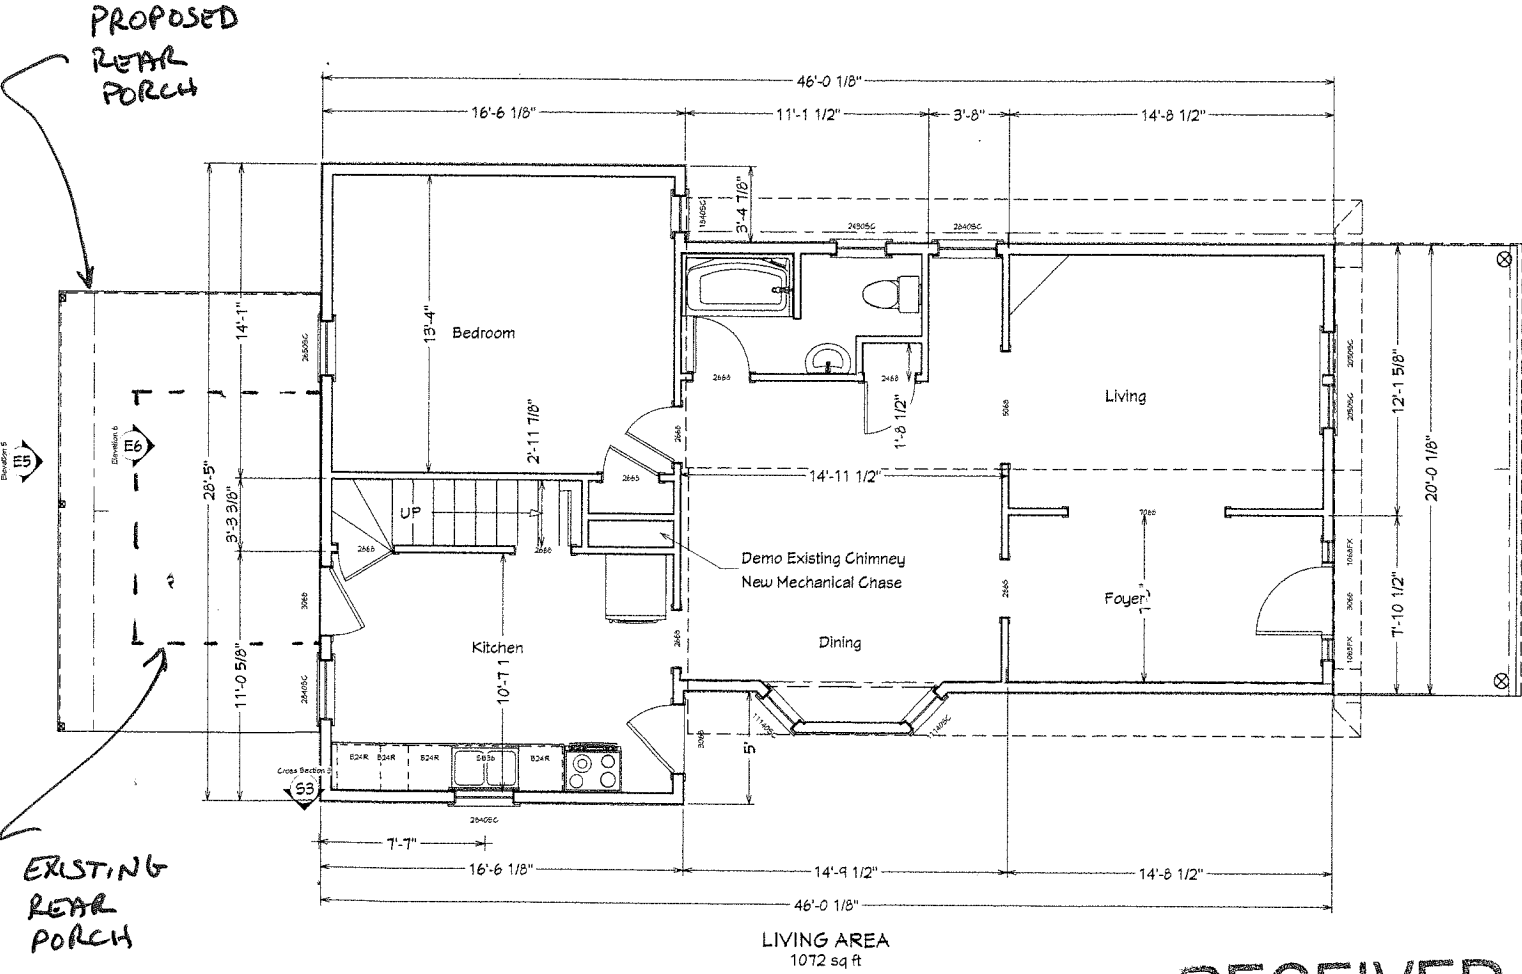

Scale: 1/4" = 1'-0"
NOT TO SCALE

RECEIVED


MAY 17 2016
PLANNING &
DESIGN SERVICES

REVISION TABLE	
NUMBER	DATE


225 Saunders Ave.
2nd Floor Addition

DRAWINGS PROVIDED BY:
Designer Builders

DATE:
5/16/2016
SCALE:
SHEET:
A-2

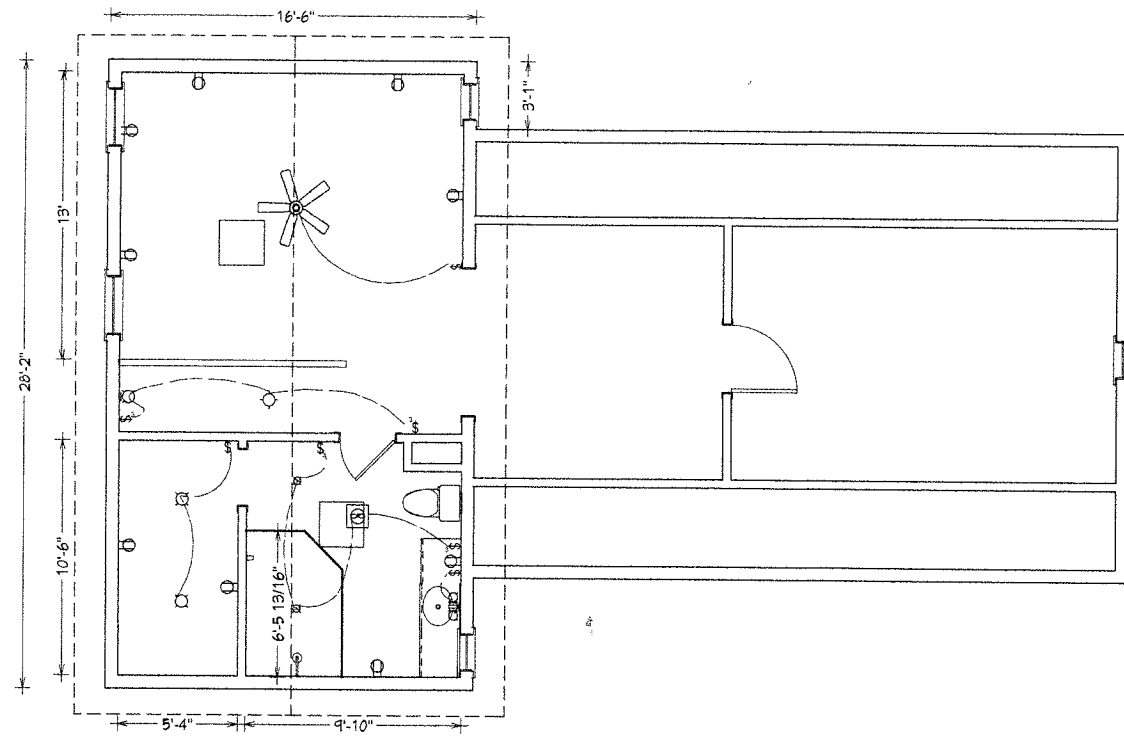

2ND FLOOR ELECTRICAL PLAN

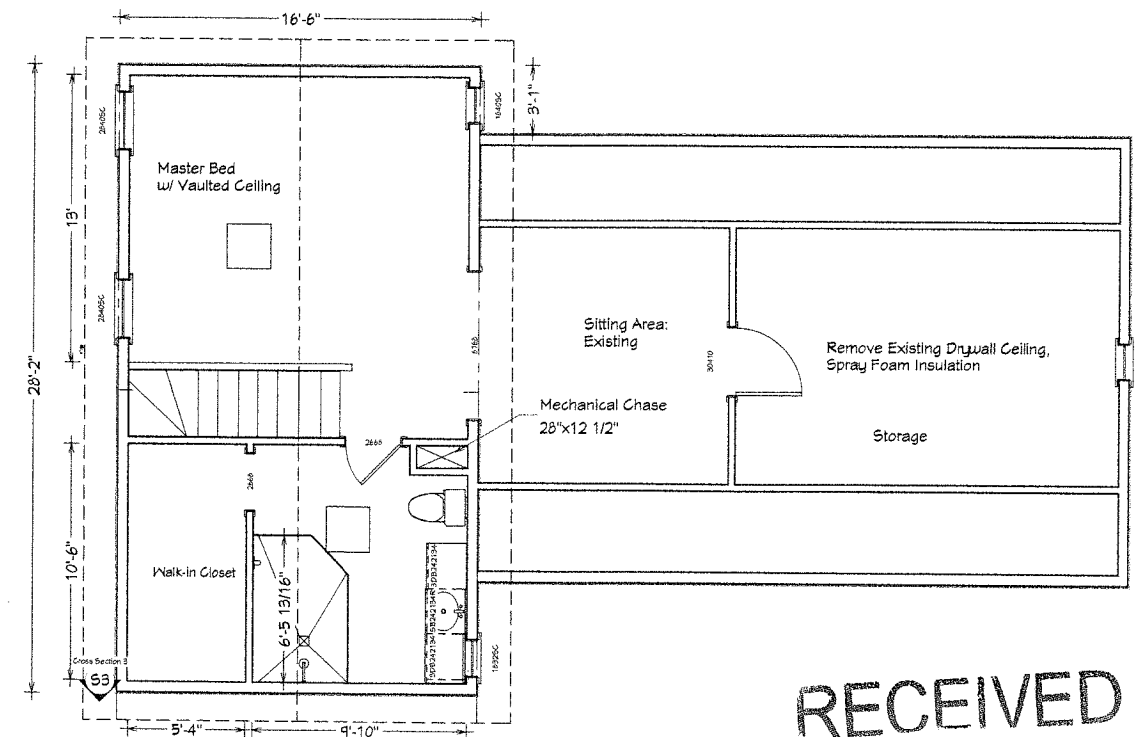

2ND FLOOR RENOVATION PLAN
1054 sq ft

Scale: 1/4" = 1'-0"
NOT TO SCALE

RECEIVED
MAY 17 2016
PLANNING &
DESIGN SERVICES

REVISION TABLE	
NUMBER	DATE

DRAWINGS PROVIDED BY:
Designer Builders

DATE:

5/16/2016

SCALE:

SHEET:

A-3