

RECEIVED


MAR 10 2016
PLANNING &
DESIGN SERVICES

EXTERIOR ELEVATION KEYNOTES

- 801 NICHHA PANEL SYSTEM - STYLE: ILLUMINATION SERIES COLOR: PANTONE RED PMS 186 RED ; CONTRACTOR FURNISHED, CONTRACTOR INSTALLED
- 802 NICHHA PANEL SYSTEM - STYLE: PLYMOTH BRICK COLOR: CRIMSON ; CONTRACTOR FURNISHED, CONTRACTOR INSTALLED
- 803 NICHHA PANEL SYSTEM - STYLE: ILLUMINATION SERIES COLOR: BENJAMIN MOORE DEEP SPACE 2125-20 ; CONTRACTOR FURNISHED, CONTRACTOR INSTALLED
- 804 NICHHA SYNTHETIC STONE SYSTEM - STYLE: KURASTONE DESERT ; CONTRACTOR FURNISHED, CONTRACTOR INSTALLED
- 805 ARCHITECTURAL CANOPY AND LOUVER SYSTEM - COLOR: BLACK ; VENDOR FURNISHED, CONTRACTOR INSTALLED
- 806 ARCHITECTURAL CANOPY AND LOUVER SYSTEM - COLOR: PANTONE 8600C PEWTER ; VENDOR FURNISHED, CONTRACTOR INSTALLED
- 807 PREFINISHED METAL COPING - COLOR: BLACK ; CONTRACTOR FURNISHED, CONTRACTOR INSTALLED
- 808 PREFINISHED METAL GUTTER SYSTEM - COLOR: BLACK ; CONTRACTOR FURNISHED, CONTRACTOR INSTALLED
- 809 PREFINISHED METAL DOWNSPOUT SYSTEM, SUPPLY MATCHING RECEIVING BOOT FOR TRANSITION TO UNDERGROUND STORM DRAINAGE - COLOR: BLACK ; CONTRACTOR FURNISHED, CONTRACTOR INSTALLED
- 810 NICHHA SILL-CHISELED SYSTEM - COLOR: MATCH KURASTONE ; CONTRACTOR FURNISHED, CONTRACTOR INSTALLED

EXTERIOR ELEVATION KEYNOTES

- 811 ROOF ACCESS LADDER SYSTEM - COLOR: BLACK ; CONTRACTOR FURNISHED, CONTRACTOR INSTALLED
- 812 SCHEDULED DOOR AND FRAME - SEE A14.1 SHEET FOR MORE INFORMATION
- 814 LINE OF FOUNDATION BELOW - SEE STRUCTURAL DRAWINGS FOR MORE INFORMATION
- 815 ALCOHOL LICENSE NUMBER ; OWNER FURNISHED, OWNER INSTALLED
- 816 LINE OF ROOF TOP MECHANICAL EQUIPMENT BEYOND - SEE MECHANICAL DRAWINGS FOR MORE INFORMATION
- 817 EXTERIOR LIGHT FIXTURE - VERIFY COLOR WITH OWNER PRIOR TO CONSTRUCTION - SEE ELECTRICAL DRAWINGS FOR MORE INFORMATION
- 818 ELECTRIC POWER OULET - SEE ELECTRICAL DRAWINGS FOR MORE INFORMATION
- 819 FREEZELESS WALL HYDRANT ASSEMBLY - SEE PLUMBING DRAWINGS FOR MORE INFORMATION
- 821 MEMBRANE ROOFING SYSTEM.
- 822 VERIFY FINAL LOCATION OF EMERGENCY GAS SHUT OFF WITH FUEL SYSTEM VENDOR - MOUNTING HEIGHT TO BE 4'-0" ABOVE FINISH GRADE.
- 823 ELECTRIC SERVICE EQUIPMENT, PAINTED:STEALTH GREY - SEE ELECTRICAL DRAWINGS FOR MORE INFORMATION.
- 824 SEE PLUMBING DRAWINGS FOR GAS SERVICE INFORMATION AND REQUIREMENTS.
- 825 BUILDING ADDRESS AND STORE NUMBER LOCATION.
- 826 PANEL SYSTEM VERTICAL EXPANSION JOINT LOCATION - INSTALL PER MANUFACTURER.

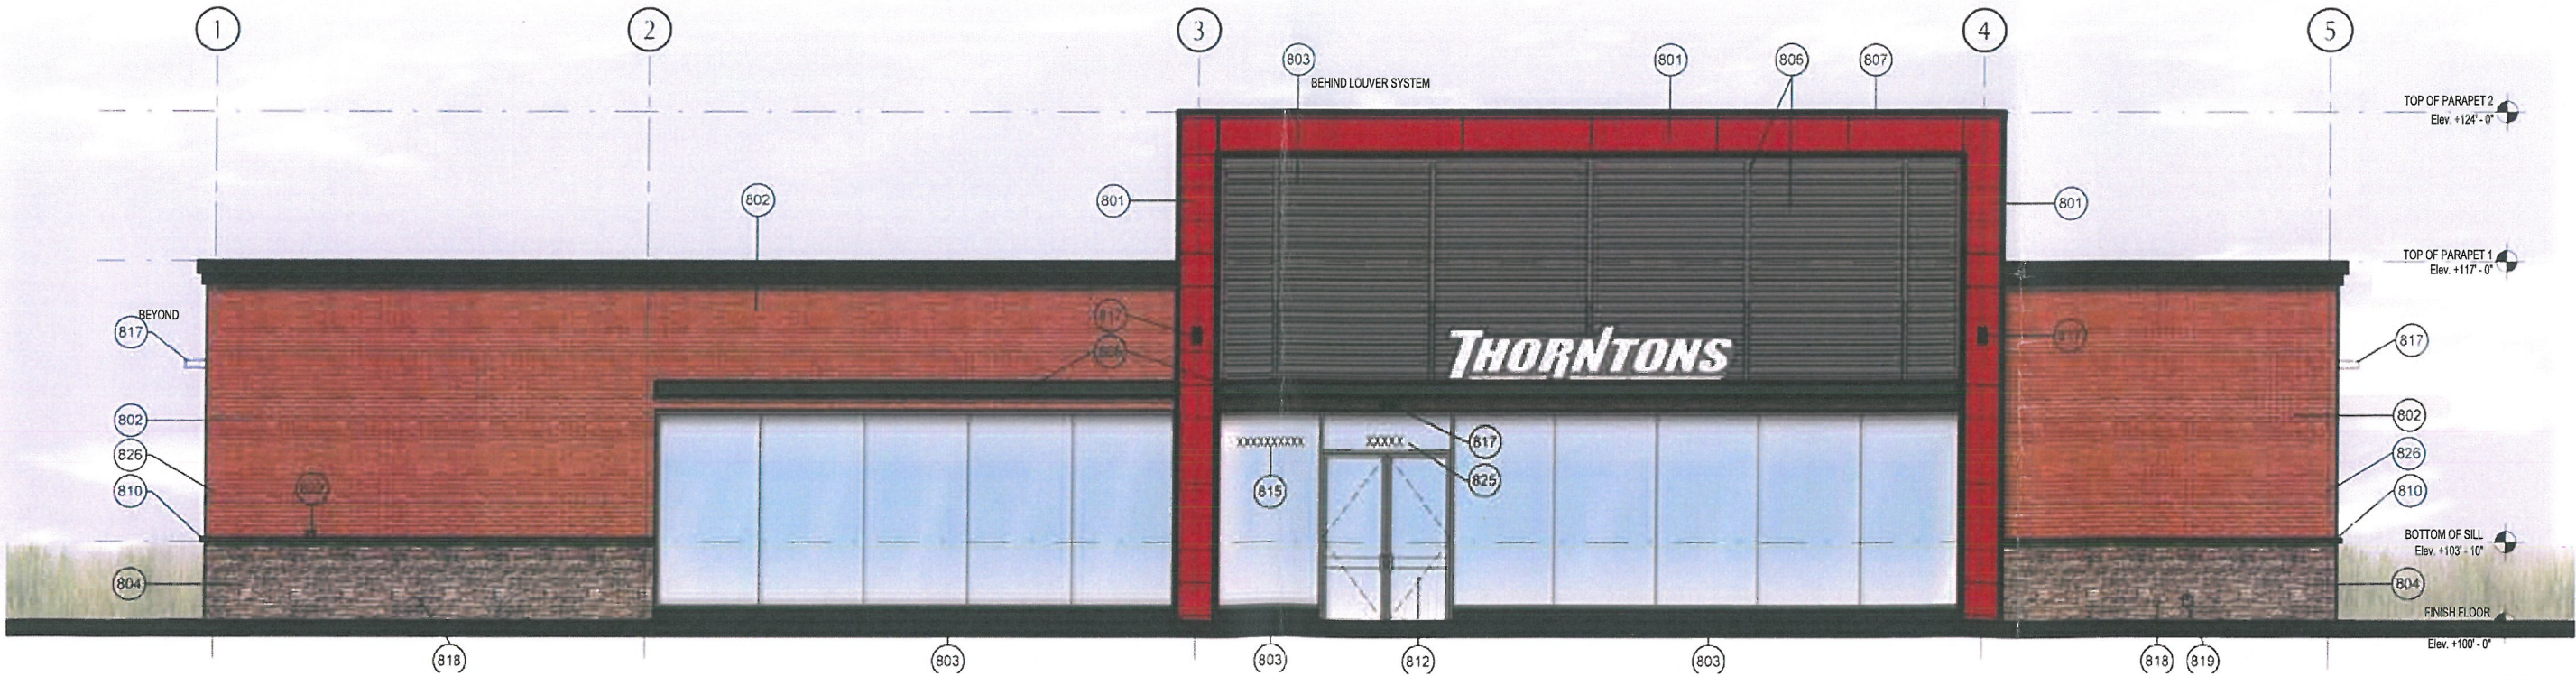

Building - Front Elevation

Facing KY 412

RECEIVED

MAR 10 2016
PLANNING &
DESIGN SERVICES



EXTERIOR ELEVATION KEYNOTE

- 801 NICHIIA PANEL SYSTEM - STYLE: ILLUMINATION SERIES COLOR: PANTONE RED PMS 186 RED ; CONTRACTOR FURNISHED, CONTRACTOR INSTALLED
- 802 NICHIIA PANEL SYSTEM - STYLE: PLYMOTH BRICK COLOR: CRIMSON ; CONTRACTOR FURNISHED, CONTRACTOR INSTALLED
- 803 NICHIIA PANEL SYSTEM - STYLE: ILLUMINATION SERIES COLOR: BENJAMIN MOORE DEEP SPACE 2125-20 ; CONTRACTOR FURNISHED, CONTRACTOR INSTALLED
- 804 NICHIIA SYNTHETIC STONE SYSTEM - STYLE: KURASTONE DESERT ; CONTRACTOR FURNISHED, CONTRACTOR INSTALLED
- 805 ARCHITECTURAL CANOPY AND LOUVER SYSTEM - COLOR: BLACK ; VENDOR FURNISHED, CONTRACTOR INSTALLED
- 806 ARCHITECTURAL CANOPY AND LOUVER SYSTEM - COLOR: PANTONE 8600C PEWTER ; VENDOR FURNISHED, CONTRACTOR INSTALLED
- 807 PREFINISHED METAL COPING - COLOR: BLACK ; CONTRACTOR FURNISHED, CONTRACTOR INSTALLED
- 808 PREFINISHED METAL GUTTER SYSTEM - COLOR: BLACK ; CONTRACTOR FURNISHED, CONTRACTOR INSTALLED
- 809 PREFINISHED METAL DOWNSPOUT SYSTEM, SUPPLY MATCHING RECEIVING BOOT FOR TRANSITION TO UNDERGROUND STORM DRAINAGE - COLOR: BLACK ; CONTRACTOR FURNISHED, CONTRACTOR INSTALLED
- 810 NICHIIA SILL-CHISELED SYSTEM - COLOR: MATCH KURASTONE ; CONTRACTOR FURNISHED, CONTRACTOR INSTALLED
- 811 ROOF ACCESS LADDER SYSTEM - COLOR: BLACK ; CONTRACTOR FURNISHED, CONTRACTOR INSTALLED
- 812 SCHEDULED DOOR AND FRAME - SEE A14.1 SHEET FOR MORE INFORMATION
- 814 LINE OF FOUNDATION BELOW - SEE STRUCTURAL DRAWINGS FOR MORE INFORMATION
- 815 ALCOHOL LICENSE NUMBER ; OWNER FURNISHED, OWNER INSTALLED
- 816 LINE OF ROOF TOP MECHANICAL EQUIPMENT BEYOND - SEE MECHANICAL DRAWINGS FOR MORE INFORMATION
- 817 EXTERIOR LIGHT FIXTURE - VERIFY COLOR WITH OWNER PRIOR TO CONSTRUCTION - SEE ELECTRICAL DRAWINGS FOR MORE INFORMATION
- 818 ELECTRIC POWER OULET - SEE ELECTRICAL DRAWINGS FOR MORE INFORMATION
- 819 FREEZELESS WALL HYDRANT ASSEMBLY - SEE PLUMBING DRAWINGS FOR MORE INFORMATION
- 821 MEMBRANE ROOFING SYSTEM.
- 822 VERIFY FINAL LOCATION OF EMERGENCY GAS SHUT OFF WITH FUEL SYSTEM VENDOR - MOUNTING HEIGHT TO BE 4'-0" ABOVE FINISH GRADE.
- 823 ELECTRIC SERVICE EQUIPMENT, PAINTED:STEALTH GREY - SEE ELECTRICAL DRAWINGS FOR MORE INFORMATION.
- 824 SEE PLUMBING DRAWINGS FOR GAS SERVICE INFORMATION AND REQUIREMENTS.
- 825 BUILDING ADDRESS AND STORE NUMBER LOCATION.
- 826 PANEL SYSTEM VERTICAL EXPANSION JOINT LOCATION - INSTALL PER MANUFACTURER.
- 827 ALUMIUNUM SCREEN WALL SYSTEM - SEE ROOF PLAN FOR MORE INFORMATION.


Building Left Elevation - Spandrel

Facing KY22 (Brownsboro Rd.)

EXTERIOR ELEVATION KEYNOTE


- 801 NICHIIHA PANEL SYSTEM - STYLE: ILLUMINATION SERIES COLOR: PANTONE RED PMS 186 RED ; CONTRACTOR FURNISHED, CONTRACTOR INSTALLED
- 802 NICHIIHA PANEL SYSTEM - STYLE: PLYMOTH BRICK COLOR: CRIMSON ; CONTRACTOR FURNISHED, CONTRACTOR INSTALLED
- 803 NICHIIHA PANEL SYSTEM - STYLE: ILLUMINATION SERIES COLOR: BENJAMIN MOORE DEEP SPACE 2125-20 ; CONTRACTOR FURNISHED, CONTRACTOR INSTALLED
- 804 NICHIIHA SYNTHETIC STONE SYSTEM - STYLE: KURASTONE DESERT ; CONTRACTOR FURNISHED, CONTRACTOR INSTALLED
- 805 ARCHITECTURAL CANOPY AND LOUVER SYSTEM - COLOR: BLACK ; VENDOR FURNISHED, CONTRACTOR INSTALLED
- 806 ARCHITECTURAL CANOPY AND LOUVER SYSTEM - COLOR: PANTONE 8600C PEWTER ; VENDOR FURNISHED, CONTRACTOR INSTALLED
- 807 PREFINISHED METAL COPING - COLOR: BLACK ; CONTRACTOR FURNISHED, CONTRACTOR INSTALLED
- 808 PREFINISHED METAL GUTTER SYSTEM - COLOR: BLACK ; CONTRACTOR FURNISHED, CONTRACTOR INSTALLED
- 809 PREFINISHED METAL DOWNSPOUT SYSTEM, SUPPLY MATCHING RECEIVING BOOT FOR TRANSITION TO UNDERGROUND STORM DRAINAGE - COLOR: BLACK ; CONTRACTOR FURNISHED, CONTRACTOR INSTALLED
- 810 NICHIIHA SILL-CHISELED SYSTEM - COLOR: MATCH KURASTONE ; CONTRACTOR FURNISHED, CONTRACTOR INSTALLED
- 811 ROOF ACCESS LADDER SYSTEM - COLOR: BLACK ; CONTRACTOR FURNISHED, CONTRACTOR INSTALLED
- 812 SCHEDULED DOOR AND FRAME - SEE A14.1 SHEET FOR MORE INFORMATION
- 814 LINE OF FOUNDATION BELOW - SEE STRUCTURAL DRAWINGS FOR MORE INFORMATION
- 815 ALCOHOL LICENSE NUMBER ; OWNER FURNISHED, OWNER INSTALLED
- 816 LINE OF ROOF TOP MECHANICAL EQUIPMENT BEYOND - SEE MECHANICAL DRAWINGS FOR MORE INFORMATION
- 817 EXTERIOR LIGHT FIXTURE - VERIFY COLOR WITH OWNER PRIOR TO CONSTRUCTION - SEE ELECTRICAL DRAWINGS FOR MORE INFORMATION
- 818 ELECTRIC POWER OULET - SEE ELECTRICAL DRAWINGS FOR MORE INFORMATION
- 819 FREEZELESS WALL HYDRANT ASSEMBLY - SEE PLUMBING DRAWINGS FOR MORE INFORMATION
- 821 MEMBRANE ROOFING SYSTEM.
- 822 VERIFY FINAL LOCATION OF EMERGENCY GAS SHUT OFF WITH FUEL SYSTEM VENDOR - MOUNTING HEIGHT TO BE 4'-0" ABOVE FINISH GRADE.
- 823 ELECTRIC SERVICE EQUIPMENT, PAINTED:STEALTH GREY - SEE ELECTRICAL DRAWINGS FOR MORE INFORMATION.
- 824 SEE PLUMBING DRAWINGS FOR GAS SERVICE INFORMATION AND REQUIREMENTS.
- 825 BUILDING ADDRESS AND STORE NUMBER LOCATION.
- 826 PANEL SYSTEM VERTICAL EXPANSION JOINT LOCATION - INSTALL PER MANUFACTURER.
- 827 ALUMIUNUM SCREEN WALL SYSTEM - SEE ROOF PLAN FOR MORE INFORMATION.

RECEIVED
MAR 10 2016
PLANNING &
DESIGN SERVICES

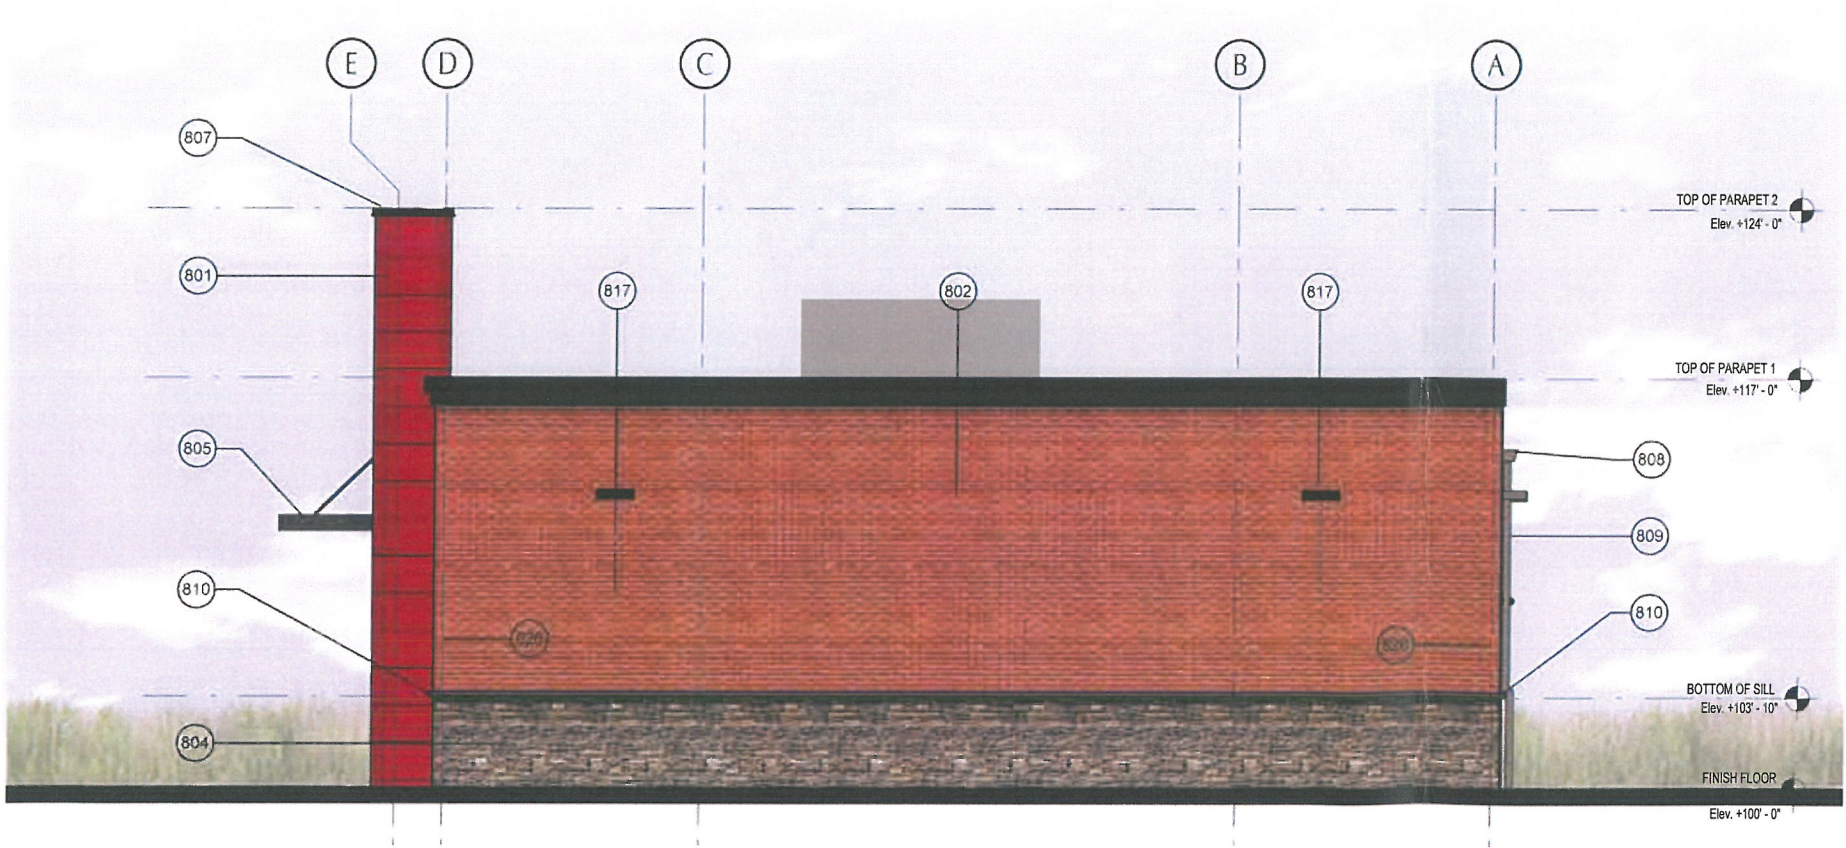


[illegible]

(Facing West, ~~Watterson~~ Ramp / Brownboro Rd KY22)

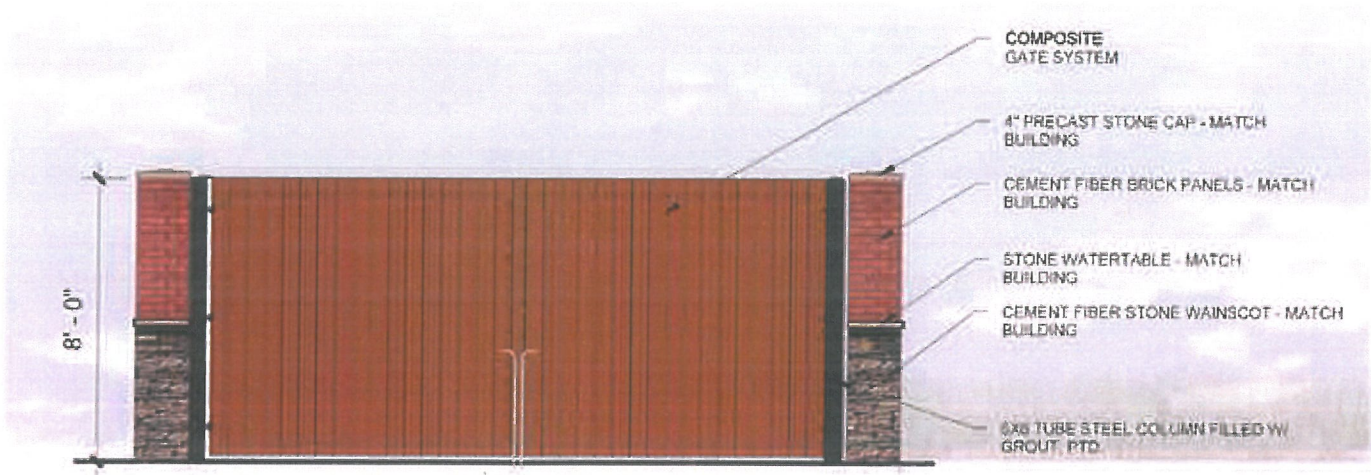


RECEIVED
MAR 10 2016
PLANNING &
DESIGN SERVICES

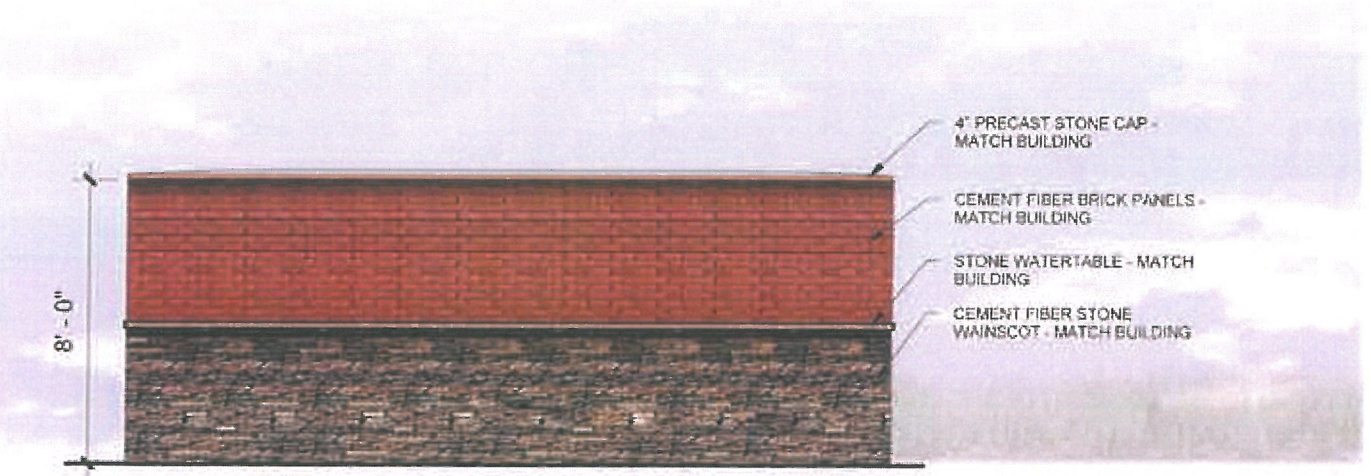

RECEIVED

MAR 10 2016
PLANNING &
DESIGN SERVICES

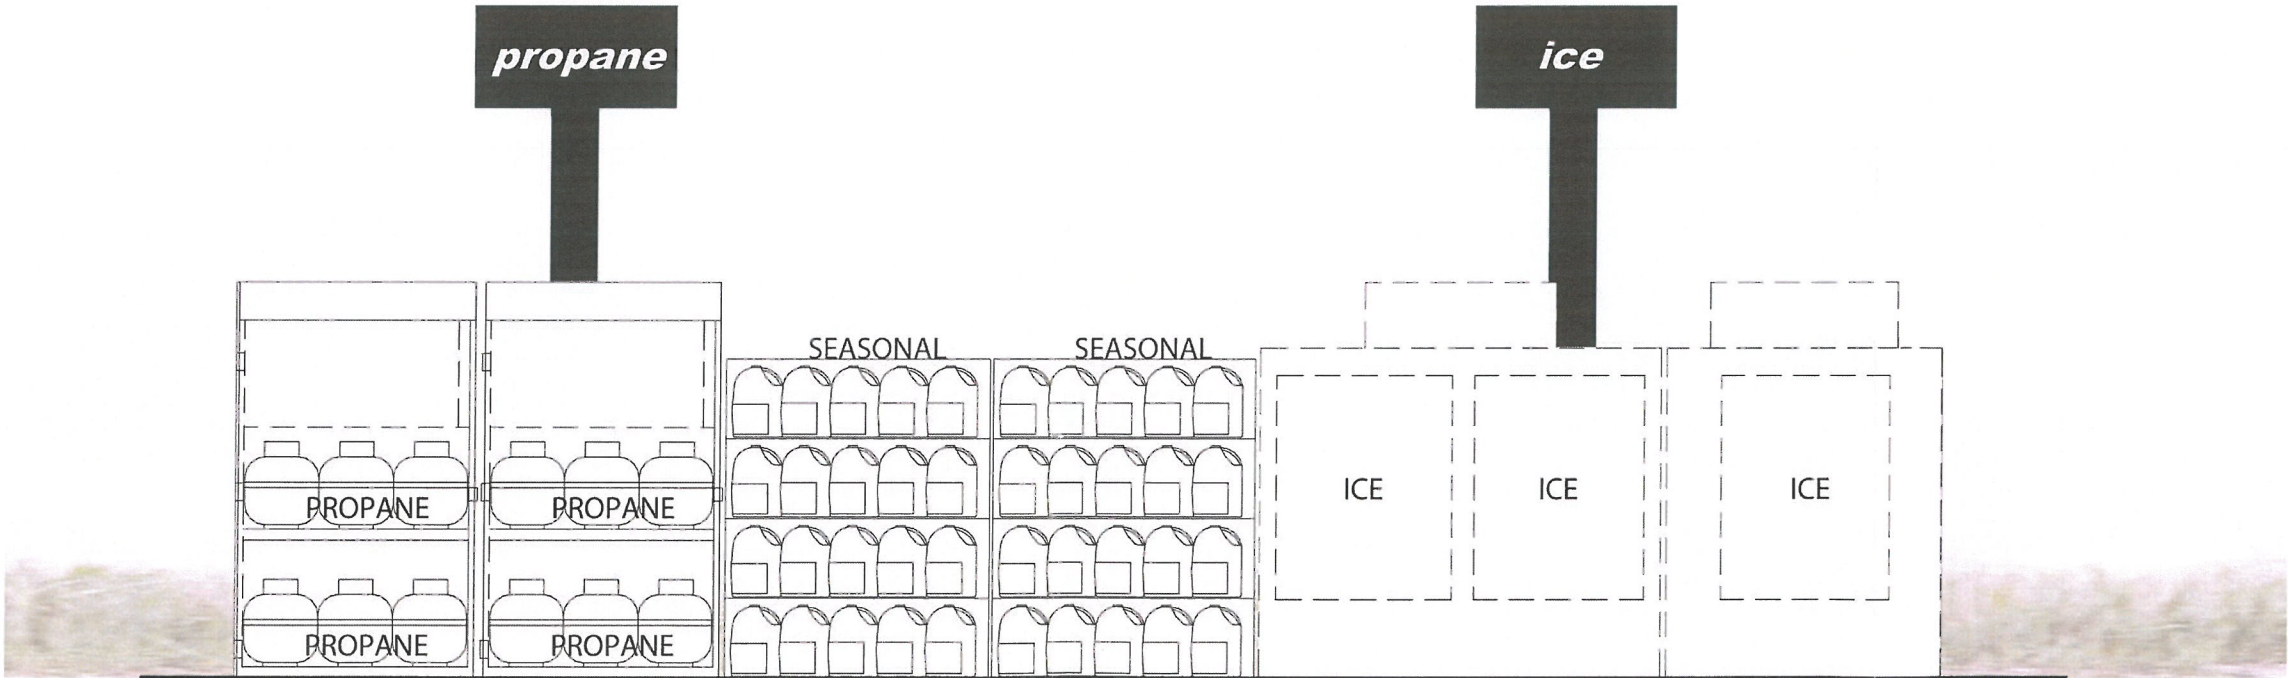

Seasonal / Propane / Ice Elevation - scale 3/4" = 1'