



RECEIVED
 10/10/2016
 DESIGN SERVICES


1 FRONT ELEVATION
 1/8" = 1'-0"

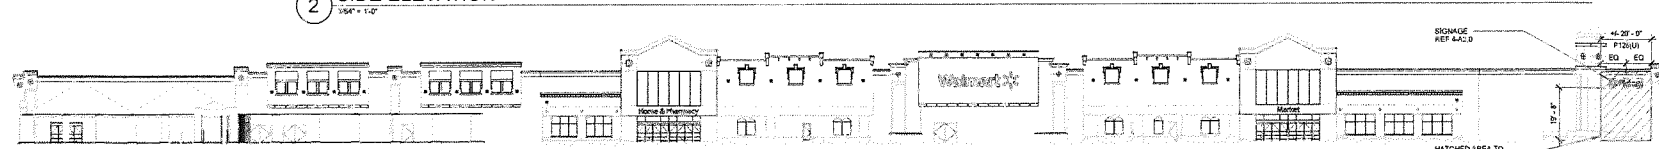


2 SIDE ELEVATION
 1/8" = 1'-0"

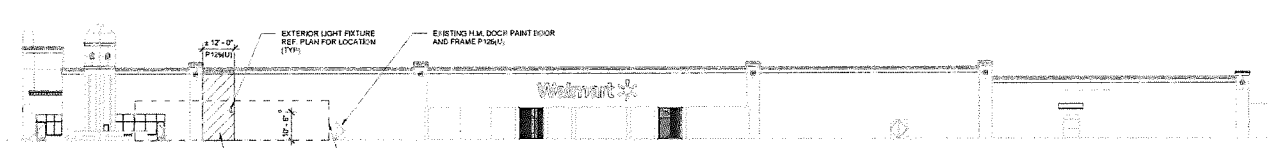


5 ELECTRICAL FLOOR PLAN
 1" = 50'-0"

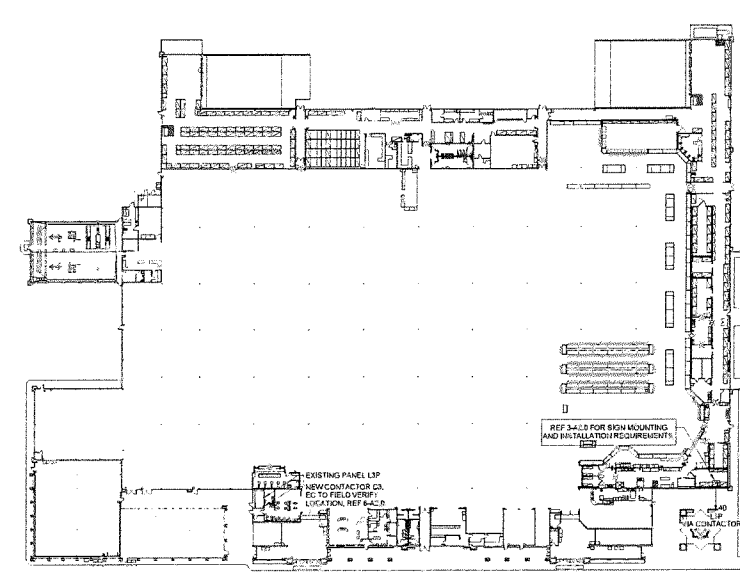


6 CONTACTOR DIAGRAM
 NTS

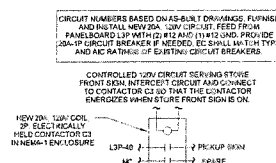

4 2' 6" PICKUP
 1/4" = 1'-0"

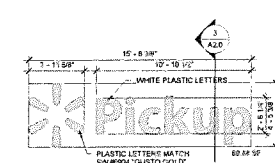

3 SIGN ATTACHMENT
 1" = 1'-0"

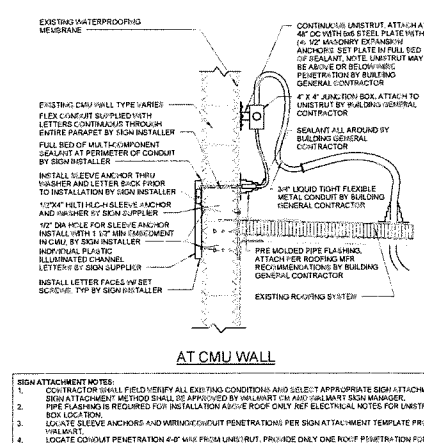

SIGNAGE SCHEDULE			
FRONT	QTY	COLOR	INDIVIDUAL AREA
PICKUP SIGNAGE			
INTERIALLY ILLUMINATED			
2' 6"	1	WHITE	60 SF
2' 6"	1	YELLOW	60 SF
TOTAL FRONT SIGNAGE			120 SF
CALCULATIONS ARE BASED ON BOX METHOD			
CANOPY DIRECTIONAL SIGNAGE SCHEDULE			
CANOPY DIRECTIONAL	QTY	COLOR	INDIVIDUAL AREA
LETTERING			
Order online, Pick up here	1	WHITE	6.51 SF
TOTAL FRONT SIGNAGE			6.51 SF
CALCULATIONS ARE BASED ON BOX METHOD			

SHEET NOTES	
1.	ALL EXISTING FINISHES TO REMAIN (UNLESS NOTED OTHERWISE)
2.	PATCH AND REPAIR EXTERIOR WALL SURFACES, DAMAGED OR EXPOSED DUE TO REMOVAL OF BUILDING MOUNTED ITEMS, TO MATCH ADJACENT AS REQUIRED.
3.	PAINT EXTERIOR OF BUILDING AS SHOWN PRIOR TO PAINTING WALL AT LOCATION (1) OF INTERNALLY ILLUMINATED SIGNAGE.
4.	DO NOT PAINT LED WALL FACE SIGNAGE.
5.	IN AREAS TO RECEIVE NEW PAINT, PAINT DOOR HOODS, GUTTERS, AND DOWNPOUTES. SUPPLY METAL FLASHING, HANDWALLS, GAS LINES AND EXPOSED MISC. CLAMOROUS FREE TO MATCH ADJACENT BUILDING COLOR LINE.
COLOR LEGEND	
P12(U)	KNOCKOUT ORANGE
SF	WALLS LIFETIME

HFA ARCHITECTS
 1705 S. Walton Blvd., Suite 2
 Brentsville, Arkansas 72712
 1-877-271-7786
 FMS-204 NEN
 www.hfa-arc.com

STIPULATION FOR REUSE

THIS DOCUMENT IS THE PROPERTY OF HFA ARCHITECTS. IT IS TO BE USED ONLY FOR THE PROJECT AND SITE SPECIFICALLY IDENTIFIED HEREIN. IT IS NOT TO BE REPRODUCED, COPIED, OR TRANSMITTED IN ANY FORM OR BY ANY MEANS, ELECTRONIC OR MECHANICAL, INCLUDING PHOTOCOPYING, RECORDING, OR BY ANY INFORMATION STORAGE AND RETRIEVAL SYSTEM, WITHOUT THE WRITTEN PERMISSION OF HFA ARCHITECTS.

Walmart
 LOUISVILLE, KY
 STORE NO. 3254-223
 22-16-0002 PHOTO

ISSUE BLOCK

NO.	DATE	DESCRIPTION

CHECKED BY: WAM
 DRAWN BY: DWP
 FILE NAME: PICKUP-A-2
 PHOTO CYCLE
 DOCUMENT DATE: 09/20/2016

NOT FOR CONSTRUCTION

PICKUP PLANS EXTERIOR ELEVATIONS AND SIGNAGE

SHEET
 A2.0