





# MARIETTA by TYREE HOUSE PLANS

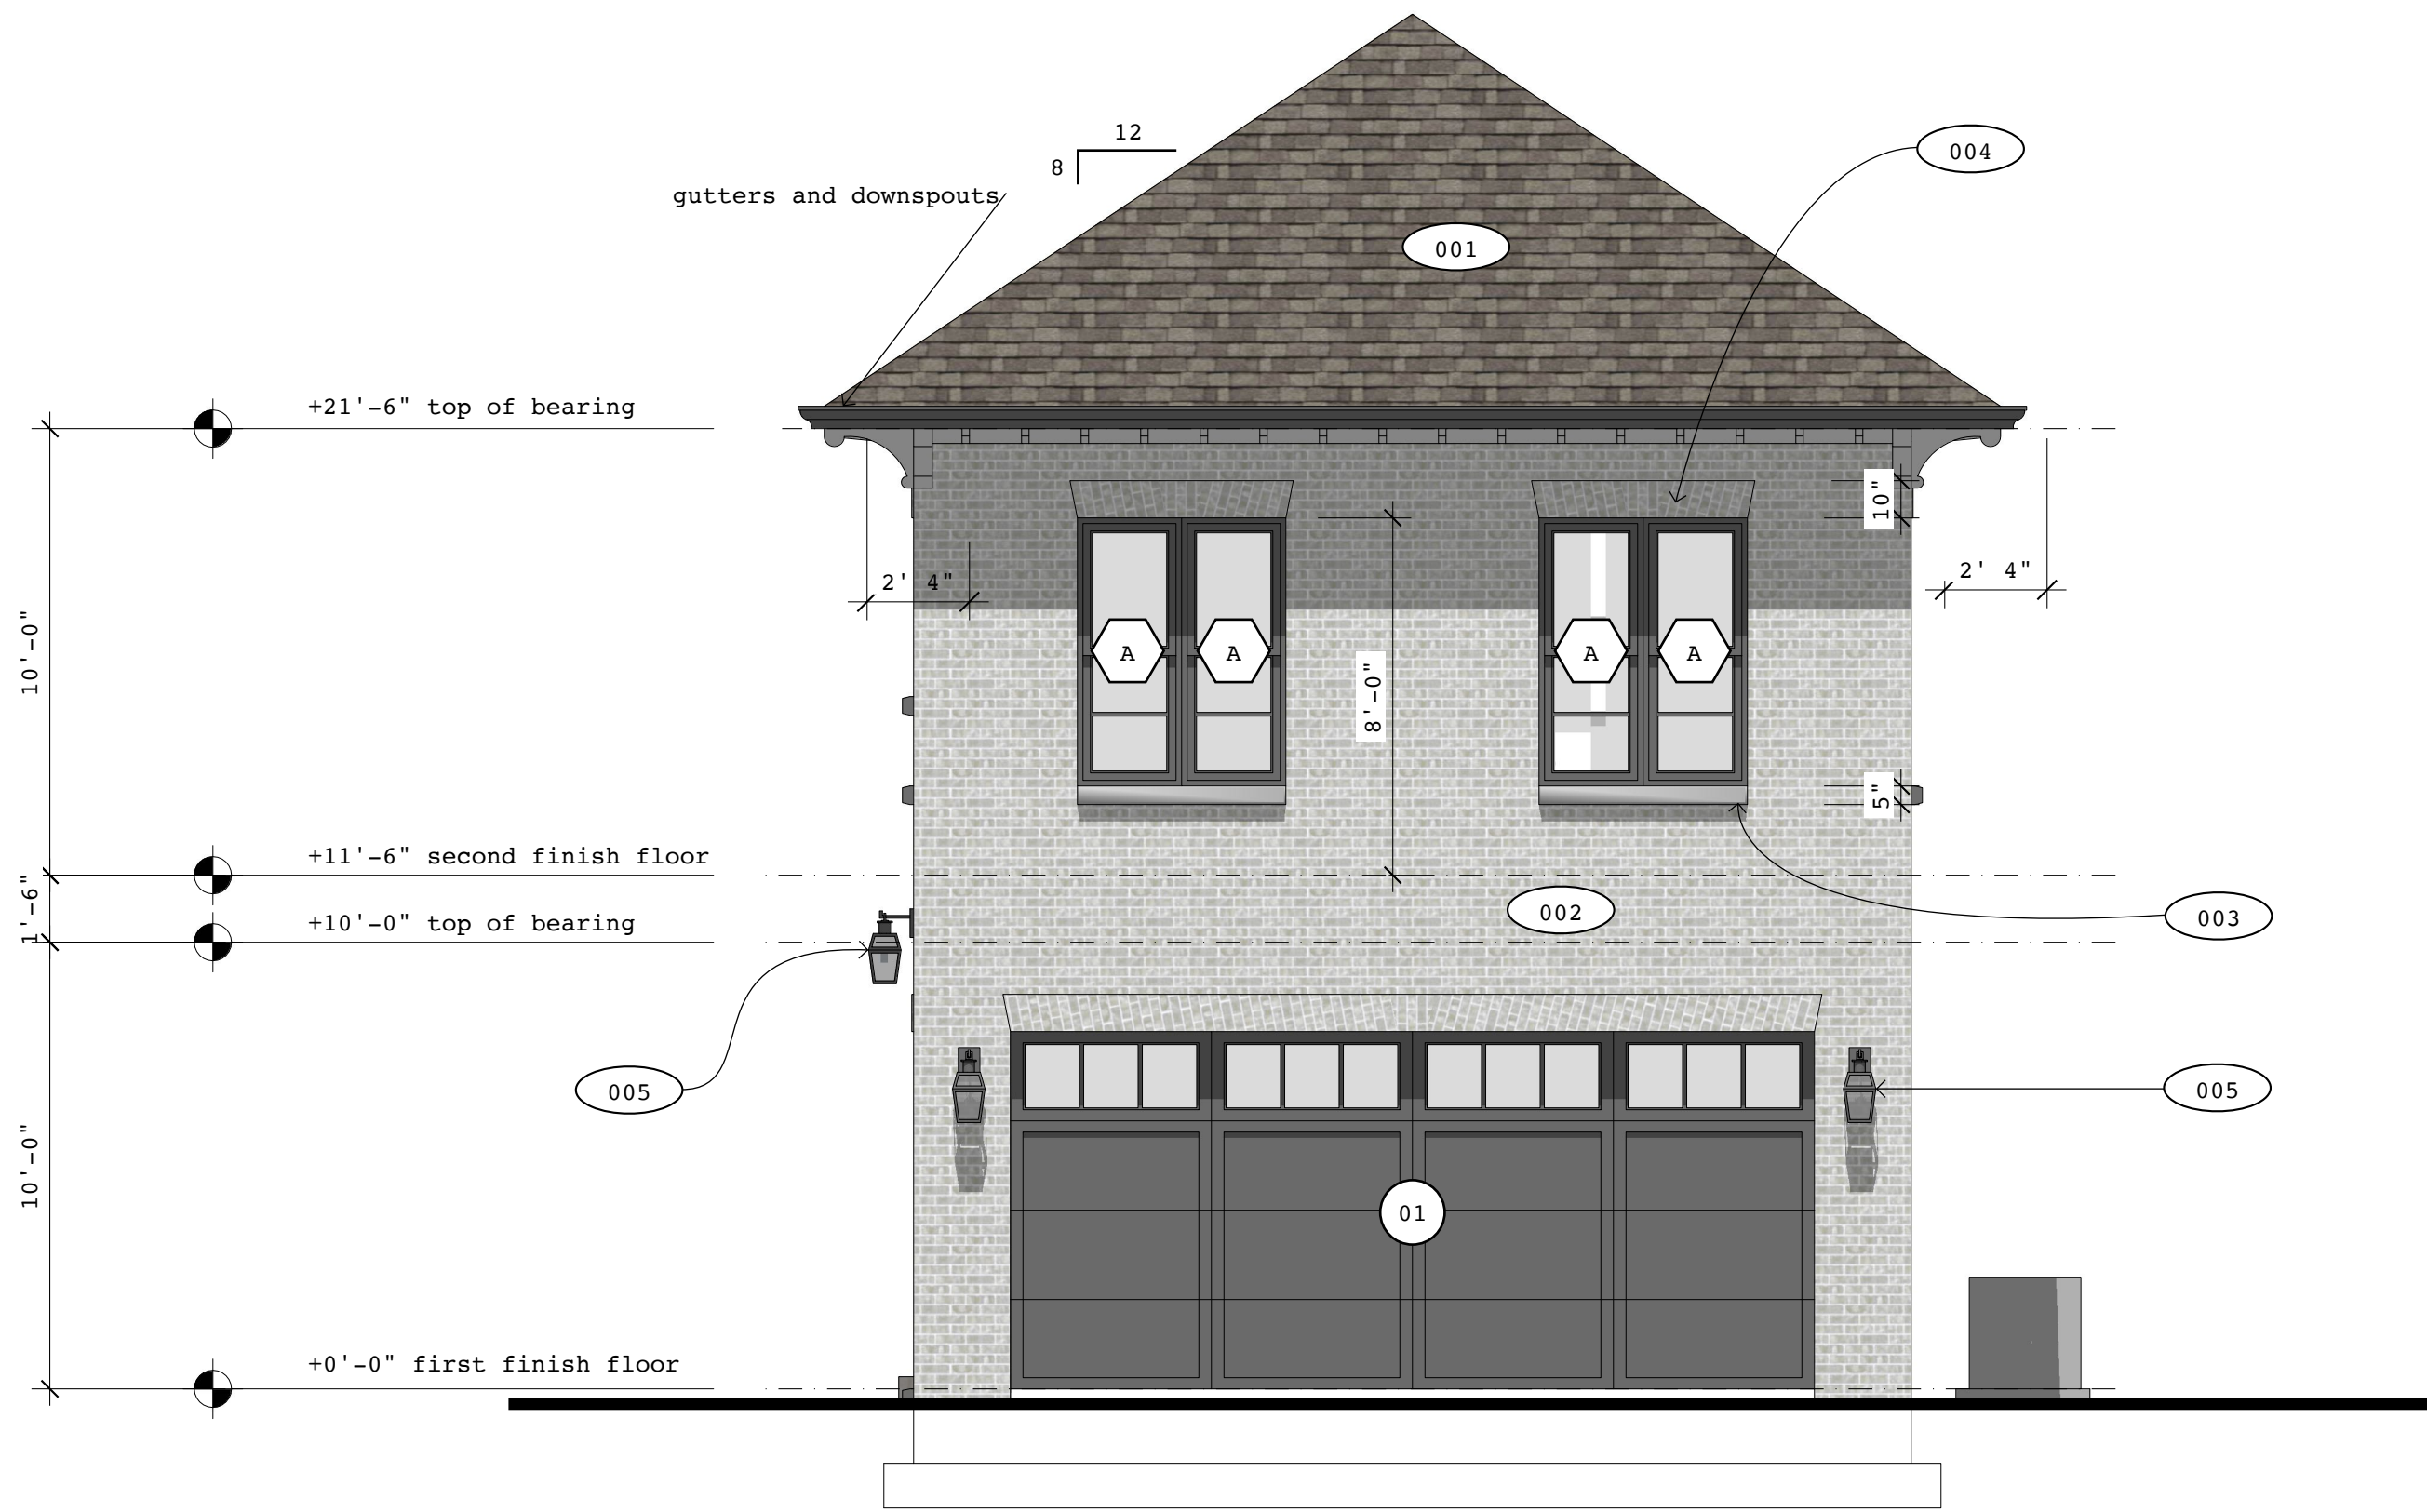

Front Exterior Elevation  
scale: 1/4" = 1'-0"

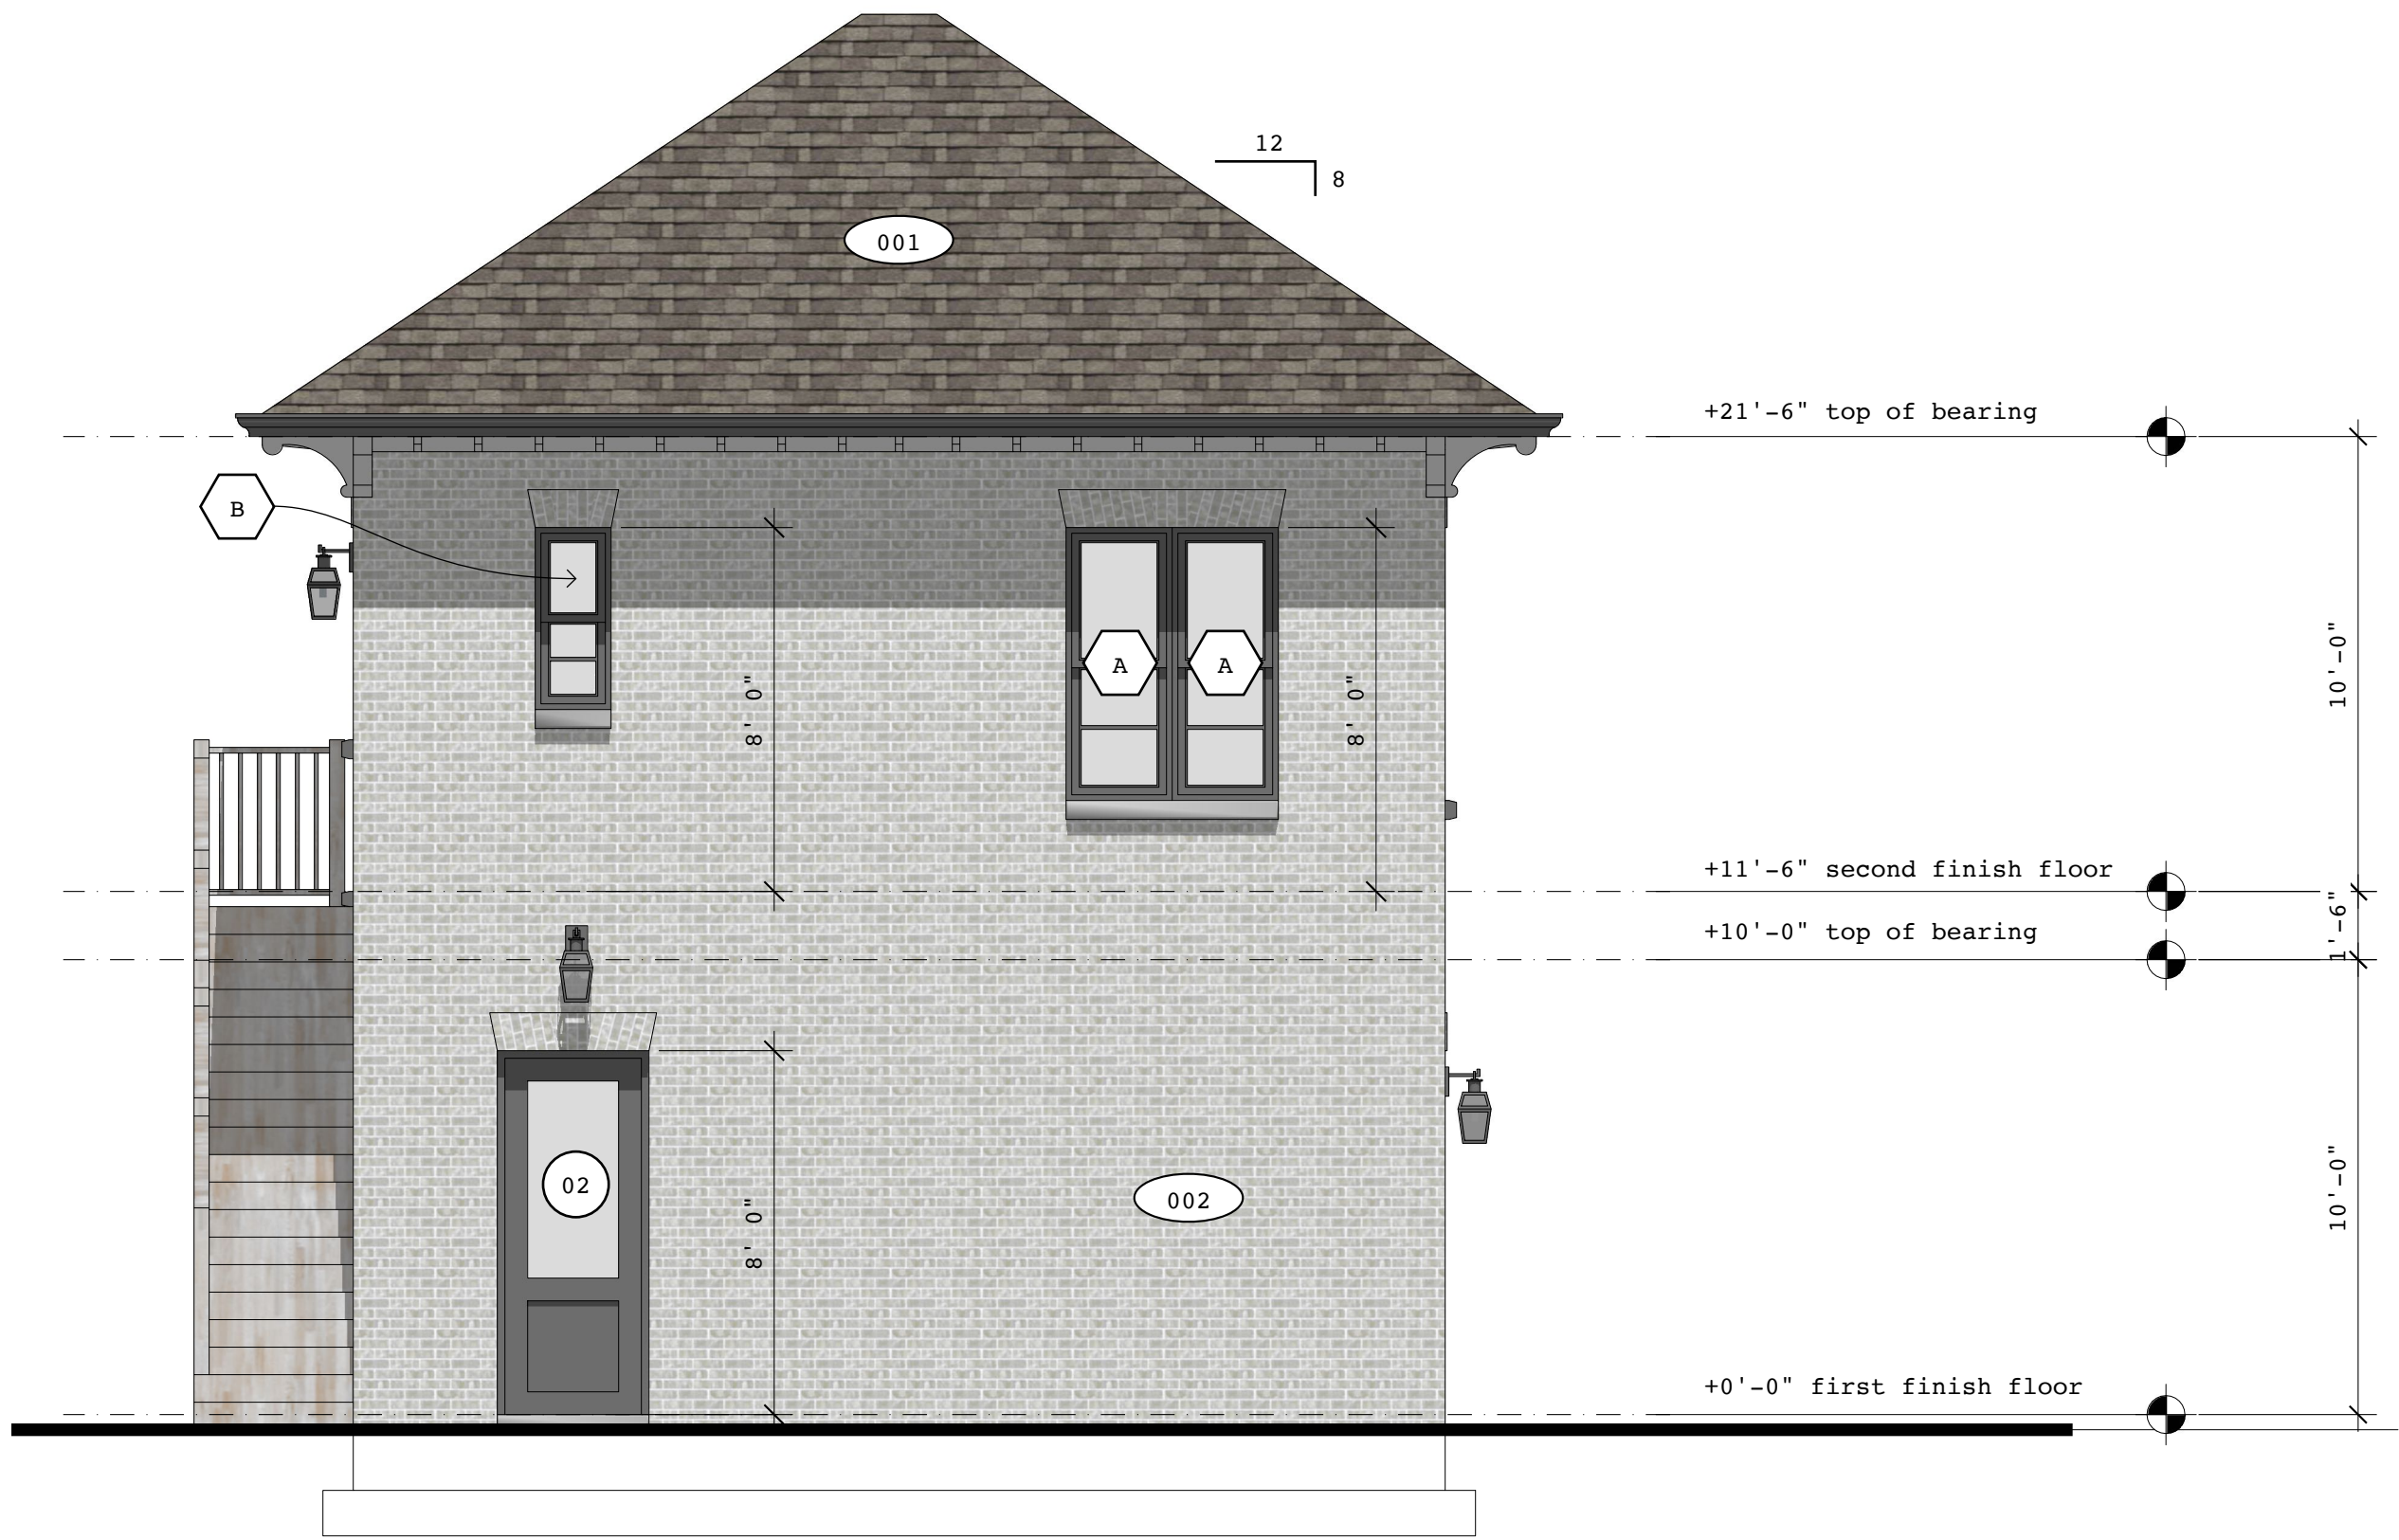

Left Side Exterior Elevation  
scale: 1/4" = 1'-0"

Finish Schedule

|     |                                                           |
|-----|-----------------------------------------------------------|
| 001 | 40 year asphalt shingles                                  |
| 002 | brick coursing                                            |
| 003 | granite sills                                             |
| 004 | decorative brickwork at door and window lintels (typical) |
| 005 | carriage light                                            |
| 006 | -                                                         |
| 007 | -                                                         |

Important:

Contractor to verify all window and door sizes, incorporating floor, wall and all other finish material thicknesses into sizing, and adjust accordingly. Contractor to verify and adjust window sizing as required for egress, based on owner-selected window manuf. Provide tempered glass at all required locations.

Door Schedule

| quantity | -  | width<br>(nominal) | height<br>(nominal) | action   | panels   | location | notes       |
|----------|----|--------------------|---------------------|----------|----------|----------|-------------|
| 1        | 01 | 18'-0"             | 8'-0"               | overhead | multiple | exterior | garage door |
| 2        | 02 | 3'-0"              | 8'-0"               | swing    | 1        | exterior | -           |
| 4        | 03 | 2'-8"              | 8'-0"               | swing    | 1        | interior | -           |
| 1        | 04 | 2'-6"              | 8'-0"               | swing    | 1        | interior | -           |
| 1        | 05 | 1'-4"              | 8'-0"               | swing    | 1        | interior | -           |
|          |    |                    |                     |          |          |          |             |
|          |    |                    |                     |          |          |          |             |

Window Schedule

| quantity | - | width<br>(nominal) | height<br>(nominal) | action      | notes |
|----------|---|--------------------|---------------------|-------------|-------|
| 10       | A | 2'-4"              | 6'-0"               | casement    | -     |
| 1        | B | 1'-8"              | 4'-0"               | double hung | -     |
| 3        | C | 2'-4"              | 4'-8"               | double hung | -     |
|          |   |                    |                     |             |       |
|          |   |                    |                     |             |       |

tyreehouseplans.com

865-269-2611

sales@tyreehouseplans.com

PO Box 51702  
Knoxville, TN 37950

IMPORTANT DATES

These house plan documents were released on August 25, 2021

AREA CALCULATIONS

505 sf Floor1  
505 sf Floor2  
505 sf Total Living  
505 sf Garages  
505 sf Porches  
1,010 sf Under Roof

CUSTOMIZE

We can change this house plan to fit your needs. To get a free quote and design sketches, go to tyreehouseplans.com/customize

COPYRIGHT

Tyree House Plans (THP) reserves the rights to these documents and to all designs contained herein. No copies or alterations are to be made without written permission. All plans designed by THP are protected under Federal Copyright Act, Title 17 of the United States Code, and Chapter 37 of the Code of Federal Regulations.

DISCLAIMER

Placement of residence is based on owner's desired location and governing authority regulations. Every property has inherent risks due to location and acts of God which may cause damage to structures built on said property and bodily injury or death to the occupants of said structures. THP does not in any way guarantee the suitability of any area for construction or habitation, and will not be held liable for damages based on the location of said structure. General Contractor to verify all field conditions, code requirements, insure compliance of proposed structure with said conditions, verify all dimensions and techniques in construction documents, and notify THP of any discrepancies before construction.

 
INDEX OF PAGES

- 01 Floor Plans
- 02 Exterior Elevations
- 03 Exterior Elevations
- 04 Building Section, Wall Section
- 05 Foundation Plan
- 06 Floor Framing Plan, Roof Plan
- 07 Notes
- 08 Electrical Plans





# MARIETTA by TYREE HOUSE PLANS



tyreehouseplans.com



865-269-2611



sales@tyreehouseplans.com



PO Box 51702  
Knoxville, TN 37950

## IMPORTANT DATES

These house plan documents were released on August 25, 2021

## AREA CALCULATIONS

+ sf Floor1  
505 sf Floor2  
505 sf Total Living  
505 sf Garages  
sf Porches  
1,010 sf Under Roof

## CUSTOMIZE

We can change this house plan to fit your needs. To get a free quote and design sketches, go to [tyreehouseplans.com/customize](https://tyreehouseplans.com/customize)

## COPYRIGHT


Tyree House Plans (THP) reserves the rights to these documents and to all designs contained herein. No copies or alterations are to be made without written permission. All plans designed by THP are protected under Federal Copyright Act, Title 17 of the United States Code, and Chapter 37 of the Code of Federal Regulations.

## DISCLAIMER


Placement of residence is based on owner's desired location and governing authority regulations. Every property has inherent risks due to location and acts of God which may cause damage to structures built on said property and bodily injury or death to the occupants of said structures. THP does not in any way guarantee the suitability of any area for construction or habitation, and will not be held liable for damages based on the location of said structure. General Contractor to verify all field conditions, code requirements, insure compliance of proposed structure with said conditions, verify all dimensions and techniques in construction documents, and notify THP of any discrepancies before construction.

## INDEX OF PAGES


- 01 Floor Plans
- 02 Exterior Elevations
- 03 Exterior Elevations
- 04 Building Section, Wall Section
- 05 Foundation Plan
- 06 Floor Framing Plan, Roof Plan
- 07 Notes
- 08 Electrical Plans

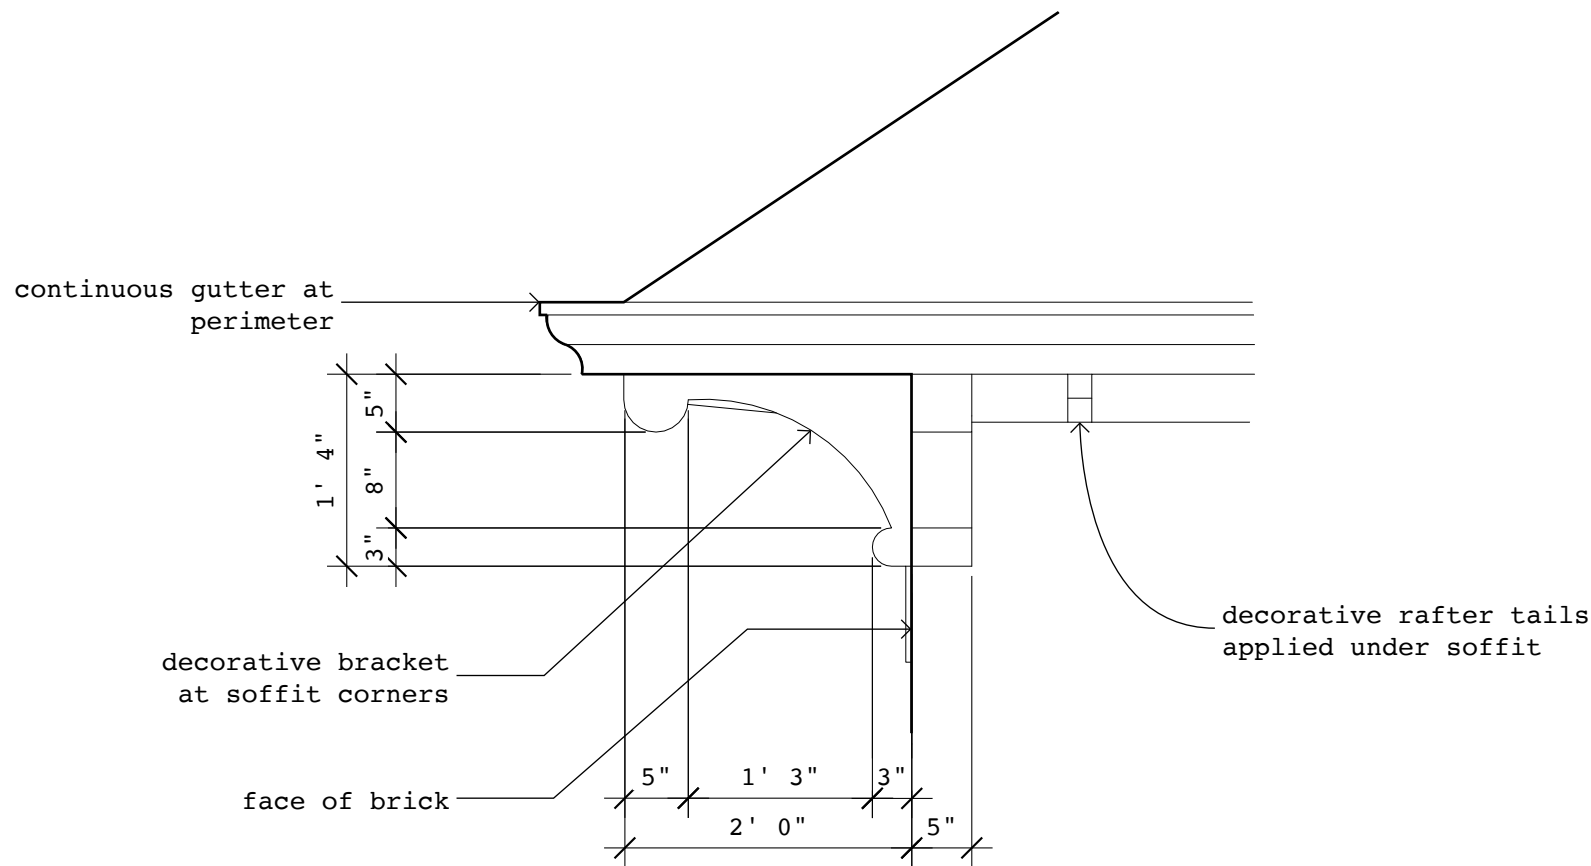

**Soffit Detail**  
scale: 3/4" = 1'-0"

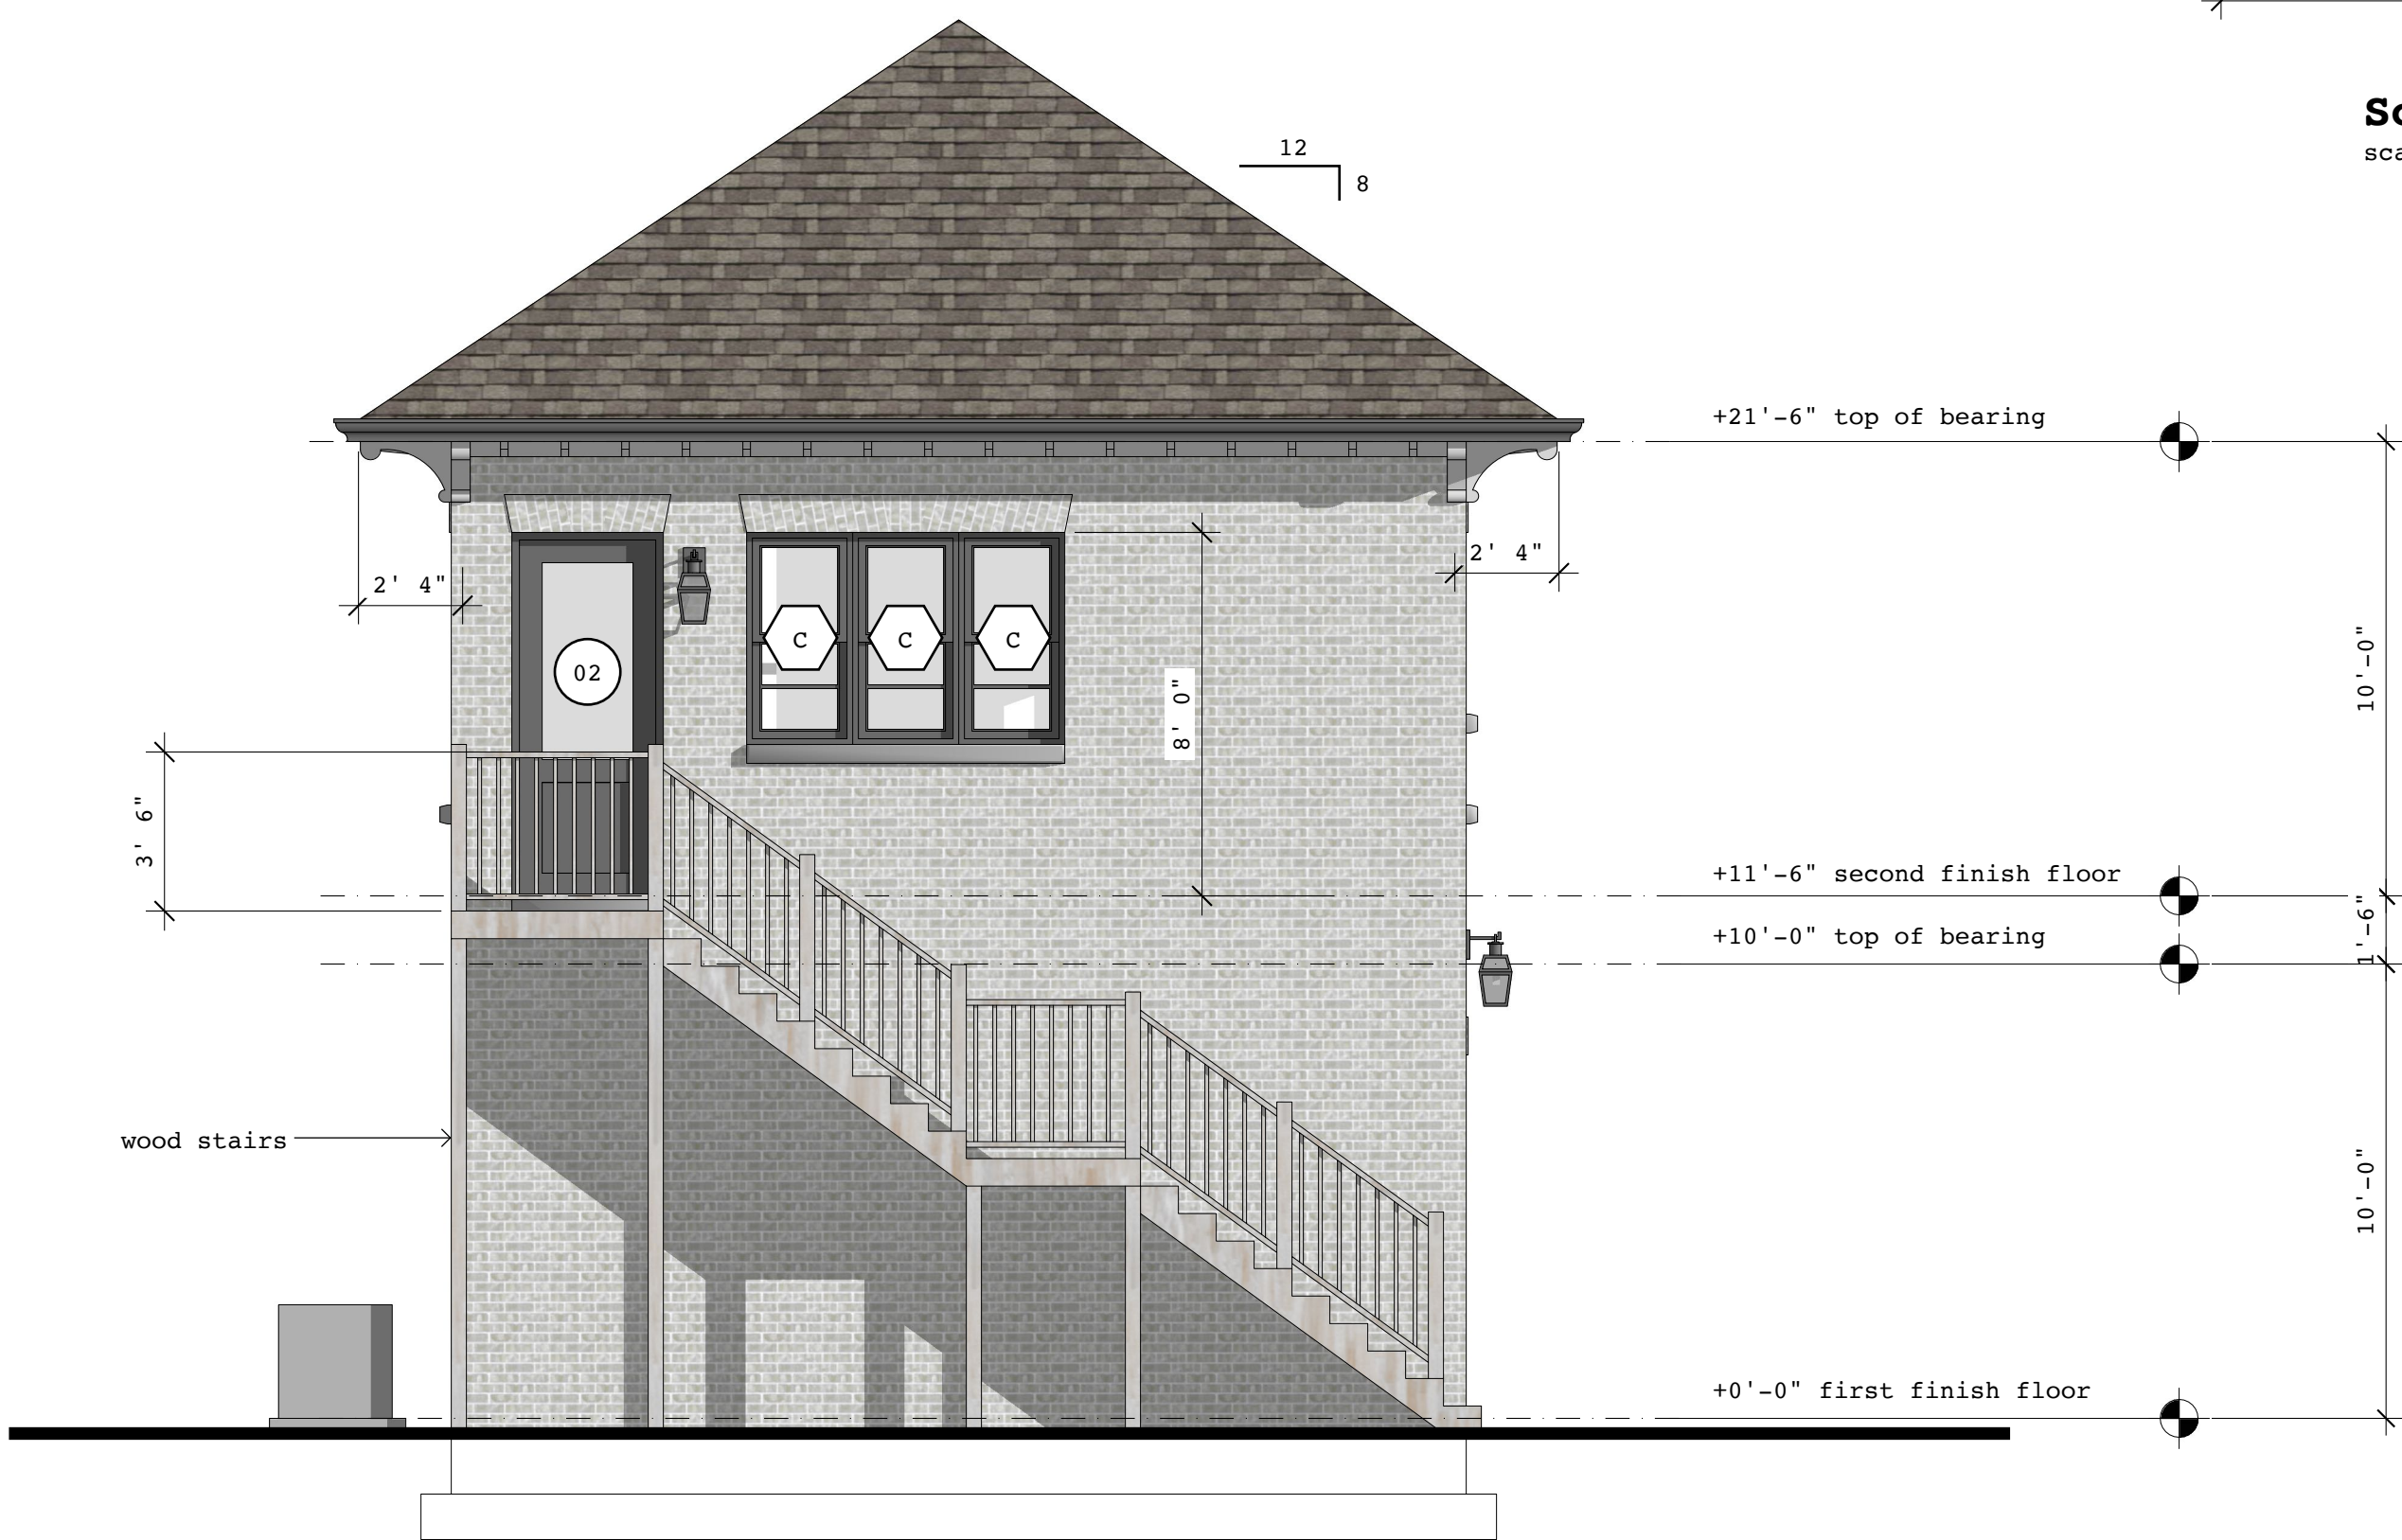

**Rear Exterior Elevation**  
scale: 1/4" = 1'-0"

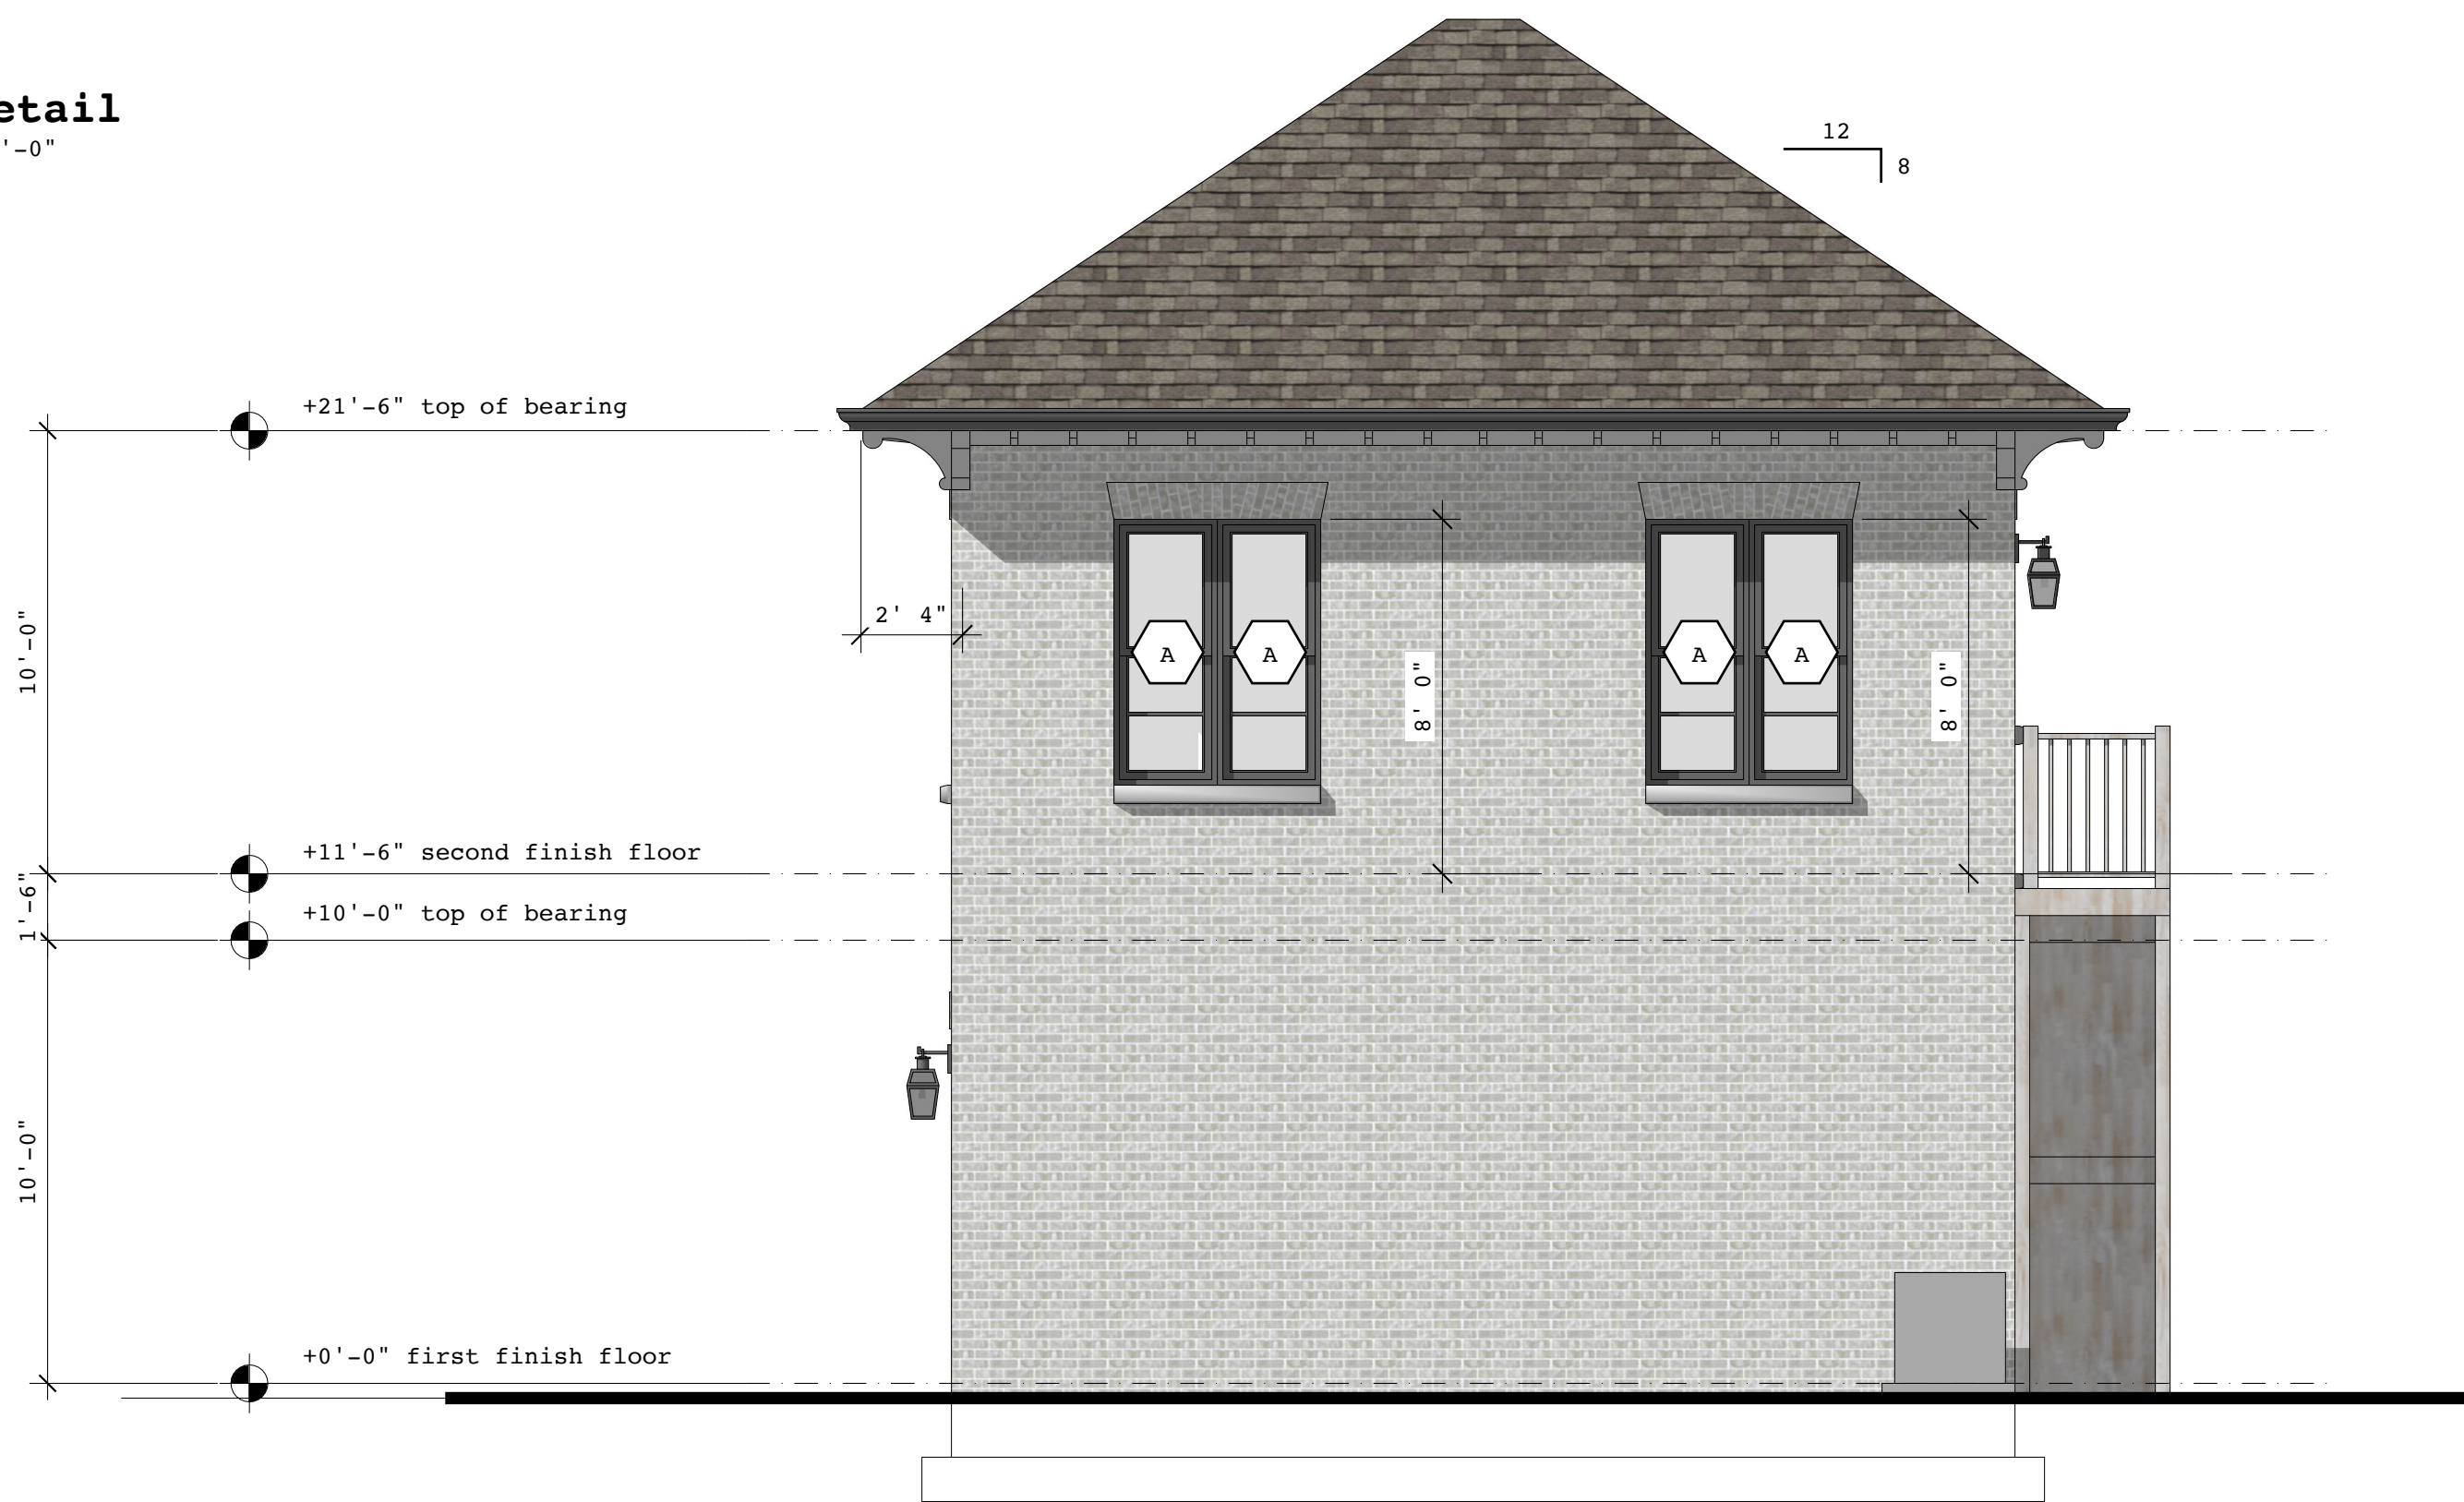

**Right Side Exterior Elevation**  
scale: 1/4" = 1'-0"