


T/O RIDGE 3
EL. 132'-7"

MEAN HEIGHT LEVEL
EL. 127'-5"

T/O RIDGE 2
EL. 125'-11"

T/O RIDGE 1
EL. 123'-8"

FINISH FLOOR
EL. 100'-0"

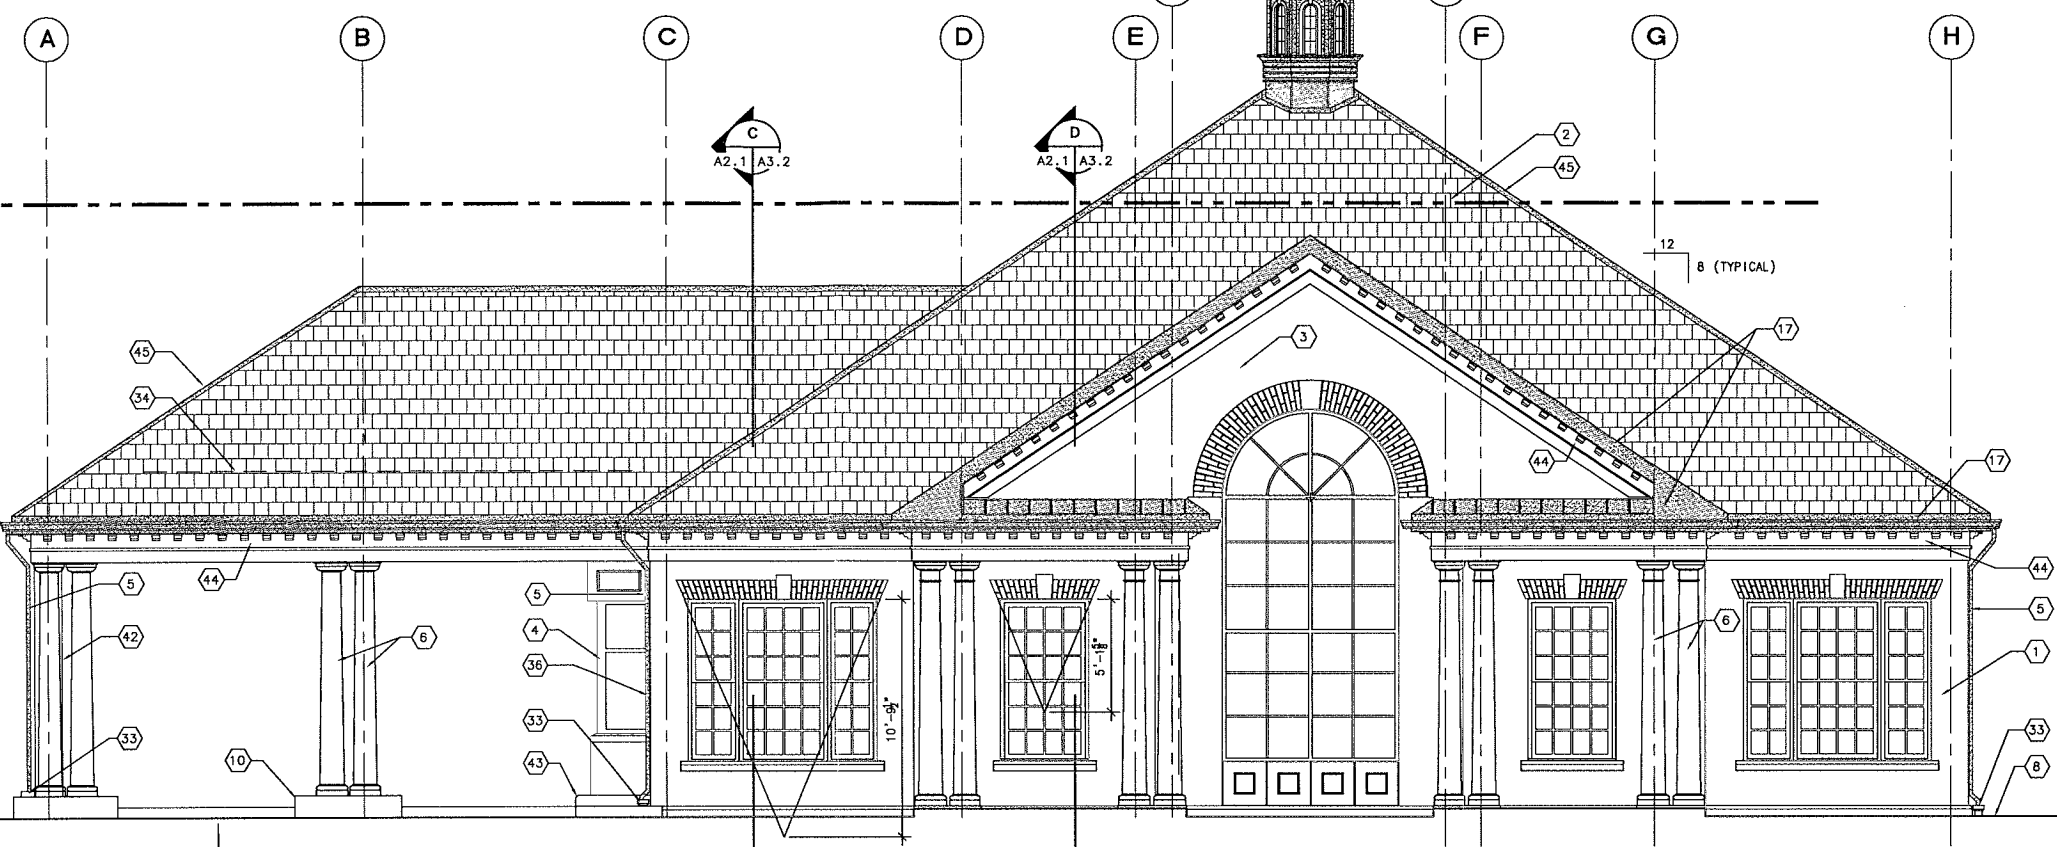

FRONT (NORTH)
ELEVATION
SCALE: 1/4"=1'-0"

A
A1.1 A2.1

KEYNOTES

NOT ALL KEYNOTES USED ON EACH SHEET

1. BRICK VENEER (TYPICAL).
2. SLATE ROOFING (TYPICAL).
3. EXTERIOR INSULATED FINISH SYSTEM (E.I.F.S.).
4. TELLER WINDOW BEYOND.
5. COPPER DOWNSPOUT.
6. COLUMN GFRC (TYPICAL).
7. MASONRY PIER, REFER TO STRUCTURAL DRAWINGS.
8. APPROX. FINISH GRADE, REFER TO CIVIL DRAWINGS.
9. PROFILE OF GABLE BEYOND.
10. CONCRETE CURB/ISLAND, REFER TO STRUCTURAL DRAWINGS.
11. COLUMN BEYOND, GFRC (TYPICAL).
12. MASONRY PIER BEYOND.
13. SUSPENDED ACOUSTICAL TILE GRID SYSTEM, REFER TO A8.1 SPECIFICATIONS.
14. TELLER COUNTER.
15. CHECK DESK.
16. RAILING.
17. COPPER GUTTER AND FASCIA.
18. LIGHT FIXTURE (TYPICAL), REFER TO ELECTRICAL DRAWINGS.
19. PAVEMENT AT DRIVE-THROUGH, REFER TO STRUCTURAL DRAWINGS.
20. GYPSUM BOARD CEILING SYSTEM.
21. 5/8" THICK EXTERIOR DRYWALL SYSTEM.
22. FINISH FLOOR.
23. COMBUSTION AIR LOUVER, REFER TO MECHANICAL DRAWINGS.
24. OUTSIDE AIR INTAKE LOUVER, REFER TO MECHANICAL DRAWINGS.
25. WALL PACK LIGHT FIXTURE, REFER TO ELECTRICAL DRAWINGS.
26. BRICK EXHAUST VENT, REFER TO MECHANICAL DRAWINGS.
27. GAS VENT, REFER TO MECHANICAL DRAWINGS.
28. PLUMBING VENT REFER TO PLUMBING DRAWINGS.
29. ELECTRICAL METER, REFER TO ELECTRICAL DRAWINGS.
30. GAS METER, REFER TO CIVIL AND MECHANICAL DRAWINGS.
31. CONDENSING UNIT, REFER TO CIVIL AND MECHANICAL DRAWINGS.
32. LINTEL, ANGLE 5 X 5 X 3/4" WITH 8" BEARING EACH END, PAINT.
33. DOWNSPOUT BOOT, REFER TO CIVIL DRAWINGS.
34. INDICATES SNOW GUARD LOCATION.
35. WALL SCONCE, REFER TO ELECTRICAL DRAWINGS.
36. MASONRY CONTROL JOINT.
37. STEEL TRUSS, REFER TO STRUCTURAL DRAWINGS.
38. ROOF STRUCTURE, REFER TO STRUCTURAL DRAWINGS.
39. LIGHT GAGE FRAMING, REFER TO STRUCTURAL DRAWINGS.
40. BOTTOM OF LIGHT GAGE TRUSS CHORD, REFER TO STRUCTURAL DRAWINGS.
41. FASCIA AND CROWN MOLDING, GFRC.
42. FACE OF BRICK PIER BEYOND.
43. CONCRETE CURB.
44. FASCIA, SOFFIT & DENTIL, GFRC.
45. COPPER HIP & RIDGE FLASHING.
46. CONCENTRIC VENTS, SEE MECHANICAL DRAWINGS.
47. BACK UP GENERATOR DISCONNECT, REFER TO ELECTRICAL DRAWINGS.
48. EXHAUST AIR LOUVER, REFER TO MECHANICAL DRAWINGS.

LEFT (EAST)
ELEVATION

SCALE: 1/4"=1'-0"

B
A1.1 A2.1


T/O RIDGE 3
EL. 132'-7"

MEAN HEIGHT LEVEL
EL. 127'-5"

T/O RIDGE 2
EL. 125'-11"

T/O RIDGE 1
EL. 123'-8"

FINISH FLOOR
EL. 100'-0"

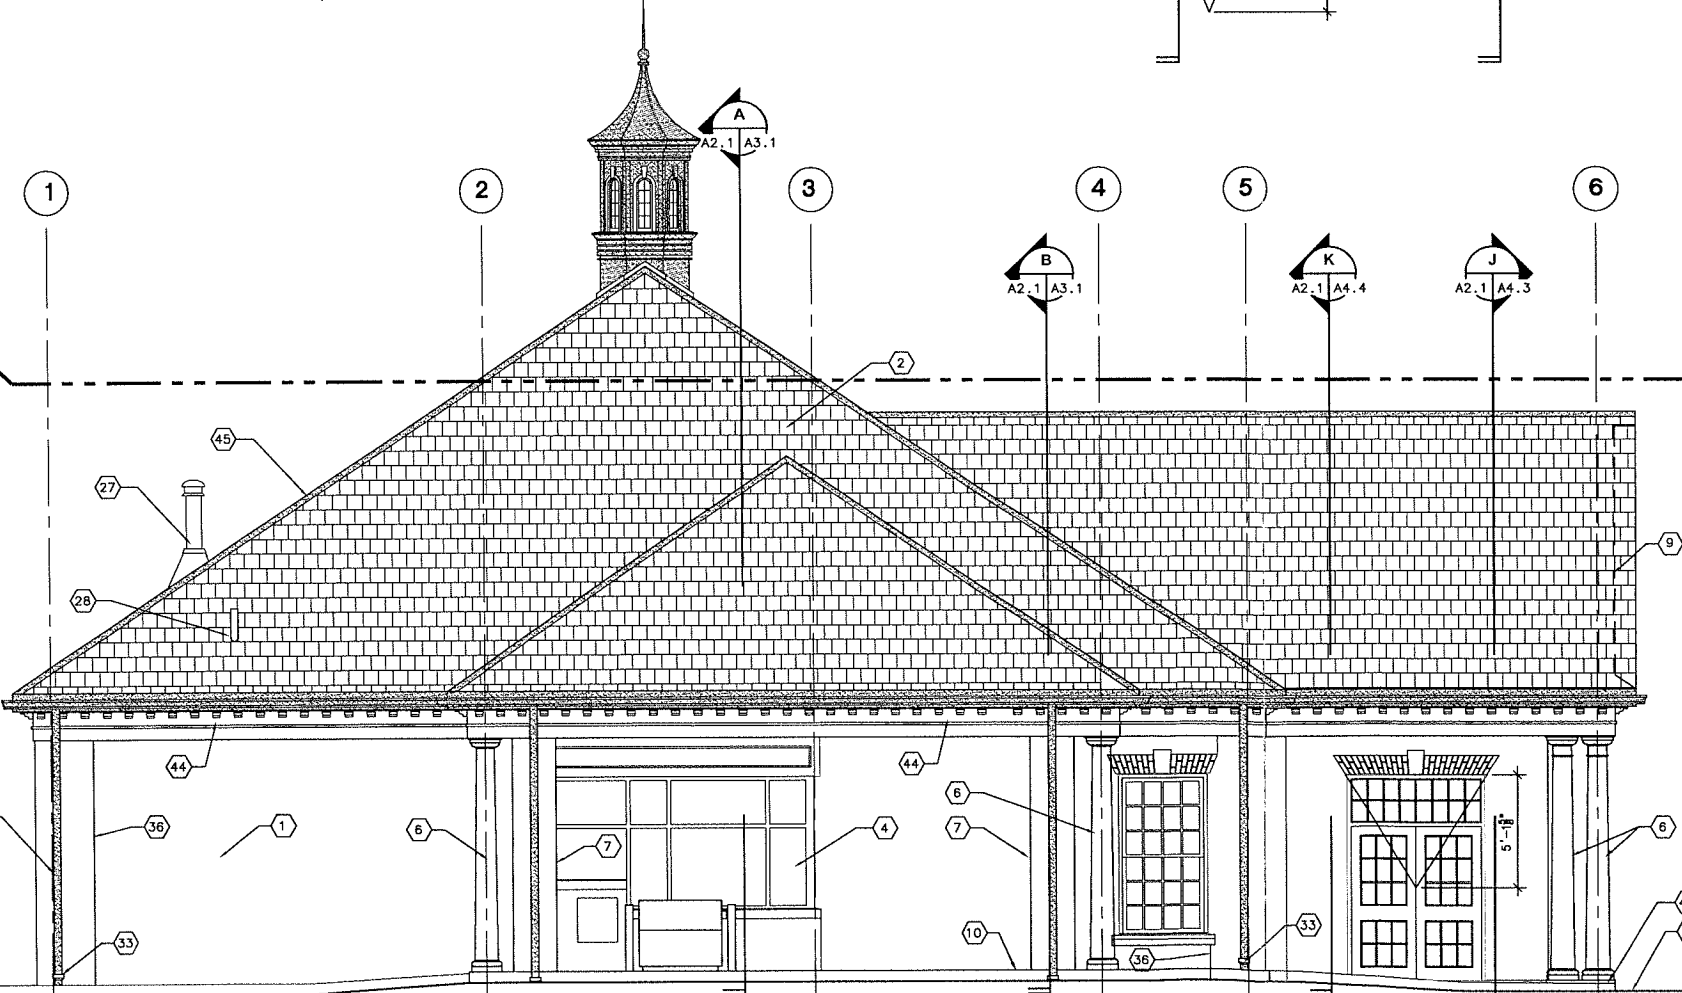

737 South Third Street
Louisville, KY 40202
502-585-4181
www.luckett-farley.com

[smart design]SM
Luckett & Farley
Architecture | Engineering | Interior Design

RIVER CITY BANK
14000 SHELBYVILLE ROAD
LOUISVILLE, KY 40245



DATE	5/2/15
REVISIONS	1. DATE OF REVIEW 4/19/15
1. DATE OF REVIEW	4/19/15
2. REVISIONS	
3. REVISIONS	
4. REVISIONS	
5. REVISIONS	
6. REVISIONS	
7. REVISIONS	
8. REVISIONS	
9. REVISIONS	
10. REVISIONS	

CDMA NO.	2015.137
MADE BY	CNN
CHECKED	
DATE	04/18/16
EXTERIOR ELEVATIONS	
DRAWING NO.	A2.1
BD PKG.	

T/O RIDGE 3
EL. 132'-7"

MEAN HEIGHT LEVEL
EL. 127'-5"

T/O RIDGE 2
EL. 125'-11"

T/O RIDGE 1
EL. 123'-8"

FINISH FLOOR
EL. 100'-0"


T/O RIDGE 3
EL. 132'-7"

MEAN HEIGHT LEVEL
EL. 127'-5"

T/O RIDGE 2
EL. 125'-11"


T/O RIDGE 1
EL. 123'-8"

FINISH FLOOR
EL. 100'-0"

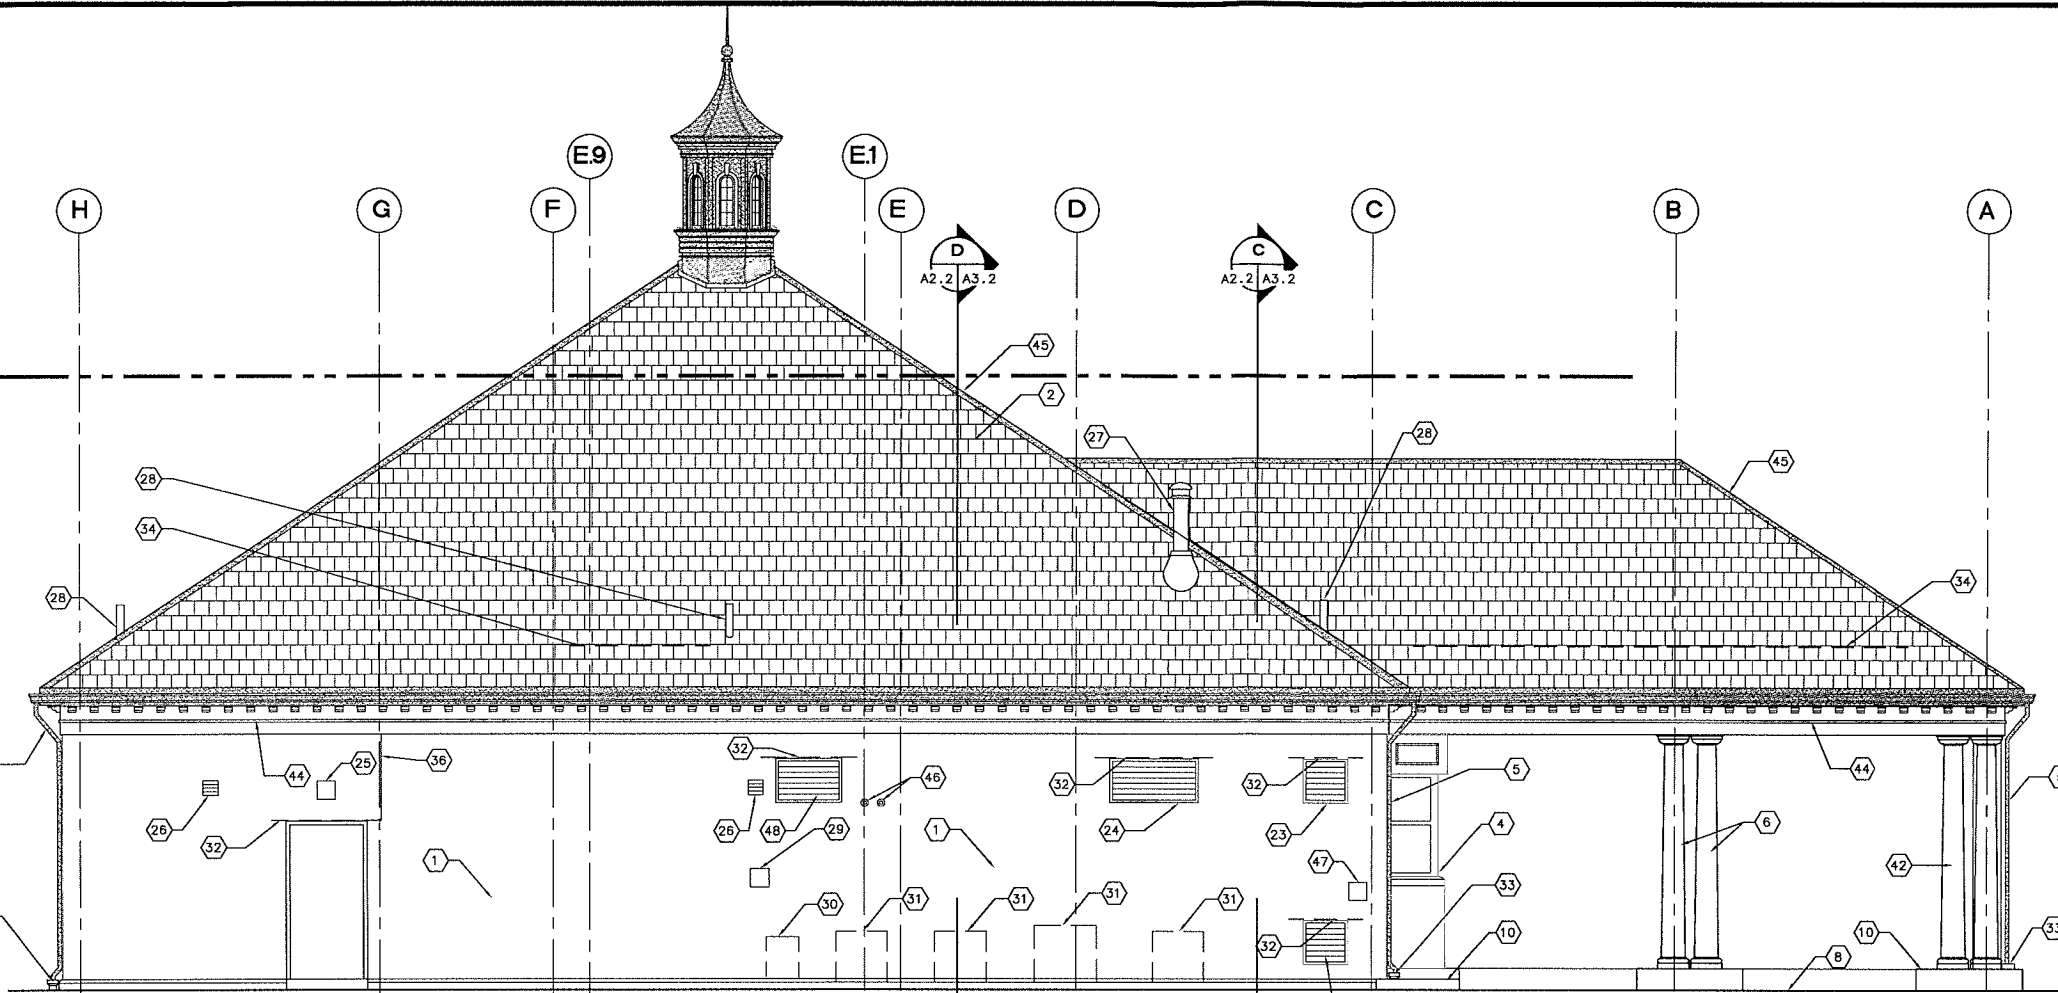

REAR (SOUTH) ELEVATION

 SCALE: 1/4"=1'-0"




KEYNOTES

NOT ALL KEYNOTES USED ON EACH SHEET

1. BRICK VENEER (TYPICAL).
2. SLATE ROOFING (TYPICAL).
3. EXTERIOR INSULATED FINISH SYSTEM (E.I.F.S.).
4. TELLER WINDOW BEYOND.
5. COPPER DOWNSPOUT.
6. COLUMN GFRC (TYPICAL).
7. MASONRY PIER. REFER TO STRUCTURAL DRAWINGS.
8. APPROX. FINISH GRADE, REFER TO CIVIL DRAWINGS.
9. PROFILE OF GABLE BEYOND.
10. CONCRETE CURB/ISLAND, REFER TO STRUCTURAL DRAWINGS.
11. COLUMN BEYOND, GFRC (TYPICAL).
12. MASONRY PIER BEYOND.
13. SUSPENDED ACOUSTICAL TILE GRID SYSTEM, REFER TO AB.1 SPECIFICATIONS.
14. TELLER COUNTER.
15. CHECK DESK.
16. RAILING.
17. COPPER GUTTER AND FASCIA.
18. LIGHT FIXTURE (TYPICAL), REFER TO ELECTRICAL DRAWINGS.
19. PAVEMENT AT DRIVE-THROUGH, REFER TO STRUCTURAL DRAWINGS.
20. GYPSUM BOARD CEILING SYSTEM.
21. 5/8" THICK EXTERIOR DRYWALL SYSTEM.
22. FINISH FLOOR.
23. COMBUSTION AIR LOUVER, REFER TO MECHANICAL DRAWINGS.
24. OUTSIDE AIR INTAKE LOUVER, REFER TO MECHANICAL DRAWINGS.
25. WALL PACK LIGHT FIXTURE, REFER TO ELECTRICAL DRAWINGS.
26. BRICK EXHAUST VENT, REFER TO MECHANICAL DRAWINGS.
27. GAS VENT, REFER TO MECHANICAL DRAWINGS.
28. PLUMBING VENT REFER TO PLUMBING DRAWINGS.
29. ELECTRICAL METER, REFER TO ELECTRICAL DRAWINGS.
30. GAS METER, REFER TO CIVIL AND MECHANICAL DRAWINGS.
31. CONDENSING UNIT, REFER TO CIVIL AND MECHANICAL DRAWINGS.
32. LINTEL, ANGLE 5 X 5 X 3/4" WITH 8" BEARING EACH END. PAINT.
33. DOWNSPOUT BOOT, REFER TO CIVIL DRAWINGS.
34. INDICATES SNOW GUARD LOCATION.
35. WALL SCONCE, REFER TO ELECTRICAL DRAWINGS.
36. MASONRY CONTROL JOINT.
37. STEEL TRUSS, REFER TO STRUCTURAL DRAWINGS.
38. ROOF STRUCTURE, REFER TO STRUCTURAL DRAWINGS.
39. LIGHT GAGE FRAMING, REFER TO STRUCTURAL DRAWINGS.
40. BOTTOM OF LIGHT GAGE TRUSS CHORD, REFER TO STRUCTURAL DRAWINGS.
41. FASCIA AND CROWN MOLDING, GFRC.
42. FACE OF BRICK PIER BEYOND.
43. CONCRETE CURB.
44. FASCIA, SOFFIT & DENTIL, GFRC.
45. COPPER HIP & RIDGE FLASHING.
46. CONCENTRIC VENTS, SEE MECHANICAL DRAWINGS.
47. BACK UP GENERATOR DISCONNECT, REFER TO ELECTRICAL DRAWINGS.
48. EXHAUST AIR LOUVER, REFER TO MECHANICAL DRAWINGS.

RIGHT (WEST) ELEVATION

 
SCALE: 1/4"=1'-0"



737 South Third Street
Louisville, KY 40202
502-585-4181
www.luckett-farley.com

[smart design]SM
Luckett & Farley
Architecture | Engineering | Interior Design

RIVER CITY BANK
14000 SHELBYVILLE ROAD
LOUISVILLE, KY 40245

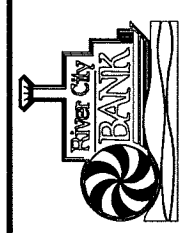

DATE	8/2/13
REVISIONS	4/19/13
1	DATE OF REVIEW
2	REVISION
3	REVISION
4	REVISION
5	REVISION
6	REVISION
7	REVISION
8	REVISION
9	REVISION
10	REVISION
11	REVISION
12	REVISION

COMB. NO.	2015.137
MADE BY	CNN
CHECKED	
DATE	04/18/16
EXTERIOR ELEVATIONS	
DRAWING NO.	810 PKG.
A2.2	