




Existing Rear Elevation




New Enlarged Porch

PROPOSED REAR ELEVATION

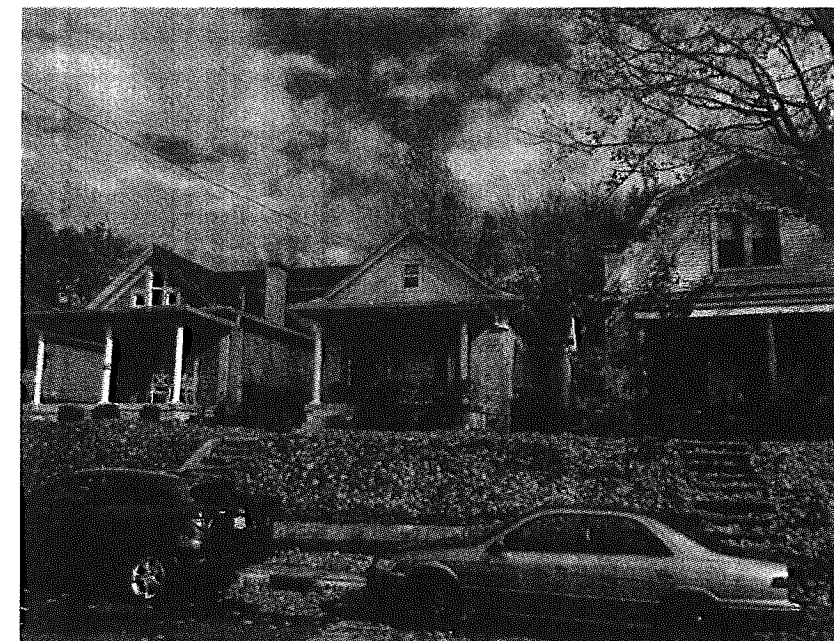


Existing Front Elevation

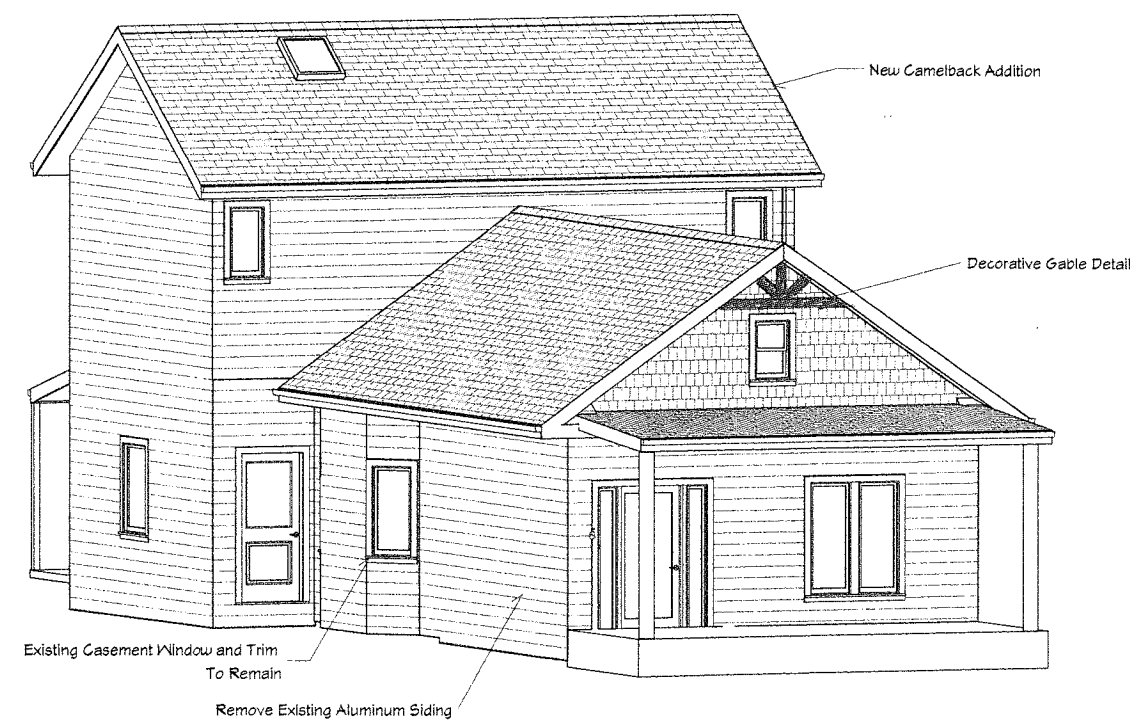

3D Front Elevation

RECEIVED
MAY 17 2016
PLANNING &
DESIGN SERVICES

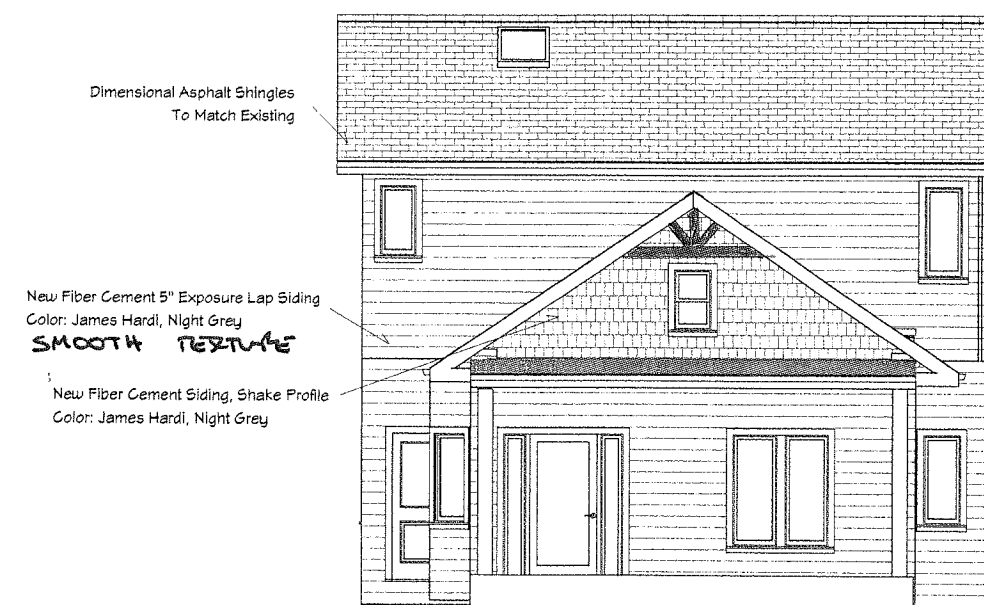

PROPOSED FRONT ELEVATION

REVISION TABLE	
NUMBER	DATE

225 Saunders Ave.
2nd Floor Addition

DRAWINGS PROVIDED BY:
Designer Builders


DATE:

5/16/2016

SCALE:

SHEET:

A#1

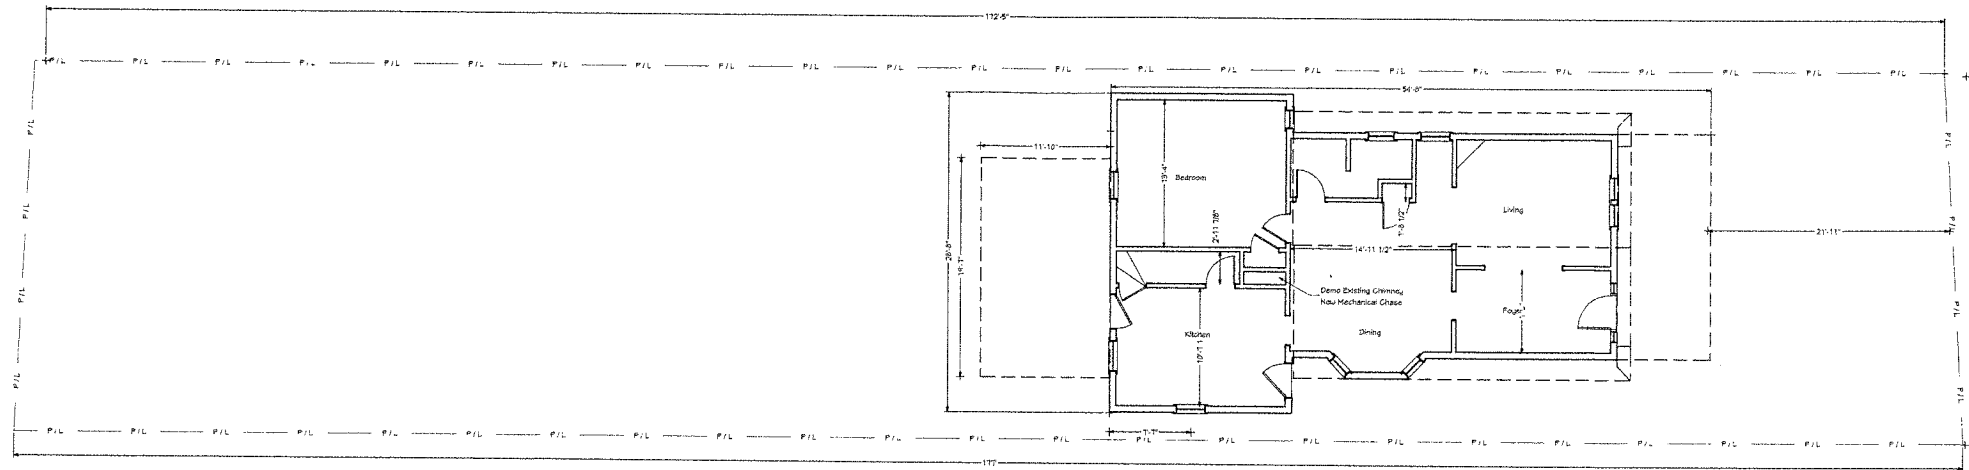

SITE PLAN

~~SCALE 1/8"~~
NOT TO SCALE

RECEIVED
MAY 17 2016
PLANNING &
DESIGN SERVICES



SAUNDERS
AVE.

REVISION TABLE	
NUMBER	DATE


DRAWINGS PROVIDED BY:
Designer Builders

DATE:
5/16/2016


SCALE:

SHEET:
S-1


OWENS CORNING DURATION DIMENSIONAL
ASPHALT SHIN (print at 1"=1')

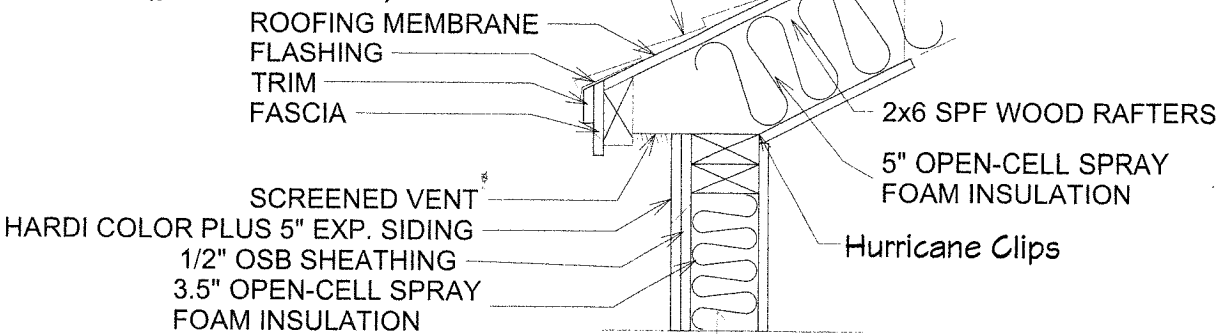

Eave Detail

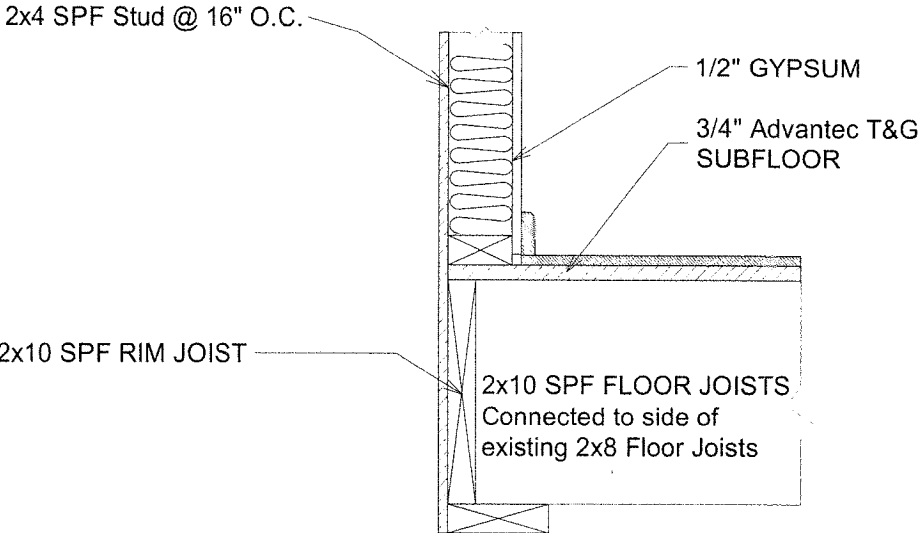

Floor Detail

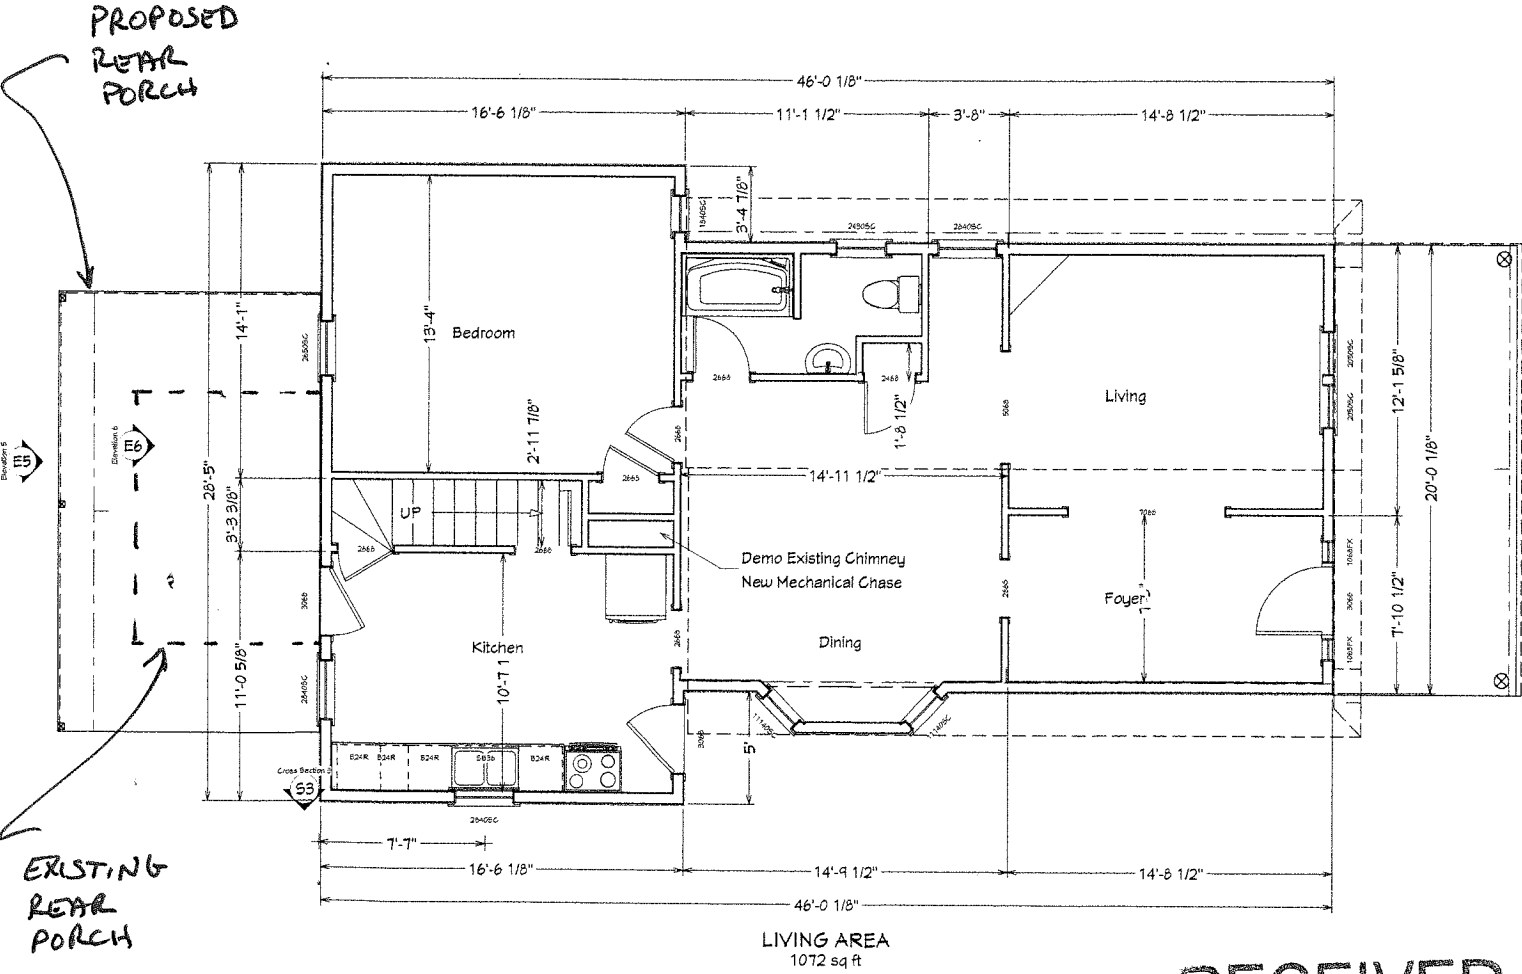

Scale: 1/4" = 1'-0"
NOT TO SCALE

RECEIVED


MAY 17 2016
PLANNING &
DESIGN SERVICES

REVISION TABLE	
NUMBER	DATE


225 Saunders Ave.
2nd Floor Addition

DRAWINGS PROVIDED BY:
Designer Builders

DATE:
5/16/2016
SCALE:
SHEET:
A-2

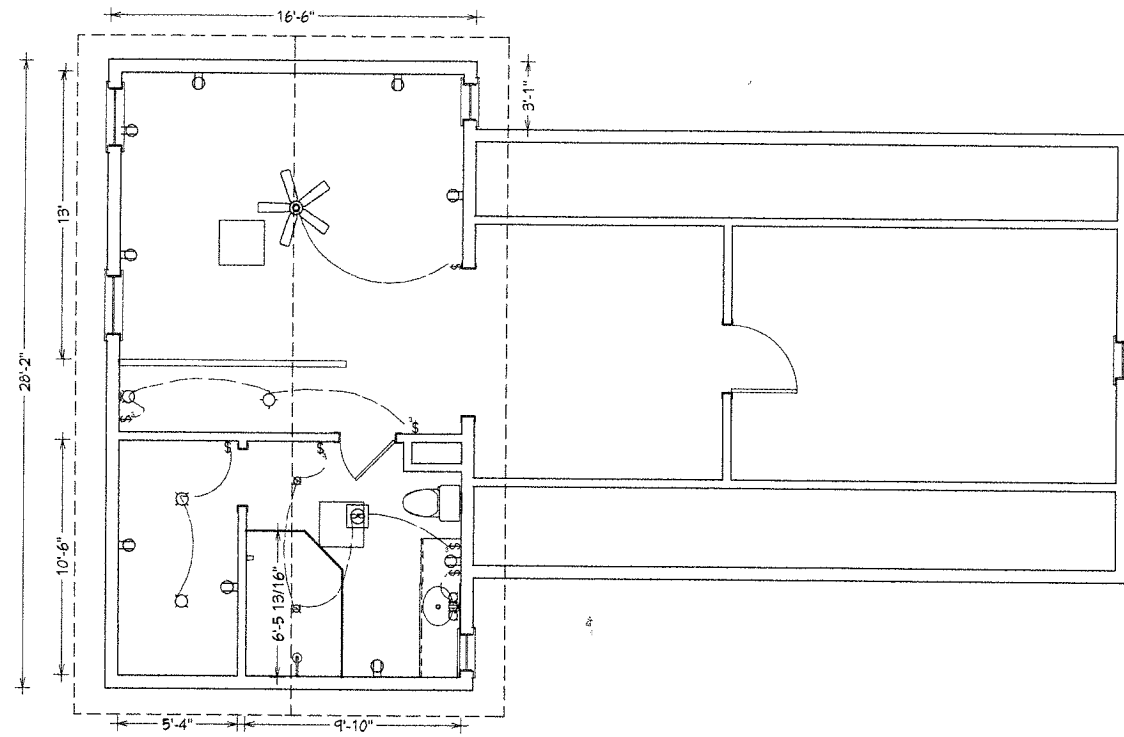

2ND FLOOR ELECTRICAL PLAN

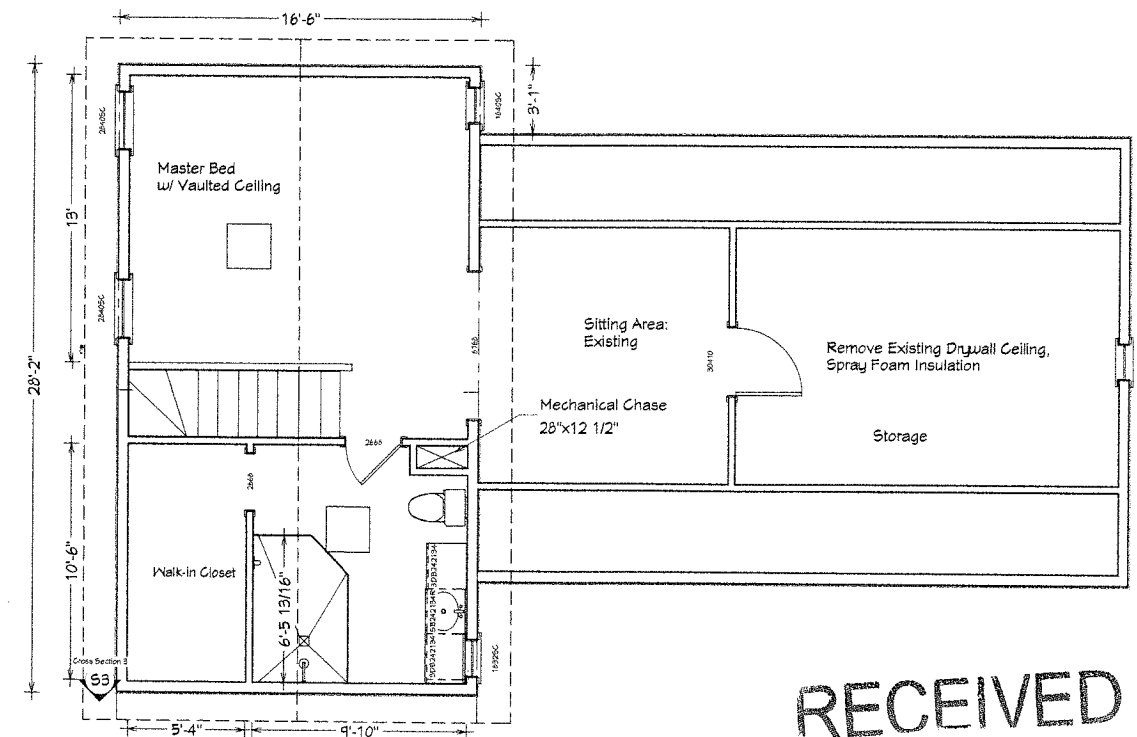

2ND FLOOR RENOVATION PLAN
1054 sq ft

Scale: 1/4" = 1'-0"
NOT TO SCALE

RECEIVED
MAY 17 2016
PLANNING &
DESIGN SERVICES

REVISION TABLE	
NUMBER	DATE

DRAWINGS PROVIDED BY:
Designer Builders

DATE:
5/16/2016
SCALE:
SHEET:
A-3