

ENGINEER

BRENT LIKINS
P.E. # 11448
**DESIGN-BUILD/ENGINEERING
AND CONSTRUCTION MANAGEMENT**
1522 GOSHEN LANE
GOSHEN, KENTUCKY 40026
**PHONE (502) 292-2279
FAX (502) 292-0364**

CONTRACTOR

DESIGN-BUILD-ENGINEERING
AND CONSTRUCTION MANAGEMENT
1522 GOSHEN LANE
GOSHEN, KENTUCKY 40026

PHONE (502)
FAX (502)

MY THREE JUNG, LLC
11601 SHELBURN ROAD
LOUISVILLE, KY. 40243

PHONE
FAX

OWNER MY THREE TONS, LLC.
9933 BARDSTOWN ROAD
LOUISVILLE, KY 40218

SHEET TITLE

NO	REVISIONS	DATE

Date _____

Scale
 $1'' = 10'-0''$

Drawn By


SHEET

C-
SITE

DEC 21 2020

**PLANNING & DESIGN
SERVICES**


THIS SITE DRAWING DEPICTS APPROX. DISTANCES AND IS NOT INTENDED AS A SURVEY OF THE SITE.

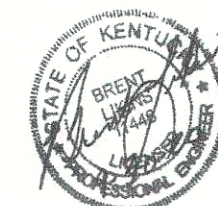

LIFE SAFETY PATHWAYS			
LOCATION	COMMON PATH	TOTAL TRAVEL DISTANCE	
		DOOR NUMBER	EXIT 101
A	44'-8"	76'-0"	45'-0"
B	30'-0"	60'-0"	
C	30'-0"		

PATHWAY KEY PLAN:

- TRAVEL PATH W/ DIRECTION OF FLOW
- TRAVEL PATH STARTING LOCATION, WHERE "X" = LOCATION COLUMN IN THIS TABLE
- COMMON PATH LOCATION, WHERE "X" = LOCATION COLUMN IN THIS TABLE
- EXIT DOOR LOCATION, WHERE "X" = DOOR IN THIS TABLE AND IN DOOR FINISH SCHEDULE

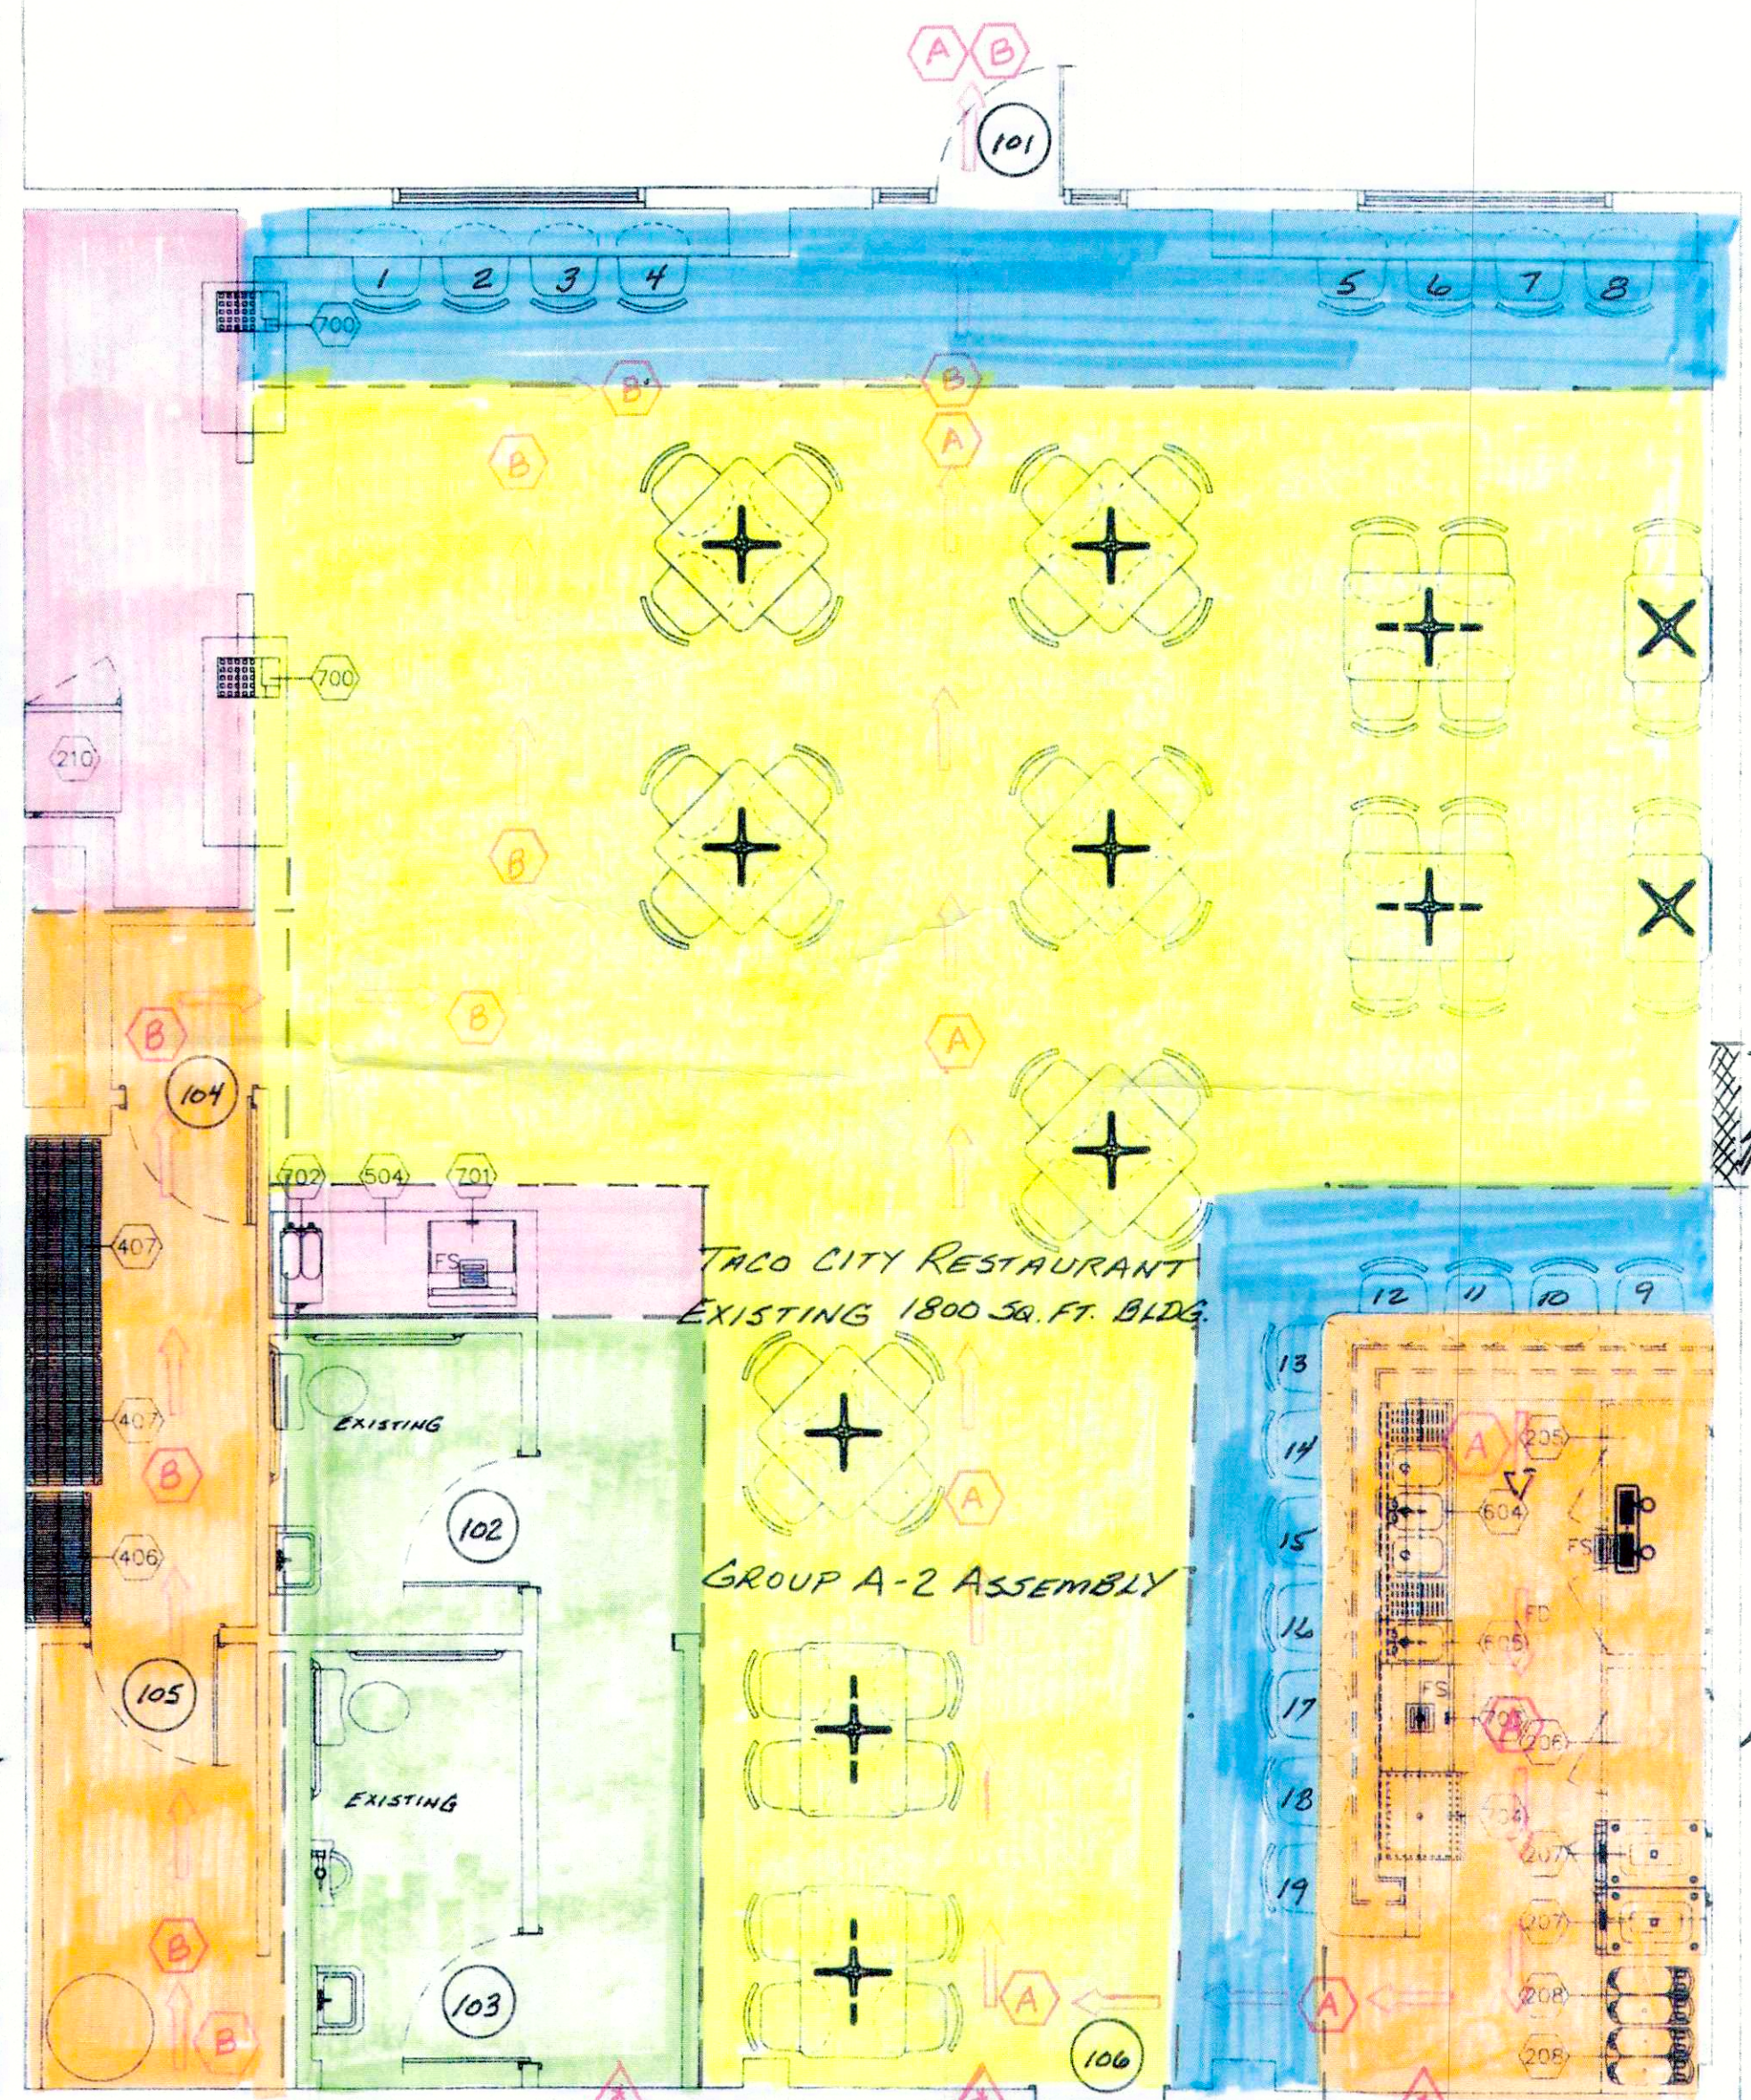



EQUIPMENT SCHEDULE			
COOKING EQUIPMENT			
100	6 BURNER HOT PLATE	ATOSA	ICV-1
101	12'-0" EXHAUST HOOD (CLASS II) W/MAKE UP AIR	CHEF-AIR	CUSTOM
102	48" GRIDDLE	ATOSA	MGA-4828
103	40 LB. FRYER	ATOSA	IFS-75
104	75 LB. FRYER	ATOSA	IFS-75
105	GAS HOSES	BK RESOURCES	VARIES
106	SPARE		
107	SPARE		
REFRIGERATION			
200	WALK-IN COOLER	AMERKOO	CUSTOM
201	ICE MACHINE W/BIN	MANITOWOC	SD1002A (BY OWNER)
202	60" REFRIGERATED SANDWICH PREP. TABLE (24 PAN)	ATOSA	MSF8307
203	TWO DOOR FREEZER	ATOSA	MBF8002
204	SINGLE DOOR REFRIGERATOR	ATOSA	MCF8705
205	69" BACK BAR KEG COOLER	FAGOR	FD0-95
206	69" GLASS DOOR BACK BAR REFRIGERATOR	TRUC	(BY OWNER)
207	FROZEN DRINK MACHINE/DISPENSER	FAGOR	FBB-59G
208	FROZEN DRINK MACHINE/DISPENSER	SAN-SERVE	704
209	27" REFRIGERATED SANDWICH PREP. TABLE	ATOSA	
210	SINGLE DOOR DISPLAY REFRIGERATOR		
211	SPARE		
212	SPARE		
213	SPARE		
WARMING EQUIPMENT			
300	3-DRAWER WARMING DRAWER	TEXICAN	TCD-1 (BY OWNER)
301	48" HEAT LAMP W/LIGHTS	NEMCO	6155-60-SL-208
302	72" HEAT LAMP W/LIGHTS	NEMCO	6155-60-SL-208
303	60" HEAT LAMP W/LIGHTS	NEMCO	6155-60-SL-208
304	5-WELL HOT FOOD TABLE	KLINGER	SW-4H-120
305	MICROWAVE OVEN	SERVWARE	EMW-1000SD
306	SPARE		
307	SPARE		
SHELVING			
400	DRY STORAGE WIRE SHELVING (4 SHELVES, 4 POSTS)	SERVWARE	VARIES (COATED)
401	COOLER SHELVING (4 SHELVES, 4 POSTS)	SERVWARE	VARIES (COATED)
402	12"X 48" S/S WALL SHELF	SERVWARE	SSWS1448-CWP
403	14"X 48" S/S WALL SHELF	SERVWARE	SSWS1448-CWP
404	14"X 36" WIRE SHELF WALL MOUNTED	SERVWARE	SL1436CWP W/SLWB14-CWP
405	18"X 36" WIRE SHELF WALL MOUNTED	SERVWARE	SL1836CWP W/SLWB18-CWP
406	POST MIX RACK	BY VENDOR	
407	WIRE SHELVING (4 SHELVES, 4 POSTS)	SERVWARE	SC48SL-CWP
408	60" DOUBLE OVERSHELF	ADVANCE	DTA-79
409	79" DOUBLE OVERSHELF	ADVANCE	DTA-79
410	27" DOUBLE OVERSHELF	ADVANCE	DTA-79
411	38" DOUBLE OVERSHELF	ADVANCE	DTA-79
412	18"X 60" DISH CABINET	SERVWARE	SR42-CWP
413	18"X 84" DISH CABINET	ADVANCE	DC-187
414	SPARE		
415	SPARE		
416	SPARE		
PREPARATION EQUIPMENT			
500	30"X 48" S/S WORK TABLE	BY OWNER	
501	38" EQUIPMENT STAND ON CASTERS	ADVANCE	EX-SS-309
502	48" EQUIPMENT STAND ON CASTERS	SERVWARE	T3048CWP-16BS
503	38" OPEN BASE S/S WORK TABLE	SERVWARE	T3030CWP-3
504	30"X 76" BEVERAGE TABLE	ADVANCE	T1830CWP-3
505	SPARE		
506	SPARE		
507	SPARE		
SINKS & CLEAN AREAS			
600	MOP SINK	EXISTING	EXISTING
601	HAND SINK	EXISTING	EXISTING
602	WATER FILTER	3M	5616003
603	3-COMPARTMENT SINK W/PRE-RINSE	SERVWARE	E30CWP18242-18
604	UNDERBAR 3-COMPARTMENT SINK	BK RESOURCES	BKUBW-360TS
605	UNDERBAR HAND SINK W/SOAP DISPENSER	BY OWNER	
606	25/50 GREASE TRAP	SERVWARE	CD76QL-CWP
607	SPARE		
608	SPARE		
609	SPARE		
SERVING EQUIPMENT			
700	P.O.S.	BY OWNER	
701	POST MIX/ICE DISPENSER	VENDOR	VENDOR
702	ICE TEA BREWER/DISPENSER	VENDOR	VENDOR
703	30" ICE CHEST W/7 CIRCUIT COLD PLATE	BK RESOURCES	BKIB-CP7-3012-1BS
704	GLASS STORAGE SHELF	BK RESOURCES	BKUBCC-242
705	SPARE		
706	SPARE		
707	SPARE		

EXISTING BUILDING

GROUP M-MERCANTILE

EXISTING SEPARATION WALL
8" CMU WITH 2 LAYERS OF
5/8" DRYWALL TO ROOF LINE.
2 HR. FIRE RATING

THREE 8'x10' OVERHEAD DOORS WERE REMOVED AT THESE THREE LOCATIONS. THEY WERE INFILLED WITH 4" METAL STUDS, INSULATION, 5/8" DRYWALL (EXTERIOR SIDE) 1/2" DENSGLASS SHEATHING AND E.I.F.S. ON THE EXTERIOR WALL. PER TABLE 508.3.3 THIS WALL SECTION SHALL BE BETWEEN A COMMERCIAL KITCHEN AND RESTAURANT SEATING AREAS THEY SERVE AND NEED NOT BE FIRE RATED.

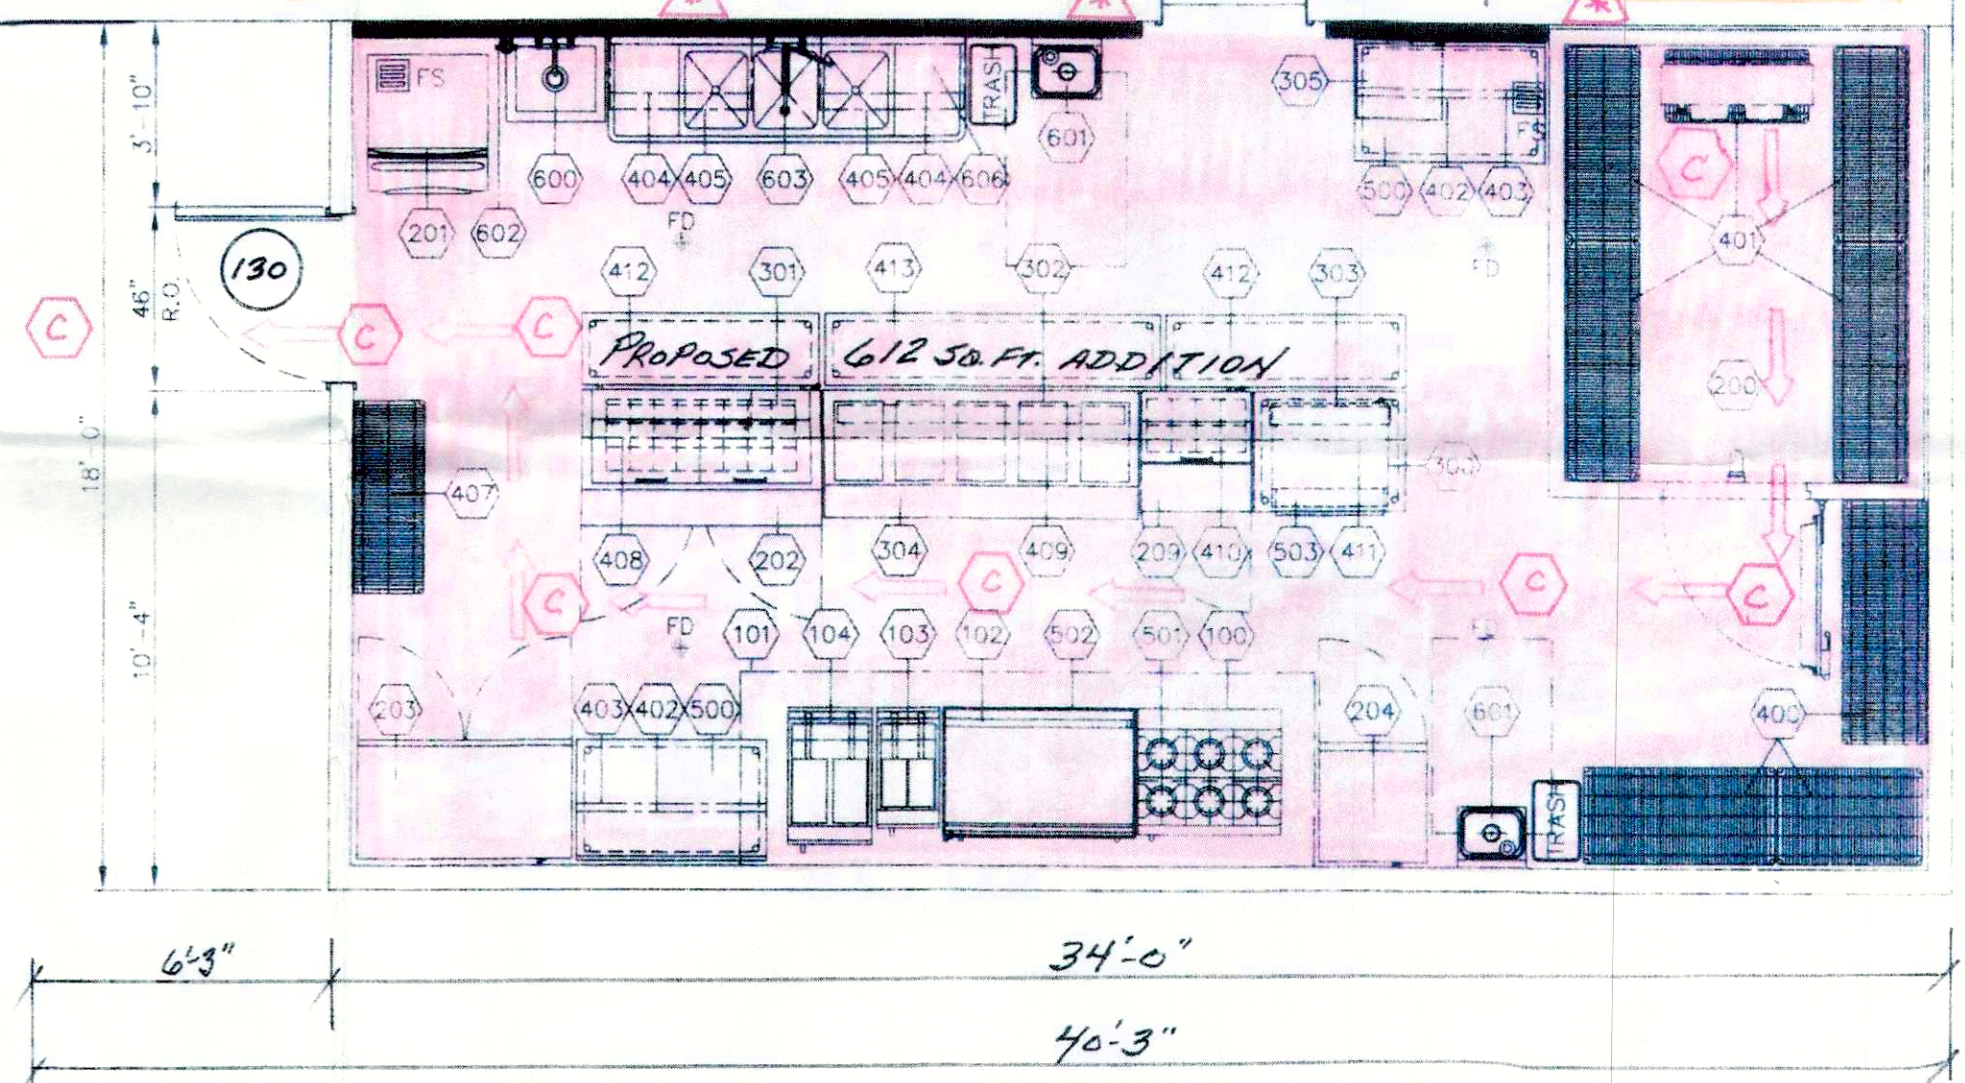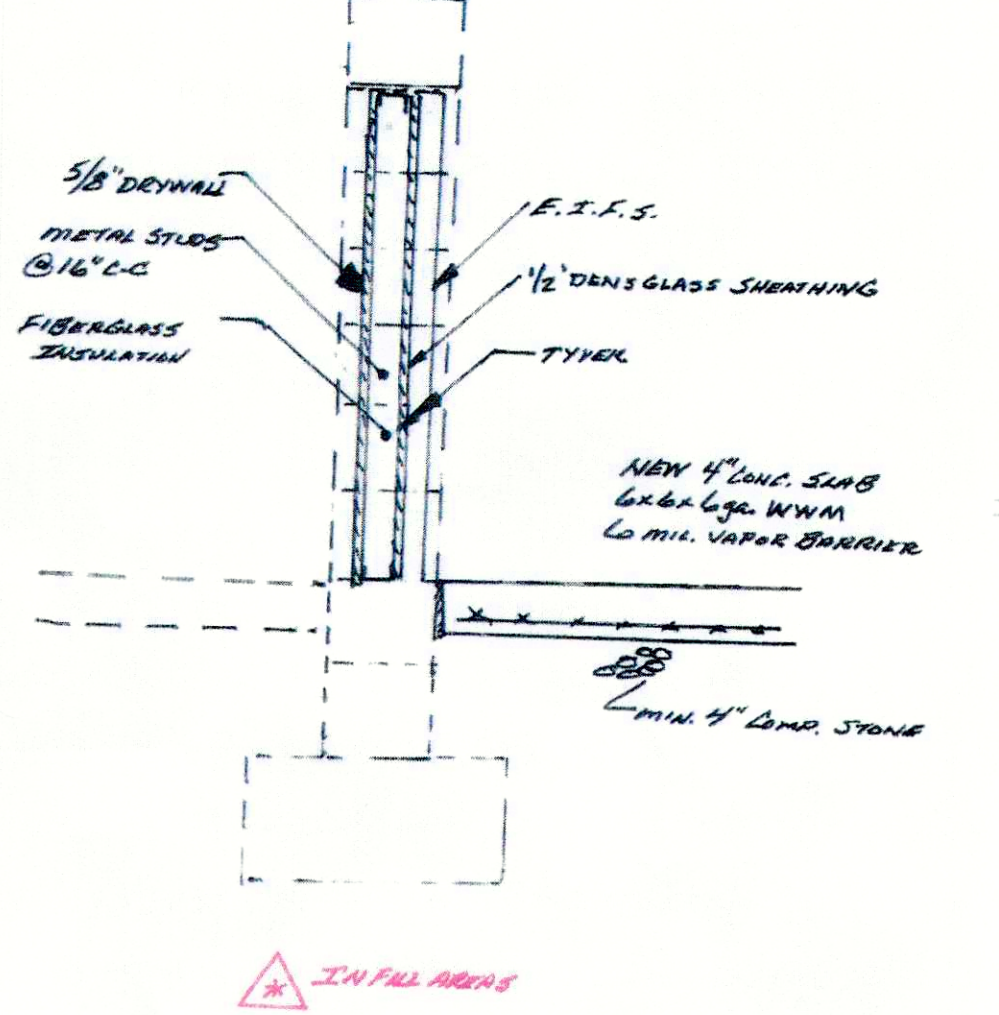

PROPOSED EQUIPMENT LAYOUT & FLOOR PLAN

SCALE: 1/4" = 1'-0"

OCCUPANT LOAD			
KITCHEN & CARRY OUT	17'-0"X34'-0" + 6'-8"X3'-0" + 5'-6"X15'-0" = 700.5 FT ² ÷ 200		4
RESTROOMS & HALLWAY	10'-0"X17'-0" = 170.0 FT ² ÷ 100 GENERAL BUSINESS		2
MECH. ROOM & HALLWAY	6'-0"X27'-0" = 162.0 FT ² ÷ 100 GENERAL BUSINESS		2
BAR AREA	9'-0"X18'-0" = 162.0 FT ² ÷ 100 GENERAL BUSINESS		2
FIXED BAR SEATING	ACTUAL COUNT		19
OPEN REST. SEATING	8'-0"X17'-0" + 6'-0"X16'-0" + 16'-0"X34'-0" = 776 FT ² ÷ 15		52
TOTAL			81

BUILDING CODE-KBC - 2013

ACCESSIBILITY CODE-ADAA/ANSI 117.1 - 2010

PER TABLE 508.3.3 COMMERCIAL KITCHENS NEED NOT BE SEPARATED FROM THE RESTAURANT SEATING AREAS THEY SERVE.

CONSTRUCTION TYPE 3B

BOARD OF HEALTH 5TH 6598 APPROVAL IS REQUIRED.

Seating Profile	
Dining Seating	52
Bar Seating	19
Total Seating	71

RECEIVED
DEC 21 2020
PLANNING & DESIGN
SERVICES

REV-2 PER
LOW METRO COMMENTS
12-5-20

Chef Supply
1512 W. Main Street
Louisville
Kentucky, 40203
502.585.1907
Fax: 502.585.1961

THESE LAYOUTS ARE THE PROPERTY OF CHEF SUPPLY. THESE LAYOUTS ARE FOR REFERENCE ONLY. CHEF SUPPLY IS NOT AN ENGINEERING FIRM AND DOES NOT ACCEPT THE RESPONSIBILITY OF ANY DISCREPANCIES DEALING WITH ELECTRICAL, PLUMBING, OR CODE ISSUES.

Taco City
11601 Shelbyville Road
Louisville, KY 40243

PROPOSED
FLOOR PLAN
Occupant Load

number: TacoCity.dwg
date: October 06, 2020
revised:
by: Scott W. Rude
checked:
by:
drawing no:
EQ-1
sheet no:
1 of 3

20-VARIANCE-0175