





1 FRONT ELEVATION (SOUTH)
SCALE: 3/16" = 1'-0"

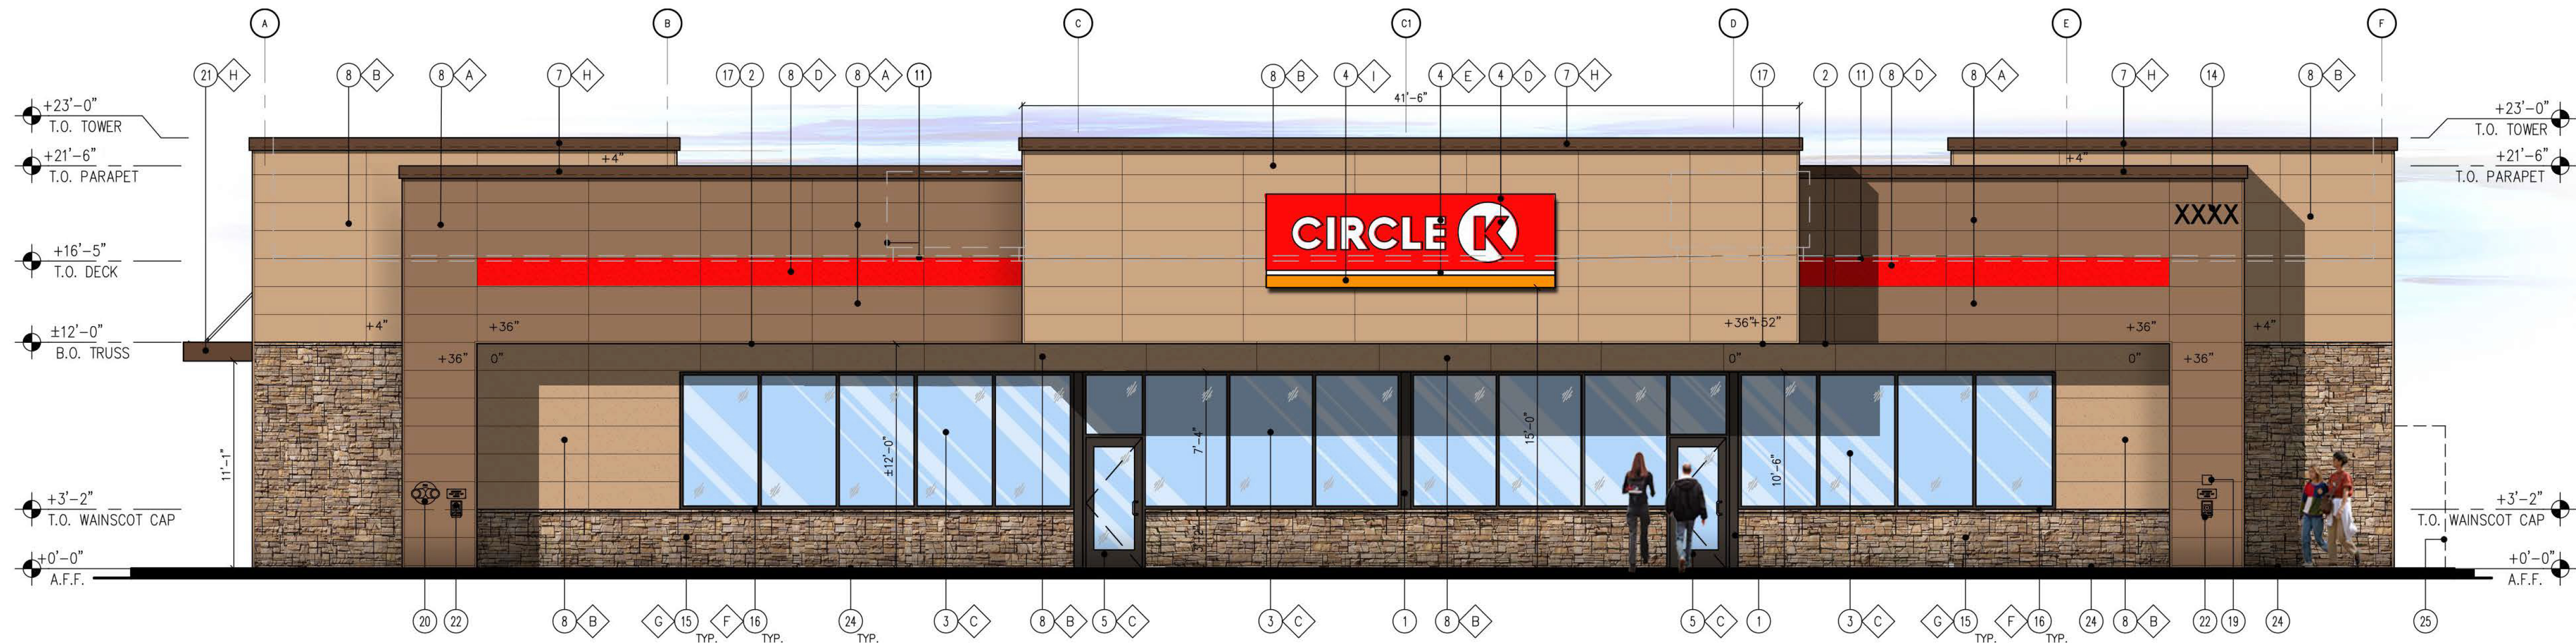

2 BACK ELEVATION (NORTH)
SCALE: 3/16" = 1'-0"

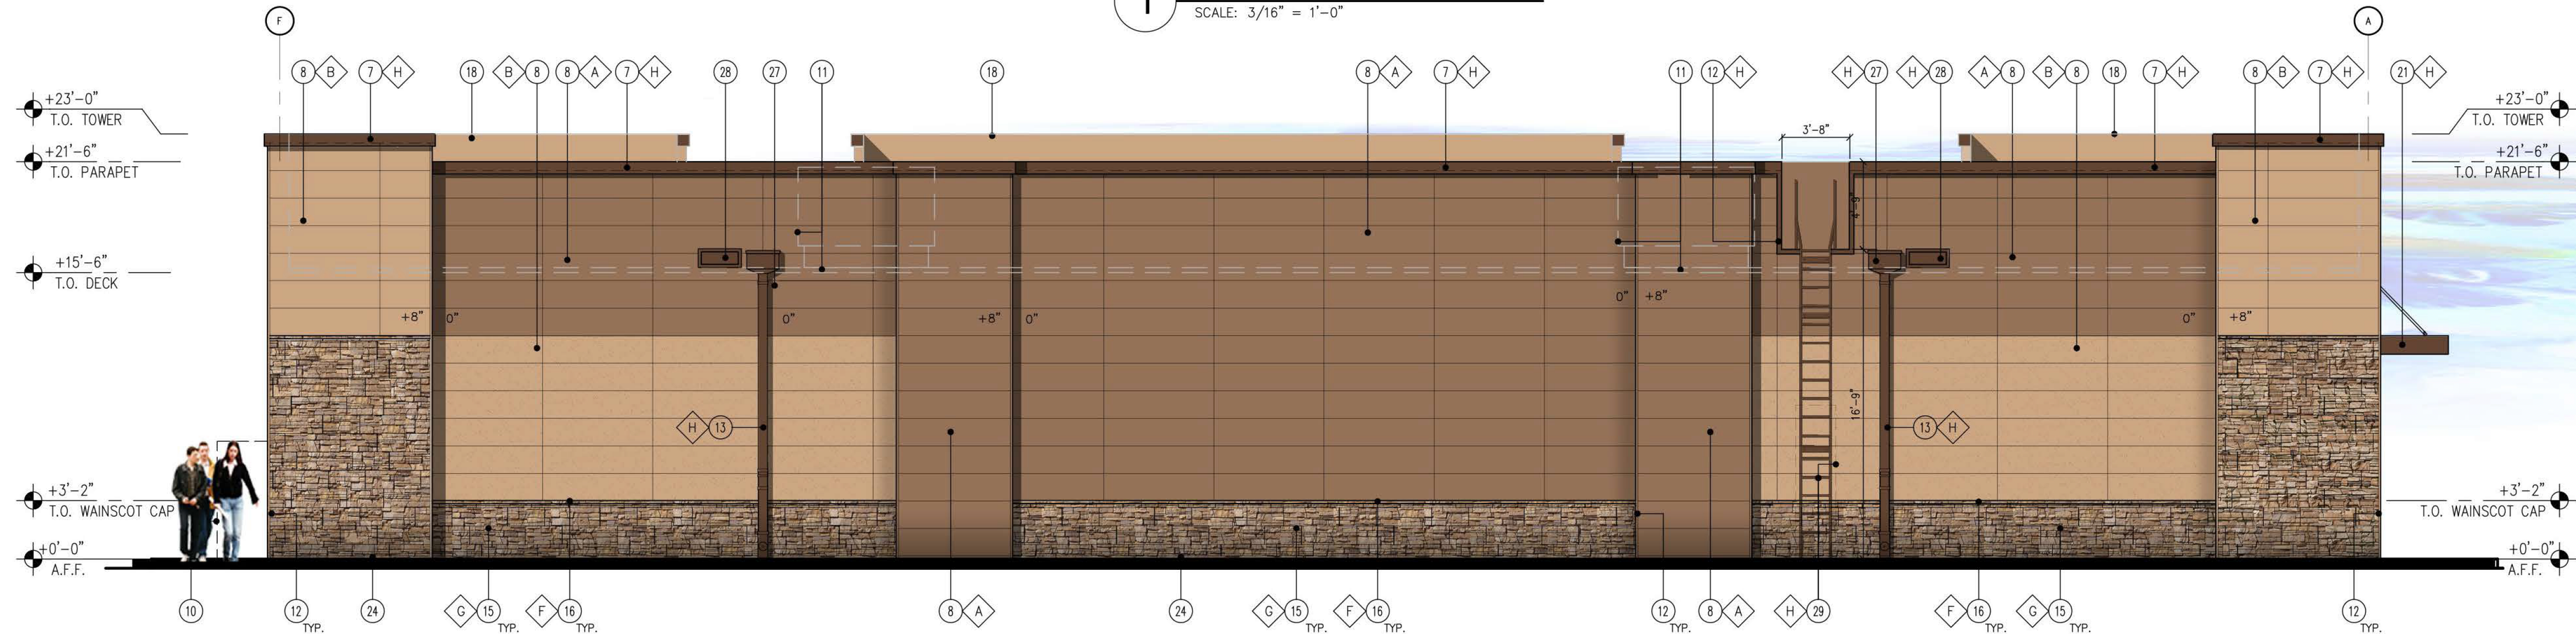

3 SIDE ELEVATION (EAST)
SCALE: 3/16" = 1'-0"



4 SIDE ELEVATION (WEST)
SCALE: 3/16" = 1'-0"

KEY NOTES

1. STEEL COLUMN WRAP WITH BREAK METAL
2. LINE OF CANOPY / SOFFIT
3. DARK BRONZE ANODIZED WINDOW FRAME W/ CLEAR GLASS WINDOW SYSTEM
4. INTERNALLY ILLUMINATED SIGN (UNDER SEPARATE PERMIT)
5. DARK BRONZE ANODIZED DOOR W/ CLEAR GLASS STOREFRONT SYSTEM
6. SERVICE DOOR, PAINT TO MATCH SURROUNDING WALL
7. PRE-FINISHED METAL COPING
8. NICHHA FIBER CEMENT WALL PANEL SYSTEM
9. WALL MOUNTED LIGHT FIXTURE, COLOR: BLACK. SEE ELECTRICAL PLAN
10. SES PANEL LOCATION. SEE ELECTRICAL PLAN
11. ROOF LINE AND HVAC UNITS
12. 1-1/2" STAINLESS STEEL CORNER KEY EDGE, TYP. TO ALL CORNERS
13. DOWNSPOUT, RE: PLUMBING PLAN
14. ADDRESSING LOCATION: 8" TALL INCH BLACK NUMBERS. FINAL AREA LOCATION TO BE DETERMINED BY FIRE DEPARTMENT.
15. 1 3/8" THK. X 6" NICHHA KURASTONE HIGH FIBER CEMENT WAINSCOT
16. 1-1/2" HIGH NICHHA FIBER CEMENT CAP INSTALL PER MFR. SPECS.
17. NICHHA ESSENTIAL "OVERHANG" FLASHING
18. PARAPET WALL BEYOND
19. (KNOX) KEY-BOX AT 6'-0" AFF (IF REQUIRED BY FIRE DEPARTMENT)
20. FIRE DEPARTMENT CONNECTION (IF REQUIRED)
21. ALUMINUM AWNING WITH SUPPORT RODS ABOVE THE SIDE ENTRY DOOR BY CIRCLE K VENDOR. PROVIDE BLOCKING IN EXTERIOR WALL FOR AWNING AND SUPPORTS
22. EMERGENCY FUEL SHUT-OFF SWITCH, REFER TO SHEET F1.0 - FUEL PIPING FLOOR PLAN
23. INSULATED METAL DOOR
24. NICHHA ESSENTIAL "STARTER" FLASHING
25. CO2 TANK WITH METAL LOUVERED CONTAINER
26. EXTERIOR FINISH TO EXTEND ABOVE SIDEWALK/GRADE, SEE DET. 8/AS.1 & 11/AS.1
27. LEADER BOX. SEE PLUMBING DWGS.
28. EMERGENCY OVERFLOW SCUPPER. SEE PLUMBING DWGS.
29. METAL ROOF ACCESS LADDER WITH SECURITY DOOR

FINISH SCHEDULE

- A - ***NICHHA TUFF BLOCK
- COLOR TO MATCH #SW 6095 TOASTY
 - B - ***NICHHA TUFF BLOCK
- COLOR TO MATCH #SW 6115 TOTALLY TAN
 - C - 1" INSULATED, DOUBLE PANED CLEAR GLASS
 - D - *SHERWIN WILLIAMS #SW 4081
- **SAFETY RED
 - E - *SHERWIN WILLIAMS #SW 7005
- CIRCLE K WHITE
 - F - ***NICHHA CHISELED SILL TAN
 - G - ***NICHHA LEDGESTONE BLUFF
 - H - *SHERWIN WILLIAMS #SW 6090
- FIRESTONE MANSARD BROWN SR (USE FOR PRE-FINISHED METAL COPING)
 - I - CIRCLE K ORANGE #PMS 144
- * USE SHERWIN WILLIAMS MANUFACTURER ONLY
** COLOR TO BE PRE-ORDERED TO ENSURE AVAILABILITY AT TIME OF CONSTRUCTION
*** COORDINATE WITH OWNER'S REP